



THE COMPLETE CONSTRUCTION OF A NEW THREE-STORY POLICE HEADQUARTERS BUILDING, A NEW FOUR-STORY PARKING GARAGE INCLUDING THE NEW FIREARMS TRAINING FACILITY ON THE GROUND FLOOR, A NEW SERVICE YARD, AND PERIMETER SECURITY WALLS AND FENCES. THE WORK ALSO INCLUDES SITE DEVELOPMENT INCLUDING NEW SITE PUBLIC ACCESS ROADWAY FROM SOUTH PARK ROAD, HARDSCAPES, LANDSCAPING, AND SURFACE PARKING, FOR THE BUILDING SITE. THE POLICE HEADQUARTERS BUILDING WILL PROVIDE APPROXIMATELY 98,865 GROSS SQUARE FEET. THE STRUCTURED PARKING GARAGE HAS A CAPACITY OF APPROXIMATELY 283 CARS INCLUDING 9 OVERSIZED VEHICLE SPACES ON THE GROUND LEVEL. SECURE SURFACE PARKING IS PROVIDED FOR APPROXIMATELY 55 VEHICLES, AND PUBLIC PARKING FOR APPROXIMATELY 20 VEHICLES ON THE NEW ACCESS ROADWAY.

APPLICABLE CODES

- K. BUILDING CODE: FBC, 2020 –FLORIDA BUILDING CODE -7TH EDITION
- L. PLUMBING CODE: FBC –PLUMBING, 2020 -7TH EDITION
- M. MECHANICAL CODE: FBC –MECHANICAL, 2020 -7TH EDITION
- N. ELECTRICAL CODE: NEC, 2020 –NATIONAL ELECTRIC CODE / NFPA 70
- O. FIRE CODE: FFPC, 2020 FLORIDA FIRE PREVENTION CODE -7TH EDITION
- P. LIFE SAFETY CODE: NFPA 101, 2018 EDITION
- Q. AMERICANS WITH DISABILITIES ACT: FBC, 2020 -7TH EDITION
- R. FLORIDA ACCESSIBILITY CODE
- S. ENERGY CONSERVATION CODE: 2020 FLORIDA BUILDING CODE, ENERGY CONSERVATION, 7TH EDITION
- T. MUTCD
- U. FLORIDA GREENBOOK (FOR PUBLIC ROADWAYS)
- V. PROWAG

The map displays the Hollywood Hills and Park East neighborhoods in Los Angeles. Major roads shown include Johnson St, N 46th Ave, N 35th Ave, N Park Rd, S 35th Ave, S Park Rd, and the 95 Express (Toll road). The Hollywood Hills and Park East neighborhoods are labeled. A red hatched area near the intersection of S Park Rd and S 35th Ave is labeled 'AREA OF WORK'. The map also shows the Hollywood Hills Light Rail extension route, with stations at Hollywood Hills and Park East. A scale bar indicates 1" = 400'-0", and a north arrow is present.

MEETING DATES

DRAWING INDEX	
INDEX	
G-000	PRELIMINARY TAC MASTER INDEX
SURVEY	
VL-101	ALTA/NSPS LAND TITLE SURVEY
VT-101	SPECIFIC PURPOSE SURVEY VEGETATION ASSESMENT
ARCHITECTURE	
A-050	ARCHITECTURAL SITE PLAN
A-055	PROJECT DIAGRAMS
A-056	ACCESSIBILITY DIAGRAMS
A-101	LEVEL 1 - FLOOR PLAN
A-101A	LEVEL 1 - FLOOR PLAN - ALTERNATE
A-102	LEVEL 2 - FLOOR PLAN
A-103	LEVEL 3 - FLOOR PLAN
A-104	LEVEL 4 - FLOOR PLAN - DEDUCT ALTERNATE
A-105	ROOF PLAN
A-200	BUILDING ELEVATIONS
A-201	BUILDING ELEVATIONS
A-400	ENLARGED BUILDING SIGNAGE
A-401	ENLARGED WASTE MANAGEMENT ENCLOSURE
A-500	CANOPY / BRIDGE SECTIONS
A-900	BUILDING RENDERINGS
CIVIL	
C-001.	COVER SHEET
C-002.	GENERAL NOTES
C-003.	ENGINEERING PLAN
C-100.	EROSION CONTROL DETAILS
C-101.	EROSION CONTROL DETAILS
C-102.	EROSION CONTROL DETAILS
C-200.	SIGNAGE AND STRIPNG PLAN
C-300.	PAVING AND GRADING PLAN
C-301.	PAVING AND GRADING DETAILS
C-302.	CROSS SECTIONS
C-400.	DRAINAGE PLAN
C-410.	SOUTH PARK ROAD IMPROVEMENTS
C-501.	GENERAL UTILITY DETAILS
C-502.	GENERAL UTILITY DETAILS
C-503.	GENERAL UTILITY DETAILS
C-504.	GENERAL UTILITY DETAILS
C-505.	GENERAL UTILITY DETAILS

C-506.	WATER DETAILS
C-507.	WATER DETAILS
C-508.	WATER DETAILS
C-509.	WATER DETAILS
C-510.	SEWER DETAILS
C-511.	SEWER DETAILS
C-512.	SEWER DETAILS
LIGHTING	
E-011	SITE PHOTOMETRICS
TREE DISPOSITION	
TS-010	OVERALL SITE PLAN TREE SKETCH
TS-100	ENLARGED PARTIAL SITE PLAN - TREE SKETCH
TS-101	ENLARGED PARTIAL SITE PLAN - TREE SKETCH
LANDSCAPE	
L001.	GENERAL NOTES
L002.	COMPOSITE LANDSCAPE PLAN
L003	ILLUSTRATED LANDSCAPE PLAN
L101.	HARDSCAPE MATERIAL PLAN
L110.	HARDSCAPE MATERIAL PLAN - ENLARGEMENT
L201.	LAYOUT PLAN
L400.	PLANTING PLAN
L401.	PLANTING PLAN
L402.	PLANTING PLAN
L405.	IRRIGATION PLAN
L601.	SITE LIGHTING PLAN
L801.	DETAILS - HARDSCAPE
L802.	DETAILS - HARDSCAPE
L803.	DETAILS - HARDSCAPE
L901.	DETAILS - PLANTING
NEW POLICE HEADQUARTERS RADIO TOWER	
T-1	COVER SHEET
C-1.	SITE PLAN
C-2	ICE BRIDGE DETAILS AND COMPONENTS
C-3	ENCLOSED COMPOUND ANTENNA ACCESSORIES
C-4	DETAILS
C-6	NOTES
C-7	FOUNDATION PAD FOR COLLOCATION EQUIPMENT
C-8	ZONING FOR ANTENNA

EDWARD O'DONNELL
FL. ARCHITECT REG. NO.
AR95533

PROJECT


CITY OF HOLLYWOOD
NEW POLICE
HEADQUARTERS

ADDRESS : 401 S PARK RD HOLLYWOOD, FL 33021

SCALE: 1" = 400'-0"
SHEET SIZE: ARCH D (24"x36") DO NOT SCALE DRAWINGS.
DATE: 03/22/23
DRAWN BY: OOP
DRAWING TITLE:


**PRELIMINARY TAC
MASTER INDEX**

SHEET NO.
G-000

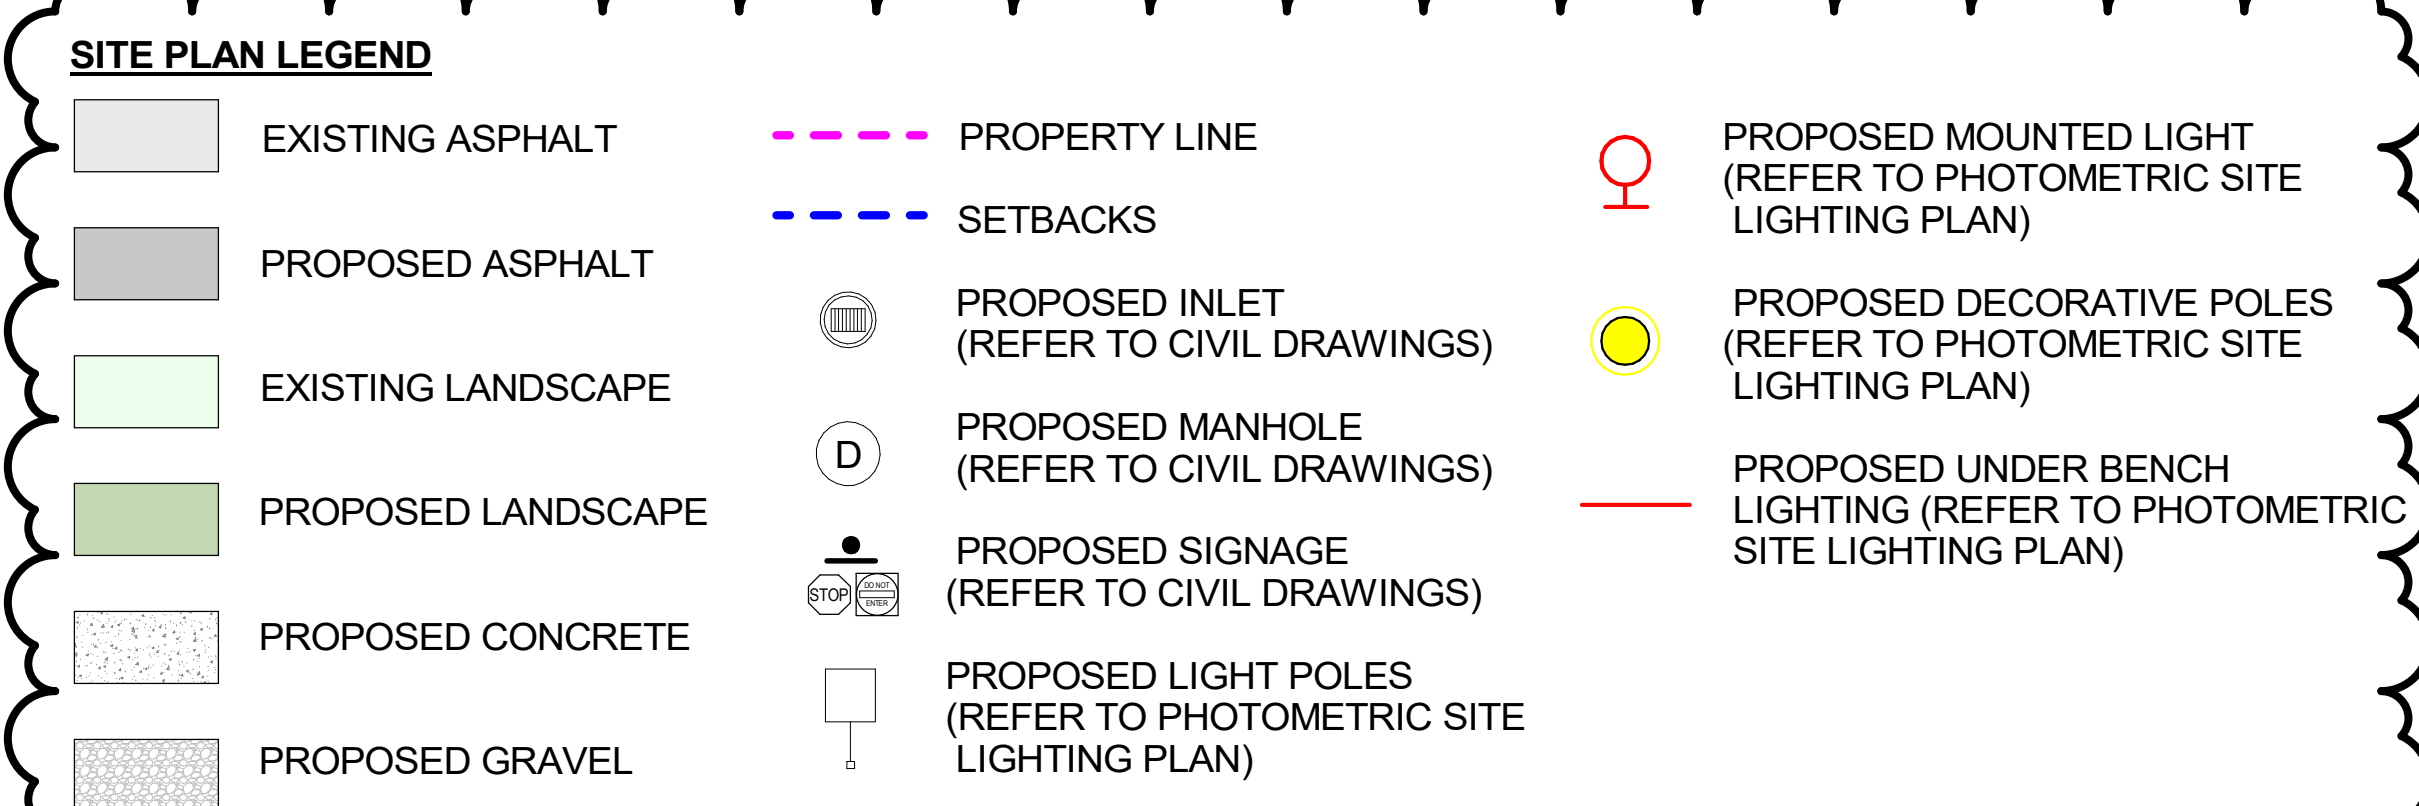

NOTE: 1. MAT PLANS WILL PROVIDE FOR THE CITY BUILDING PERMIT REVIEW.
DISCLAIMER: 1. AS PER CHAPTER 119, OF THE FLORIDA STATUTES (FLORIDA PUBLIC RECORDS LAW) PROVIDES THAT CERTAIN PUBLIC RECORDS ARE CONFIDENTIAL AND EXEMPT FROM PUBLIC DISCLOSURE IN ORDER TO PROTECT THE SECURITY OF SPECIFIC GOVERNMENTAL, FACILITIES, EMPLOYEES, AND VISITORS. FOR THE SAME SECURITY REASONS, THE CITY HAS THE STATUTORY OBLIGATION TO PROTECT SUCH RECORDS FROM PUBLIC DISCLOSURE AND ONLY DISCLOSE CONFIDENTIAL INFORMATION TO PARTIES WHO AGREE TO KEEP SUCH INFORMATION CONFIDENTIAL. 2. CONFIDENTIAL INFORMATION SHALL INCLUDE ALL INFORMATION OR MATERIAL, THAT IS CONFIDENTIAL OR EXEMPT ACCORDING TO THE FLORIDA PUBLIC RECORDS LAW. THE EXEMPTIONS MOST RELEVANT TO THE CONTRACTOR/CONSULTANT INCLUDE BUT ARE NOT LIMITED TO: - PLANS, BLUEPRINTS, DRAWINGS, AND DIAGRAMS WHICH DEPICT THE INTERNAL LAYOUT AND STRUCTURAL ELEMENTS OF A BUILDING OR OTHER STRUCTURE, INCLUDING N1, E911, OR PUBLIC SAFETY RADIO COMMUNICATION SYSTEM INFRASTRUCTURE PLANS, OWNED OR OPERATED BY THE CITY AND/OR BROWARD COUNTY. - SECURITY OR FIRE SAFETY SYSTEM PLANS, INCLUDING ALL RECORDS, INFORMATION, PHOTOGRAPHS, AUDIO AND VISUAL REPRESENTATIONS, SCHEMATIC DIAGRAMS, SURVEYS, RECOMMENDATIONS, OR CONSULTATIONS RELATING DIRECTLY TO THE PHYSICAL SECURITY OR FIRE SAFETY OF THE FACILITY OR REVEALING SECURITY OR FIRE SAFETY SYSTEMS

[illegible]

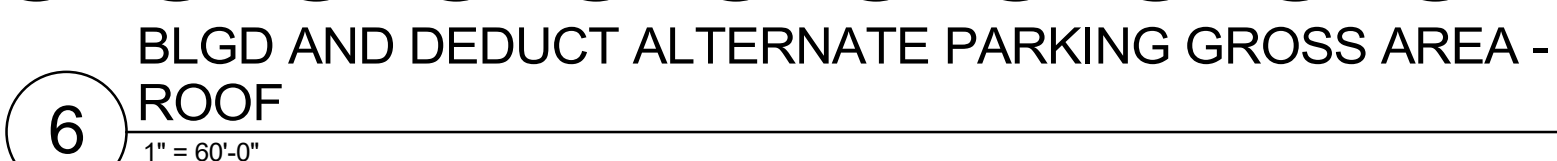

EDWARD O'DONNELL
FL ARCHITECT REG. NO:
AR93533



ARCHITECTURE AND DESIGN

2432 HOLLYWOOD BLVD. HOLLYWOOD, FL 33020
 T: 954.518.0833 | F: 954.518.0131
www.ogdarchitects.com

PROJECT

CITY OF HOLLYWOOD
NEW POLICE
HEADQUARTERS


ADDRESS : 401 S PARK RD HOLLYWOOD, FL 3302

[illegible]


SCALE: 1" = 60'-0"
SHEET SIZE: ARCH D (24"x36") DO NOT SCALE DRAWINGS.
DATE: 03/22/23
STARTED BY: COP
DRAWING TITLE:

PROJECT DIAGRAMS


SHEET NO.
A-055

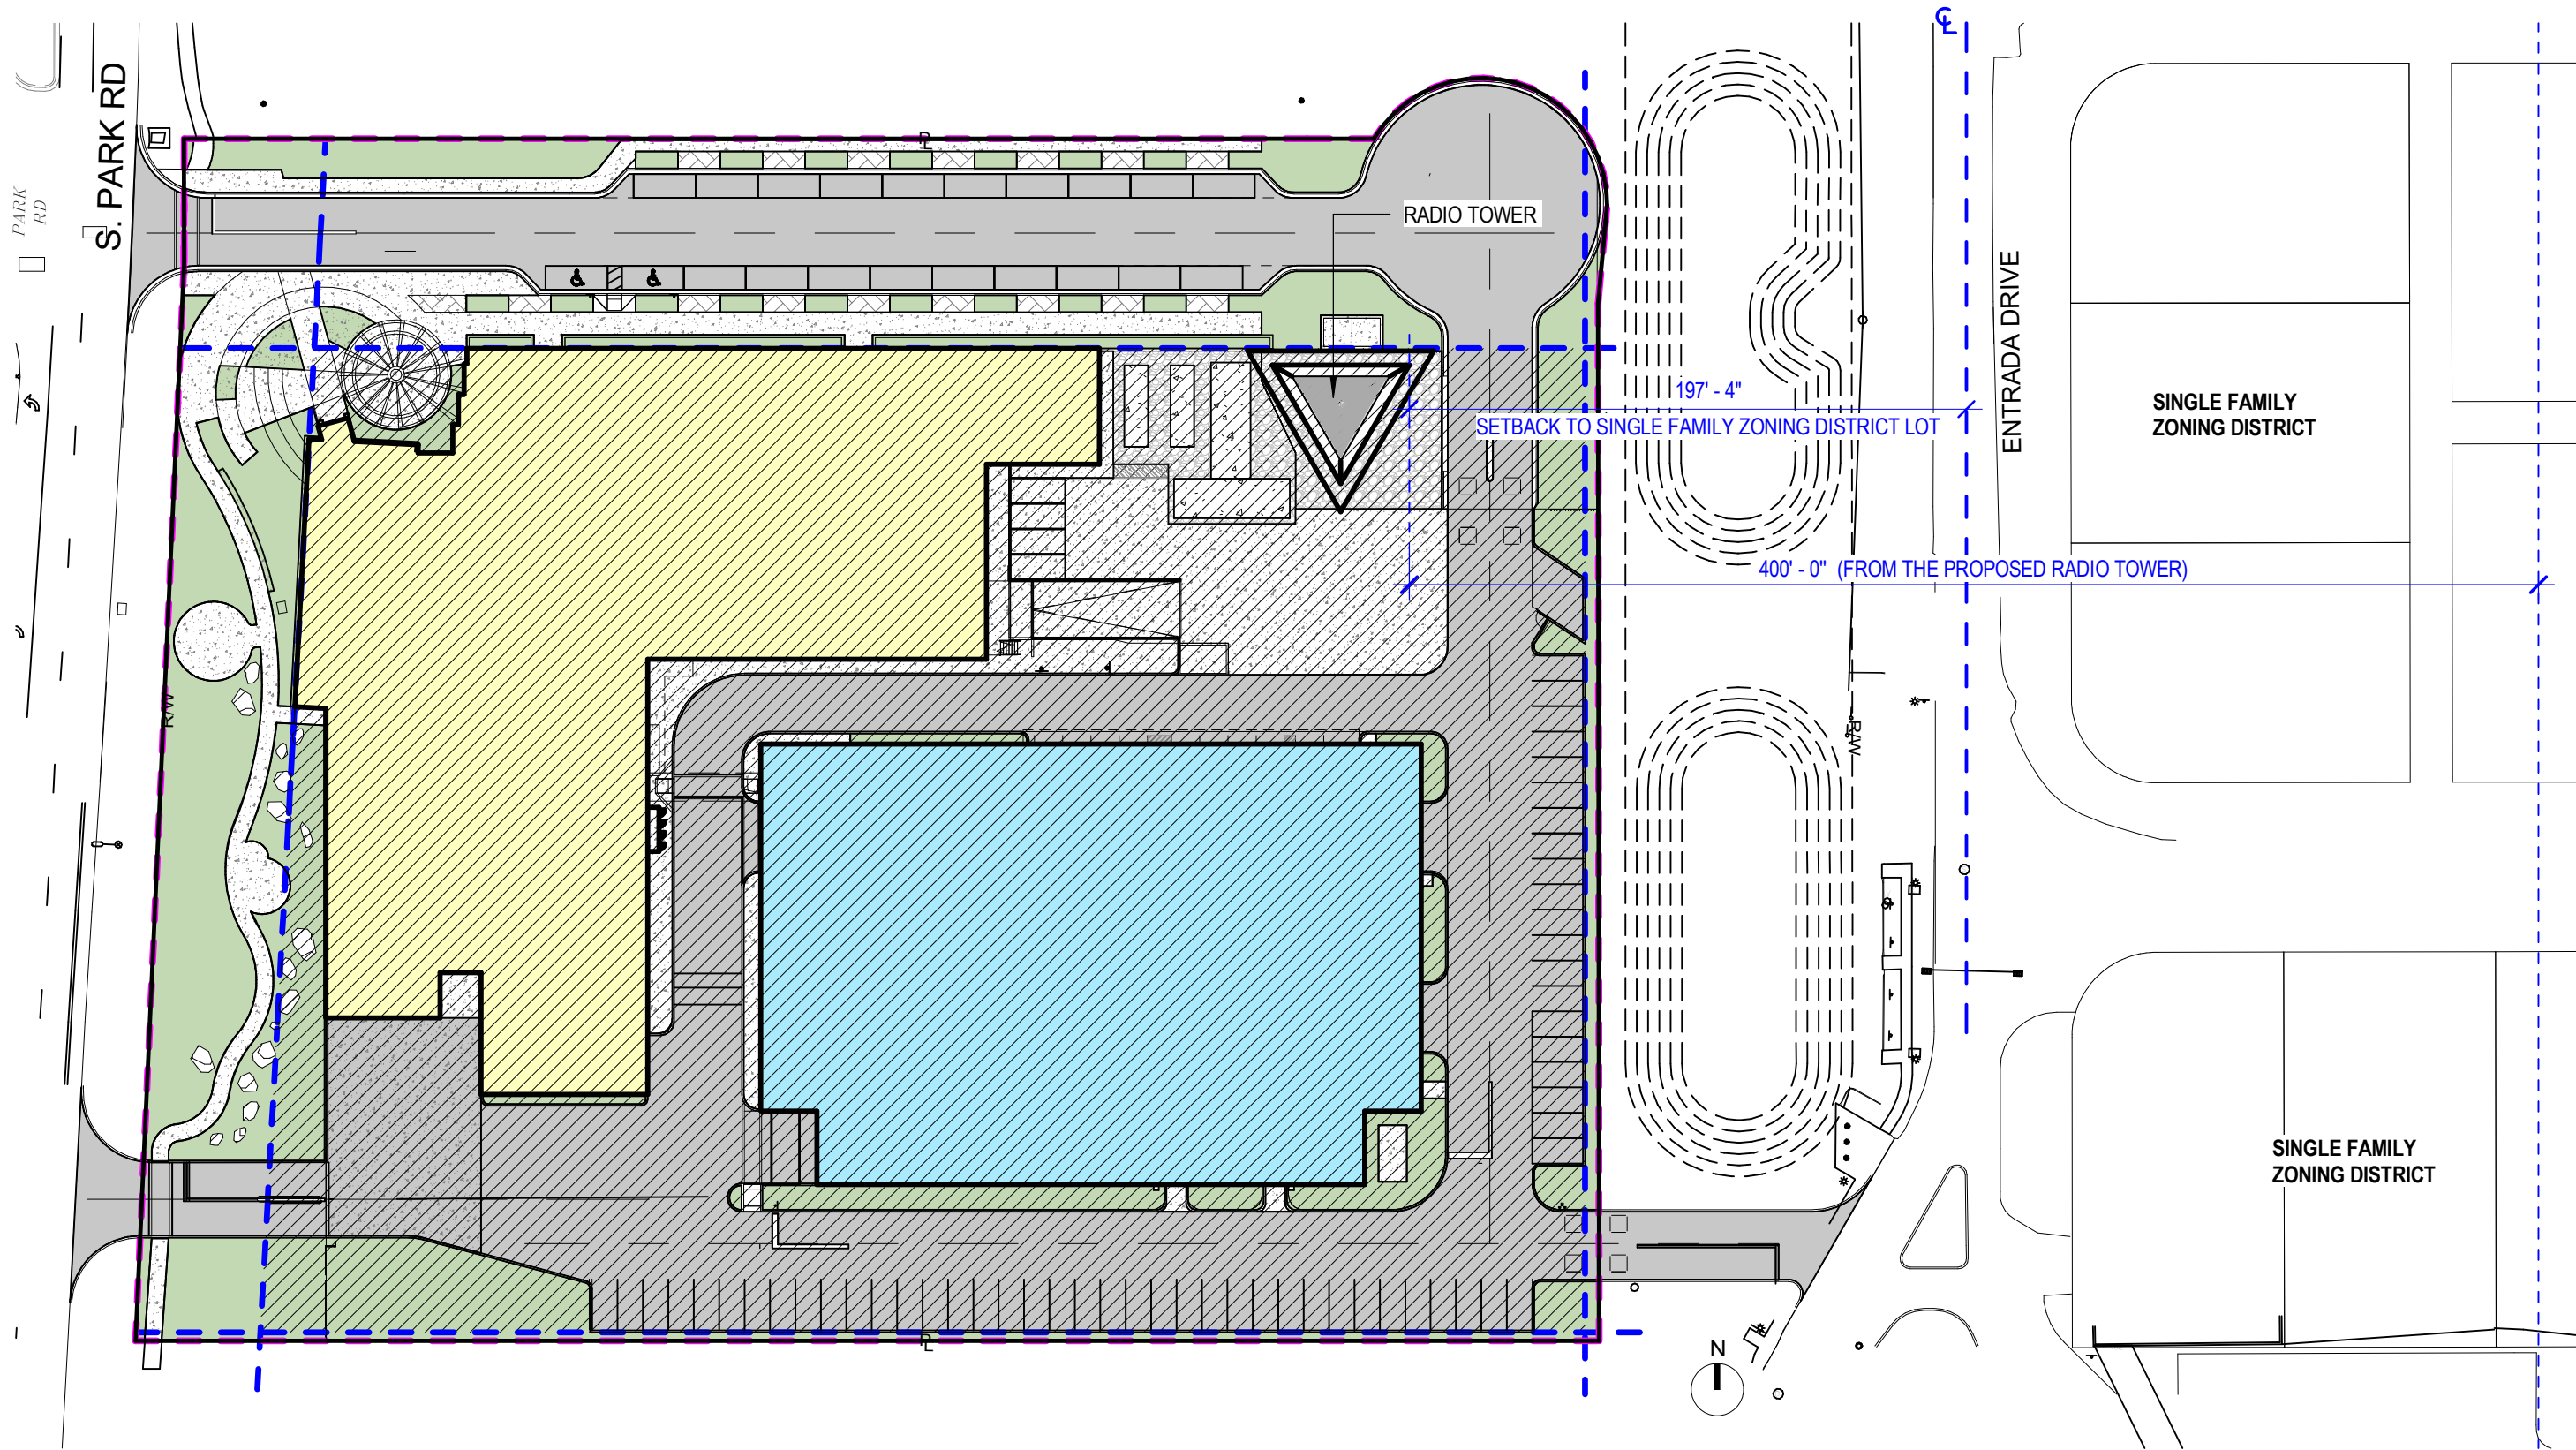

3 REQUIRED RADIO TOWER SETBACKS
1" = 60'-0"

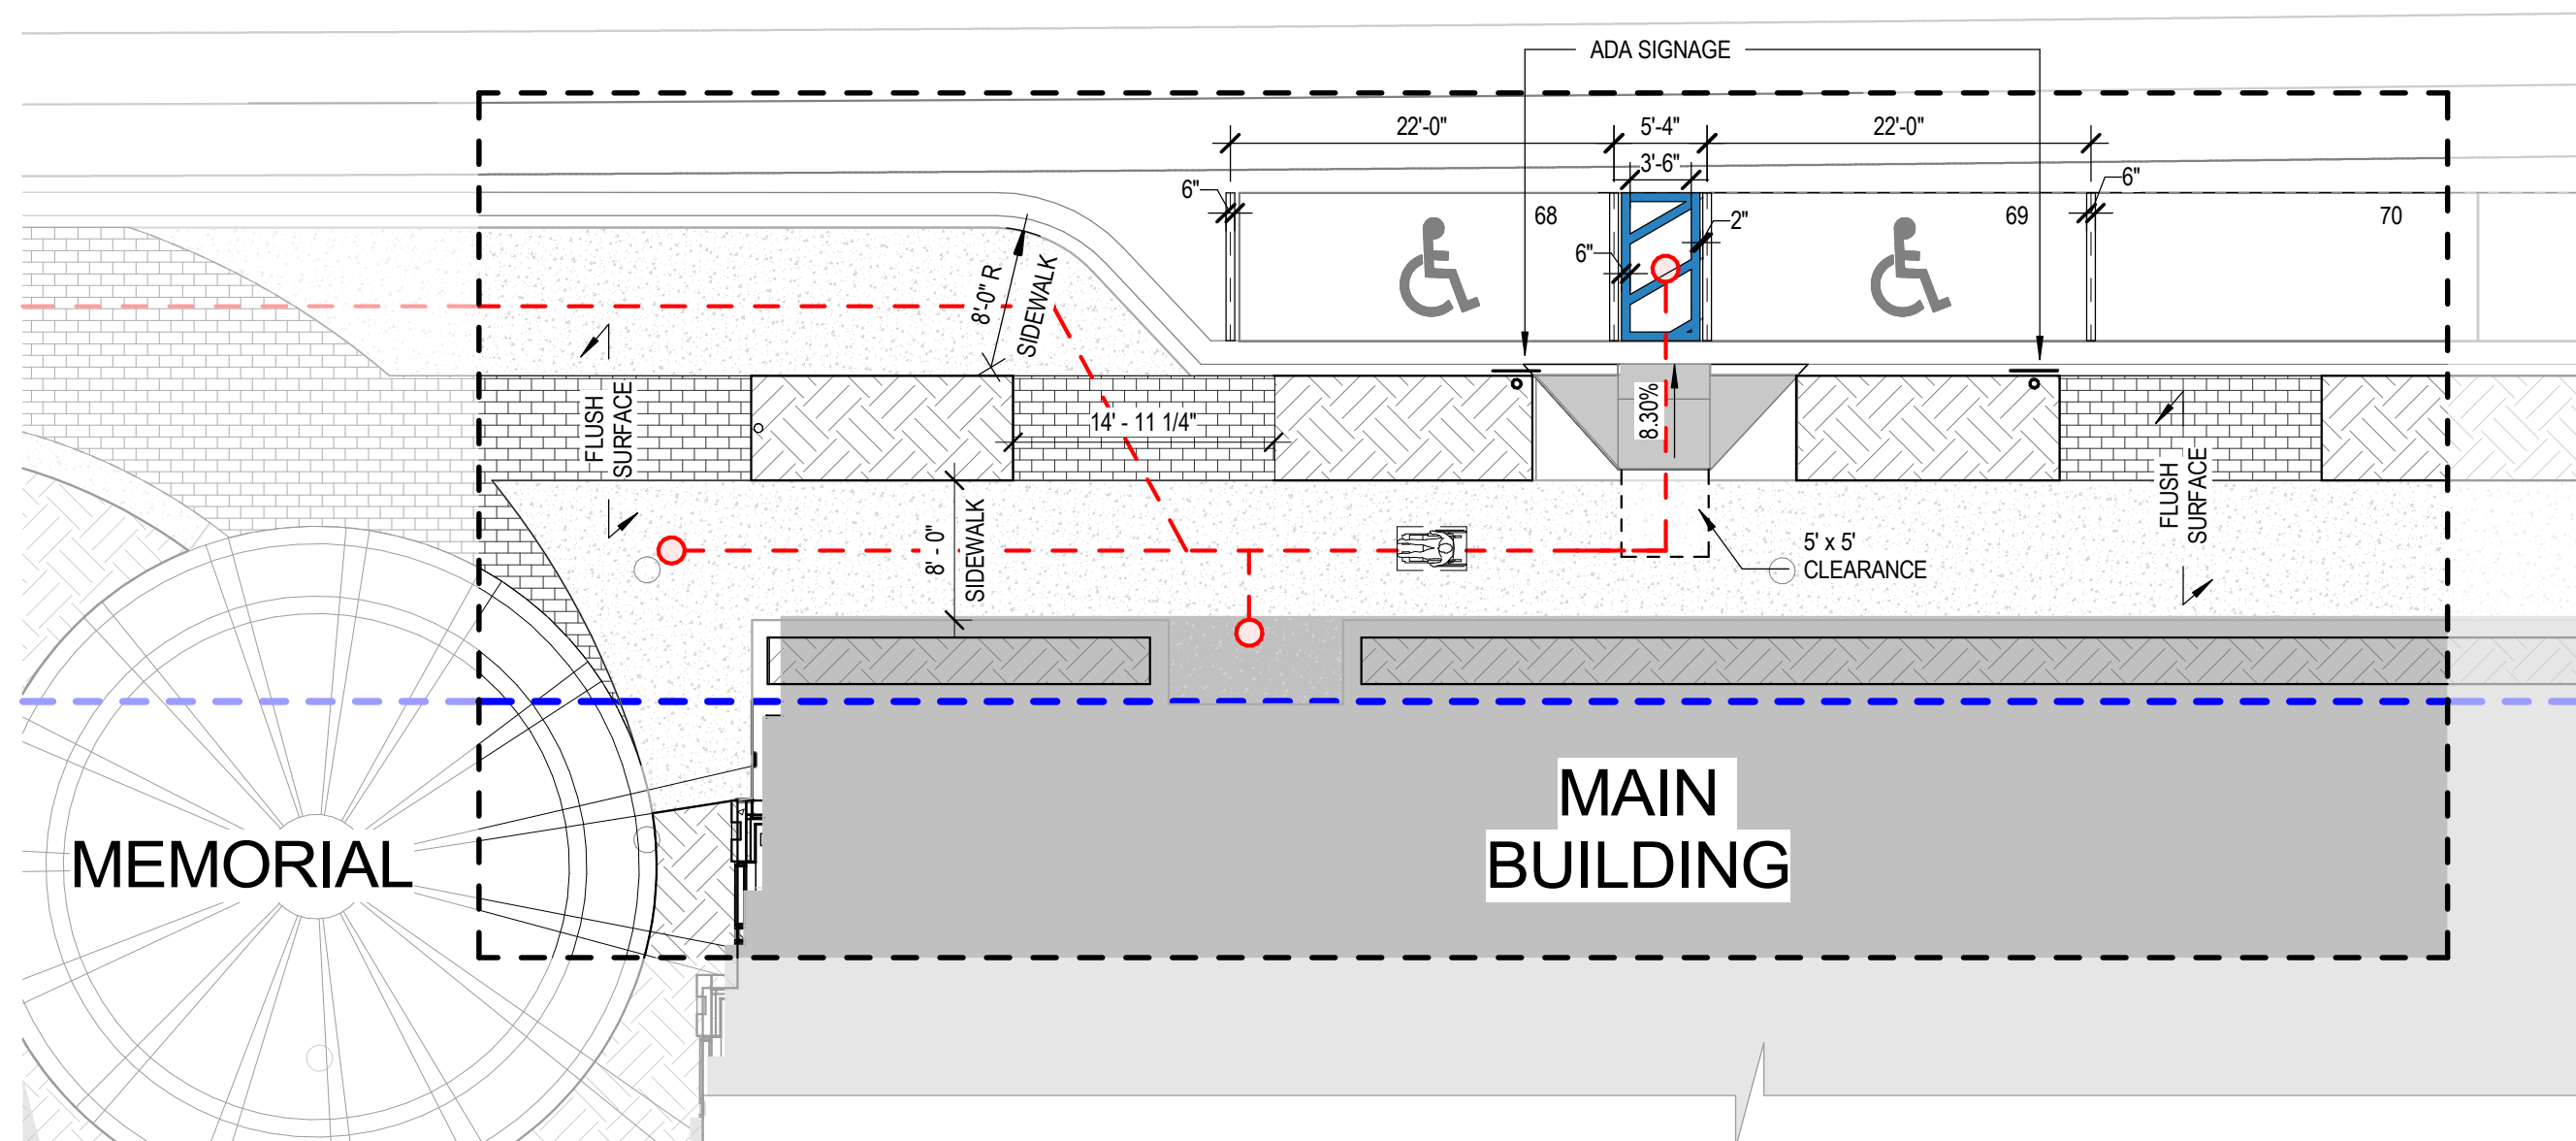

2 ACCESSIBILITY DIAGRAM - RAMPS - NORTH ON STREET PARKING
3/32" = 1'-0"

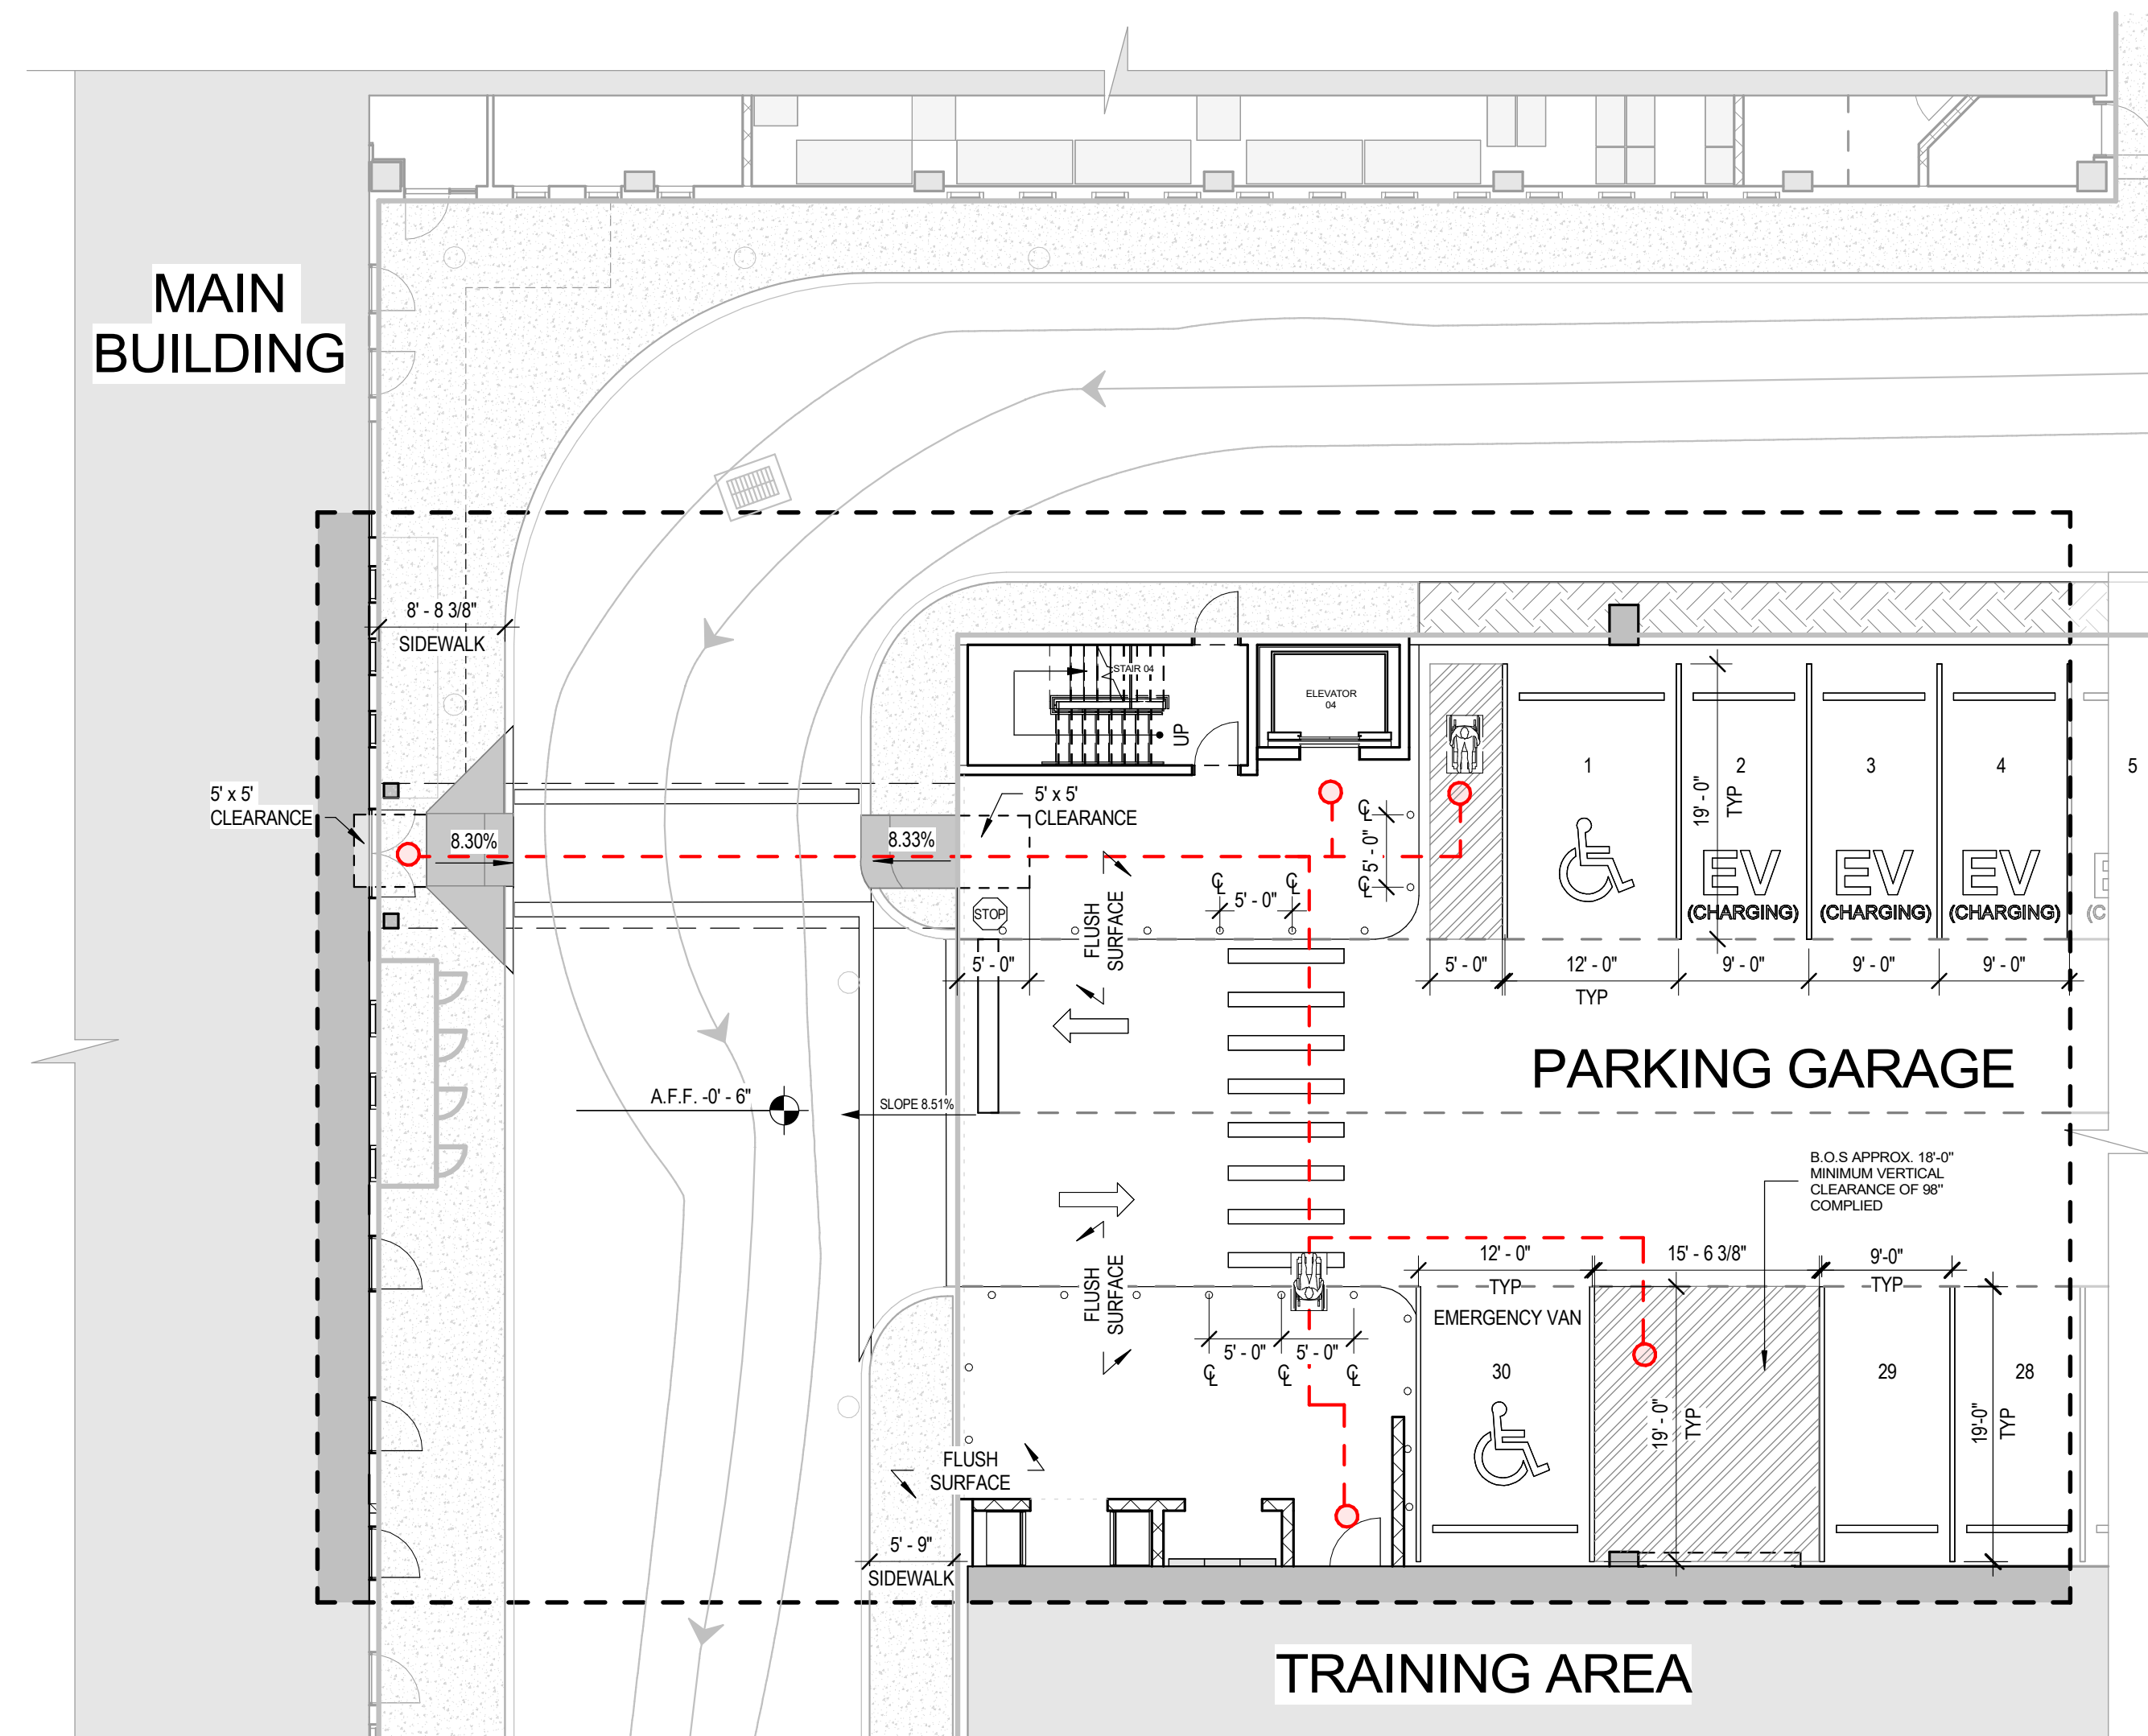

1 ACCESSIBILITY DIAGRAM - RAMPS - LEVEL 1 PARKING GARAGE
3/32" = 1'-0"

OWNER
CITY OF HOLLYWOOD
2207 RALEIGH ST
HOLLYWOOD, FL 33020
T: 954.521.3435

ARCHITECT OF RECORD
O'DONNELL, DANWOLF AND PARTNERS ARCHITECTS INC.
2432 HOLLYWOOD BLVD.
HOLLYWOOD, FL 33020
M: 954.518.0333
T: 954.518.0833

DESIGN & LANDSCAPE ARCHITECT
CANAL HOUSE, 3223 GRACE STREET NW
WASHINGTON, DC 20007 USA
T: 202.644.1413

STRUCTURAL ENGINEER
OSBORN ENGINEERING
15 W. CHURCH STREET - SUITE 201
ORLANDO, FLORIDA 32801-3352
T: 407.630.6253

MEP/FP ENGINEER
OD ASSOCIATES INC.
181 MELODY LANE, SUITE 107
FORT PIERCE, FL 34989
T: 772.466.1195

CIVIL ENGINEER
Kimley-Horn
8201 PETERS ROAD, SUITE 200
PLANTATION, FL 33324
T: 954.335.5100

ENVIRONMENTAL ENGINEER
LANGAN ENGINEERING AND ENVIRONMENTAL SERVICES, INC.
110 EAST BROWARD BOULEVARD, SUITE 1000
FORT LAUDERDALE, FL 33301
T: 954.320.2100

LIFE SAFETY CONSULTANT
SLS CONSULTING, INC.
260 PALERMO AVE
CORAL GABLES, FL 33134
T: 305.461.9822

RTCC CONSULTANT
WINBOURNE CONSULTING, LLC
1800 HARRISON ST., SUITE 204
HOLLYWOOD, FL 33020

FOR PERMITTING USE ONLY

EDWARD O'DONNELL
FL ARCHITECT REG. NO.:
AR93533

© 2020 O'DONNELL, DANWOLF AND PARTNERS ARCHITECTS INC.
THIS DRAWING, IN BOTH PRINTED AND ELECTRONIC FORM, MAY
NOT BE USED, COPIED, REPRODUCED, MODIFIED OR CHANGED IN ANY
MANNER WITHOUT THE WRITTEN CONSENT OF O'DONNELL,
DANWOLF AND PARTNERS ARCHITECTS INC. ANY USE,
DUPLICATION, MODIFICATION OR CHANGE WILL SUBJECT THE
USER AND ITS AGENTS TO LIABILITY OF SUCH ACTS


odp
ARCHITECTURE AND DESIGN
2432 HOLLYWOOD BLVD., HOLLYWOOD, FL 33020
T: 954.518.0833 | F: 954.518.0131
www.odparchitects.com


PROJECT
CITY OF HOLLYWOOD
NEW POLICE
HEADQUARTERS
ADDRESS: 401 S PARK RD HOLLYWOOD, FL 33021

NO.	DATE	ISSUANCE DESCRIPTION
1	01/03/2023	PRELIMINARY TAC
2	02/23/2023	FINAL TAC
3	03/23/2023	FINAL TAC SIGN-OFF
4	06/01/2023	FINAL TAC SIGN-OFF - Revision 1

SCALE: As Indicated
SHEET SIZE: ARCH-D (24"X36") DO NOT SCALE DRAWINGS.
DATE: 06/01/2023
STARTED BY: ODP
DRAWING TITLE:
**ACCESSIBILITY
DIAGRAMS**
SHEET NO.
A-056

© COPYRIGHT 2020, THESE DOCUMENTS ARE THE SOLE PROPERTY OF O'DONNELL DANWOLF AND PARTNERS ARCHITECTS INC. ANY ALTERATION OR UNAUTHORIZED USE OF ANY PART OF THESE DOCUMENTS IS NOT PERMITTED.

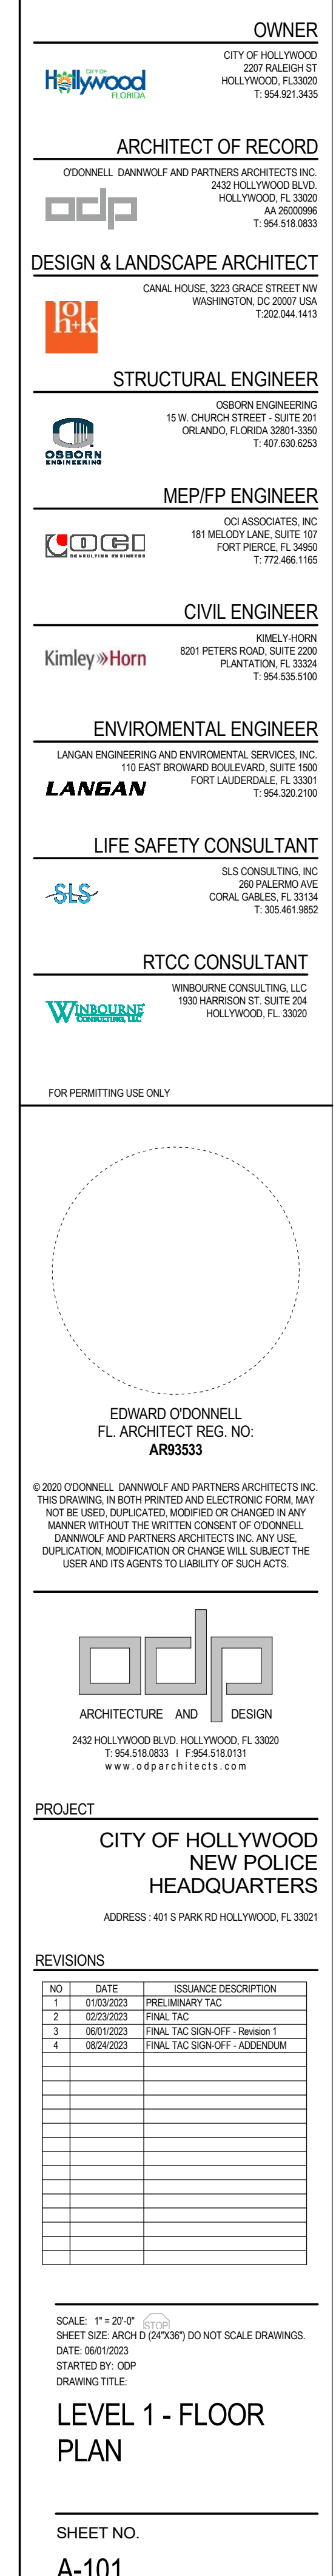

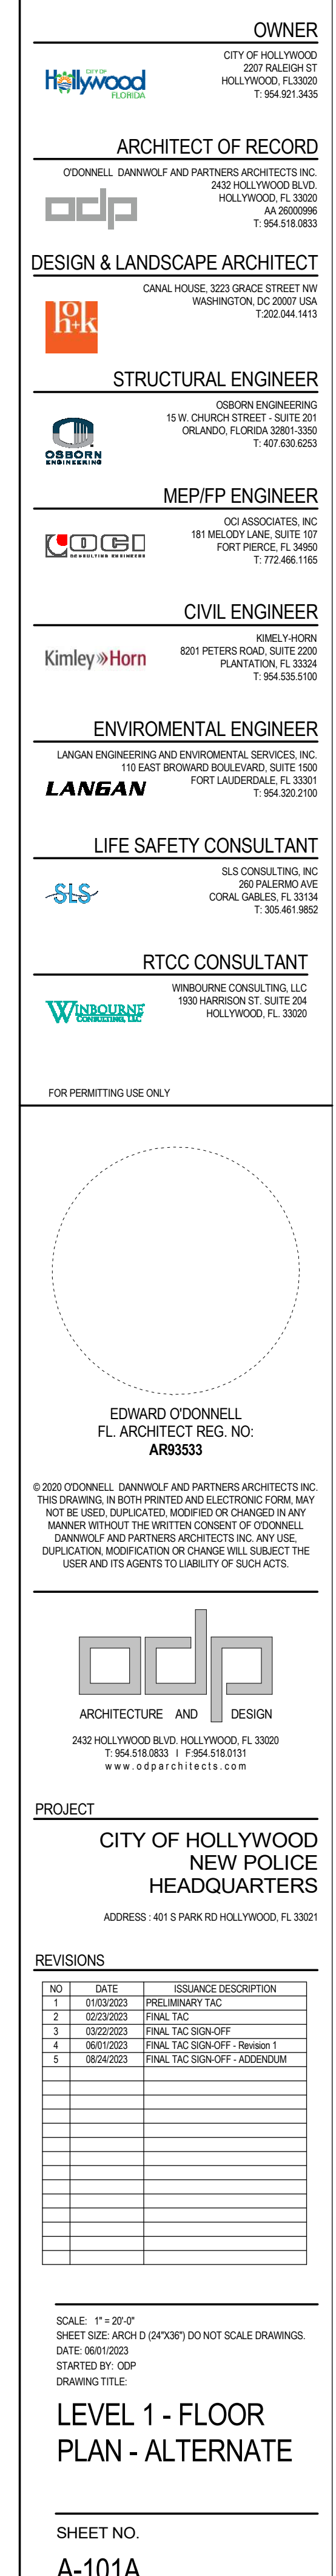

SCALE: 1" = 20'-0"
SHEET SIZE: ARCH D (24"x36") DO NOT SCALE DRAWINGS.
DATE: 06/01/2013
STARTED BY: CDP
DRAWING TITLE:

**LEVEL 1 - FLOOR
PLAN - ALTERNATE**

SHEET NO.
A-101A



© COPYRIGHT 2020, THESE DOCUMENTS ARE THE SOLE PROPERTY OF O'DONNELL DANWOLF AND PARTNERS, ARCHITECTS INC. ANY ALTERATION OF UNAUTHORIZED USE OF, WITHOUT THE WRITTEN CONSENT OF O'DONNELL DANWOLF AND PARTNERS, ARCHITECTS INC., IS NOT PERMITTED.




SCALE: 1" = 20'-0"
SHEET SIZE: ARCH D (24"x36") DO NOT SCALE DRAWINGS.
DATE: 03/22/23
STARTED BY: ODP
DRAWING TITLE:

**LEVEL 3 - FLOOR
PLAN**

SHEET NO.

A-103

© COPYRIGHT 2020. THESE DOCUMENTS ARE THE SOLE PROPERTY OF O'DONNELL DANWOLF AND PARTNERS, ARCHITECTS INC. ANY ALTERATION OF UNAUTHORIZED USE OF, WITHOUT THE WRITTEN CONSENT OF O'DONNELL DANWOLF AND PARTNERS, ARCHITECTS INC., IS NOT PERMITTED.

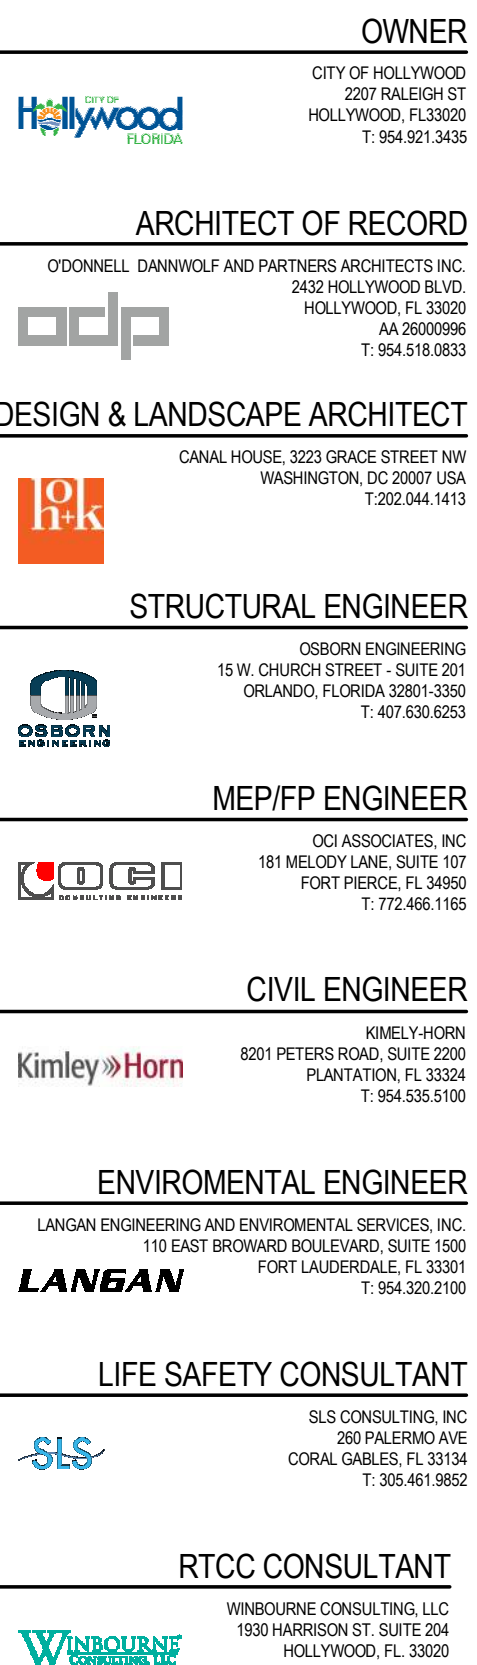

© 2020 O'DONNELL, DANNWOLF AND PARTNERS ARCHITECTS INC.
THIS DRAWING, IN BOTH PRINTED AND ELECTRONIC FORM, MAY
NOT BE USED, DUPLICATED, MODIFIED OR CHANGED IN ANY
MANNER WITHOUT THE WRITTEN CONSENT OF O'DONNELL,
DANNWOLF AND PARTNERS ARCHITECTS INC. ANY USE,
DUPLICATION, MODIFICATION OR CHANGE WILL SUBJECT THE
USER AND ITS AGENTS TO LIABILITY OF SUCH ACTS.

PROJECT

CITY OF HOLLYWOOD
NEW POLICE
HEADQUARTERS

ADDRESS : 401 S PARK RD HOLLYWOOD, FL 33021

[illegible]


LEVEL 4 - FLOOR
PLAN - DEDUCT
ALTERNATE

SHEET NO.
A-104

© COPYRIGHT 2020. THESE DOCUMENTS ARE THE SOLE PROPERTY OF O'DONNELL, DANAWOLF AND PARTNERS, ARCHITECTS INC. ANY ALTERATION OF UN-AUTHORIZED USE OF WITHOUT THE WRITTEN CONSENT OF O'DONNELL, DANAWOLF AND PARTNERS, ARCHITECTS INC. IS NOT PERMITTED.



A-105

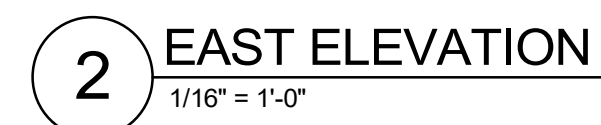

PT - 1	PCP - 1	PCP - 2	PCP - 3	MTL - 1	MTL - 2	MTL - 3	MT - 4	GL - 1	GL - 2	MTL-FL	MTL-RL
PAINTED STUCCO DARK GRAY	PRECAST CONC. BEIGE LIGHT SANDBLAST	PRECAST CONC. LIGHT GRAY	PRECAST CONC. DARK GRAY	LIGHT GRAY METAL SCREEN	DARK GRAY METAL SCREEN	LIGHT GRAY ALUMINUM CLADDING	METAL FENCE	GLAZING	GLAZING	METAL RETURN ACRYLIC FACE LIT	METAL FACE REVERSE LIT

EDWARD O'DONNELL
FL. ARCHITECT REG. NO.
AR93533

odp
ARCHITECTURE AND DESIGN

2432 HOLLYWOOD BLVD. HOLLYWOOD, FL 33020
T: 954.518.0833 | F: 954.518.0131
www.odparchitects.com

[illegible]

SCALE: As indicated
SHEET SIZE: ARCH D (24"x36") DO NOT SCALE DRAWINGS.
DATE: 03/22/23
STARTED BY: CDP
DRAWING TITLE:

**BUILDING
ELEVATIONS**

SHEET NO.

A-200



PT - 1	PCP - 1	PCP - 2	PCP - 3	MTL - 1	MTL - 2	MTL - 3	MT - 4	GL - 1	GL - 2	MTL-FL	MTL-RL
PAINTED STUCCO DARK GRAY	PRECAST CONC. RE/FG LIGHT SANDBLAST	PRECAST CONC. LIGHT GRAY	PRECAST CONC. DARK GRAY	LIGHT GRAY METAL SCREEN	DARK GRAY METAL SCREEN	LIGHT GRAY ALUMINUM CLADDING	METAL FENCE	GLAZING	GLAZING	METAL RETURN ACRYLIC FACE LIT	METAL FACE REVERSE LIT

OWNER

CITY OF HOLLYWOOD
2207 FALEIGH ST
HOUSTON, TX 77058
T: 954.921.3435

ARCHITECT OF RECORD

O'DONNELL DANNIWOFF & PARTNERS ARCHITECTS, INC.
2432 HOLLYWOOD BLVD.
HOOLLYWOOD, FL 33020
A# 29000295
T: 954.918.0833

DESIGN & LANDSCAPE ARCHITECT

CANAL HOUSE, 3223 GRACE STREET NW
WASHINGTON, DC 20007-1504
T: 202.264.1413

STRUCTURAL ENGINEER

OSBORN ENGINEERING
1519 CHURCH STREET - SUITE 201
ORLANDO, FLORIDA 32801-3300
T: 407.638.6253

MEP/FP ENGINEER

OCI ASSOCIATES, INC.
181 MELROY LANE, SUITE 107
FORT PIERCE, FL 34950
T: 772.466.1165

CIVIL ENGINEER

KIMLEY-HORN
8201 PETERS ROAD, SUITE 2200
PLANTATION, FL 33324
T: 954.525.5100

ENVIRONMENTAL ENGINEER

LANGAN ENGINEERING AND ENVIRONMENTAL SERVICES, INC.
110 EAST BROADWAY BOULEVARD, SUITE 1500
FORT LAUDERDALE, FL 33301
T: 954.320.2100

LIFE SAFETY CONSULTANT

SLS CONSULTING, INC.
20 PALMER AVE
CORAL GABLES, FL 33134
T: 305.461.9852

RTCC CONSULTANT

WINBOURNE CONSULTING, LLC
1000 HARRISON ST., SUITE 204
HOLLYWOOD, FL 33020



EDWARD O'DONNELL
FL. ARCHITECT REG. NO.
AR93533

© 2020 O'DONNELL, DANWOLF AND PARTNERS ARCHITECTS INC.
THIS DRAWING, IN BOTH PRINTED AND ELECTRONIC FORM, MAY
NOT BE USED, DUPLICATED, MODIFIED OR CHANGED IN ANY
MANNER WITHOUT THE WRITTEN CONSENT OF O'DONNELL,
DANWOLF AND PARTNERS ARCHITECTS INC. ANY USE,
DUPLICATION, MODIFICATION OR CHANGE WILL SUBJECT THE
USER AND ITS AGENTS TO LIABILITY OF SUCH ACTS.

odp
ARCHITECTURE AND DESIGN

2432 HOLLYWOOD BLVD. HOLLYWOOD, FL 33020
T: 954.518.0833 | F: 954.518.0131
www.odparchitects.com

PROJECT

CITY OF HOLLYWOOD
NEW POLICE
HEADQUARTERS

ADDRESS : 401 S PARK RD HOLLYWOOD, FL 33021

[illegible]

SCALE: As indicated
SHEET SIZE: ARCH D (24"x36") DO NOT SCALE DRAWINGS.
DATE: 03/22/23
DRAWING BY: OOP
DRAWING TITLE:

**ENLARGED WASTE
MANAGEMENT
ENCLOSURE**

SHEET NO.
A-401

MATERIAL FINISH LEGEND

PT - 1

PAINTED STUCCO LIGHT GRAY

PCP - 1


PRECAST CONC. BEIGE LIGHT SANDBLAST

PCP - 2


PRECAST CONC. LIGHT GRAY

PCP - 3


PRECAST CONC. DARK GRAY

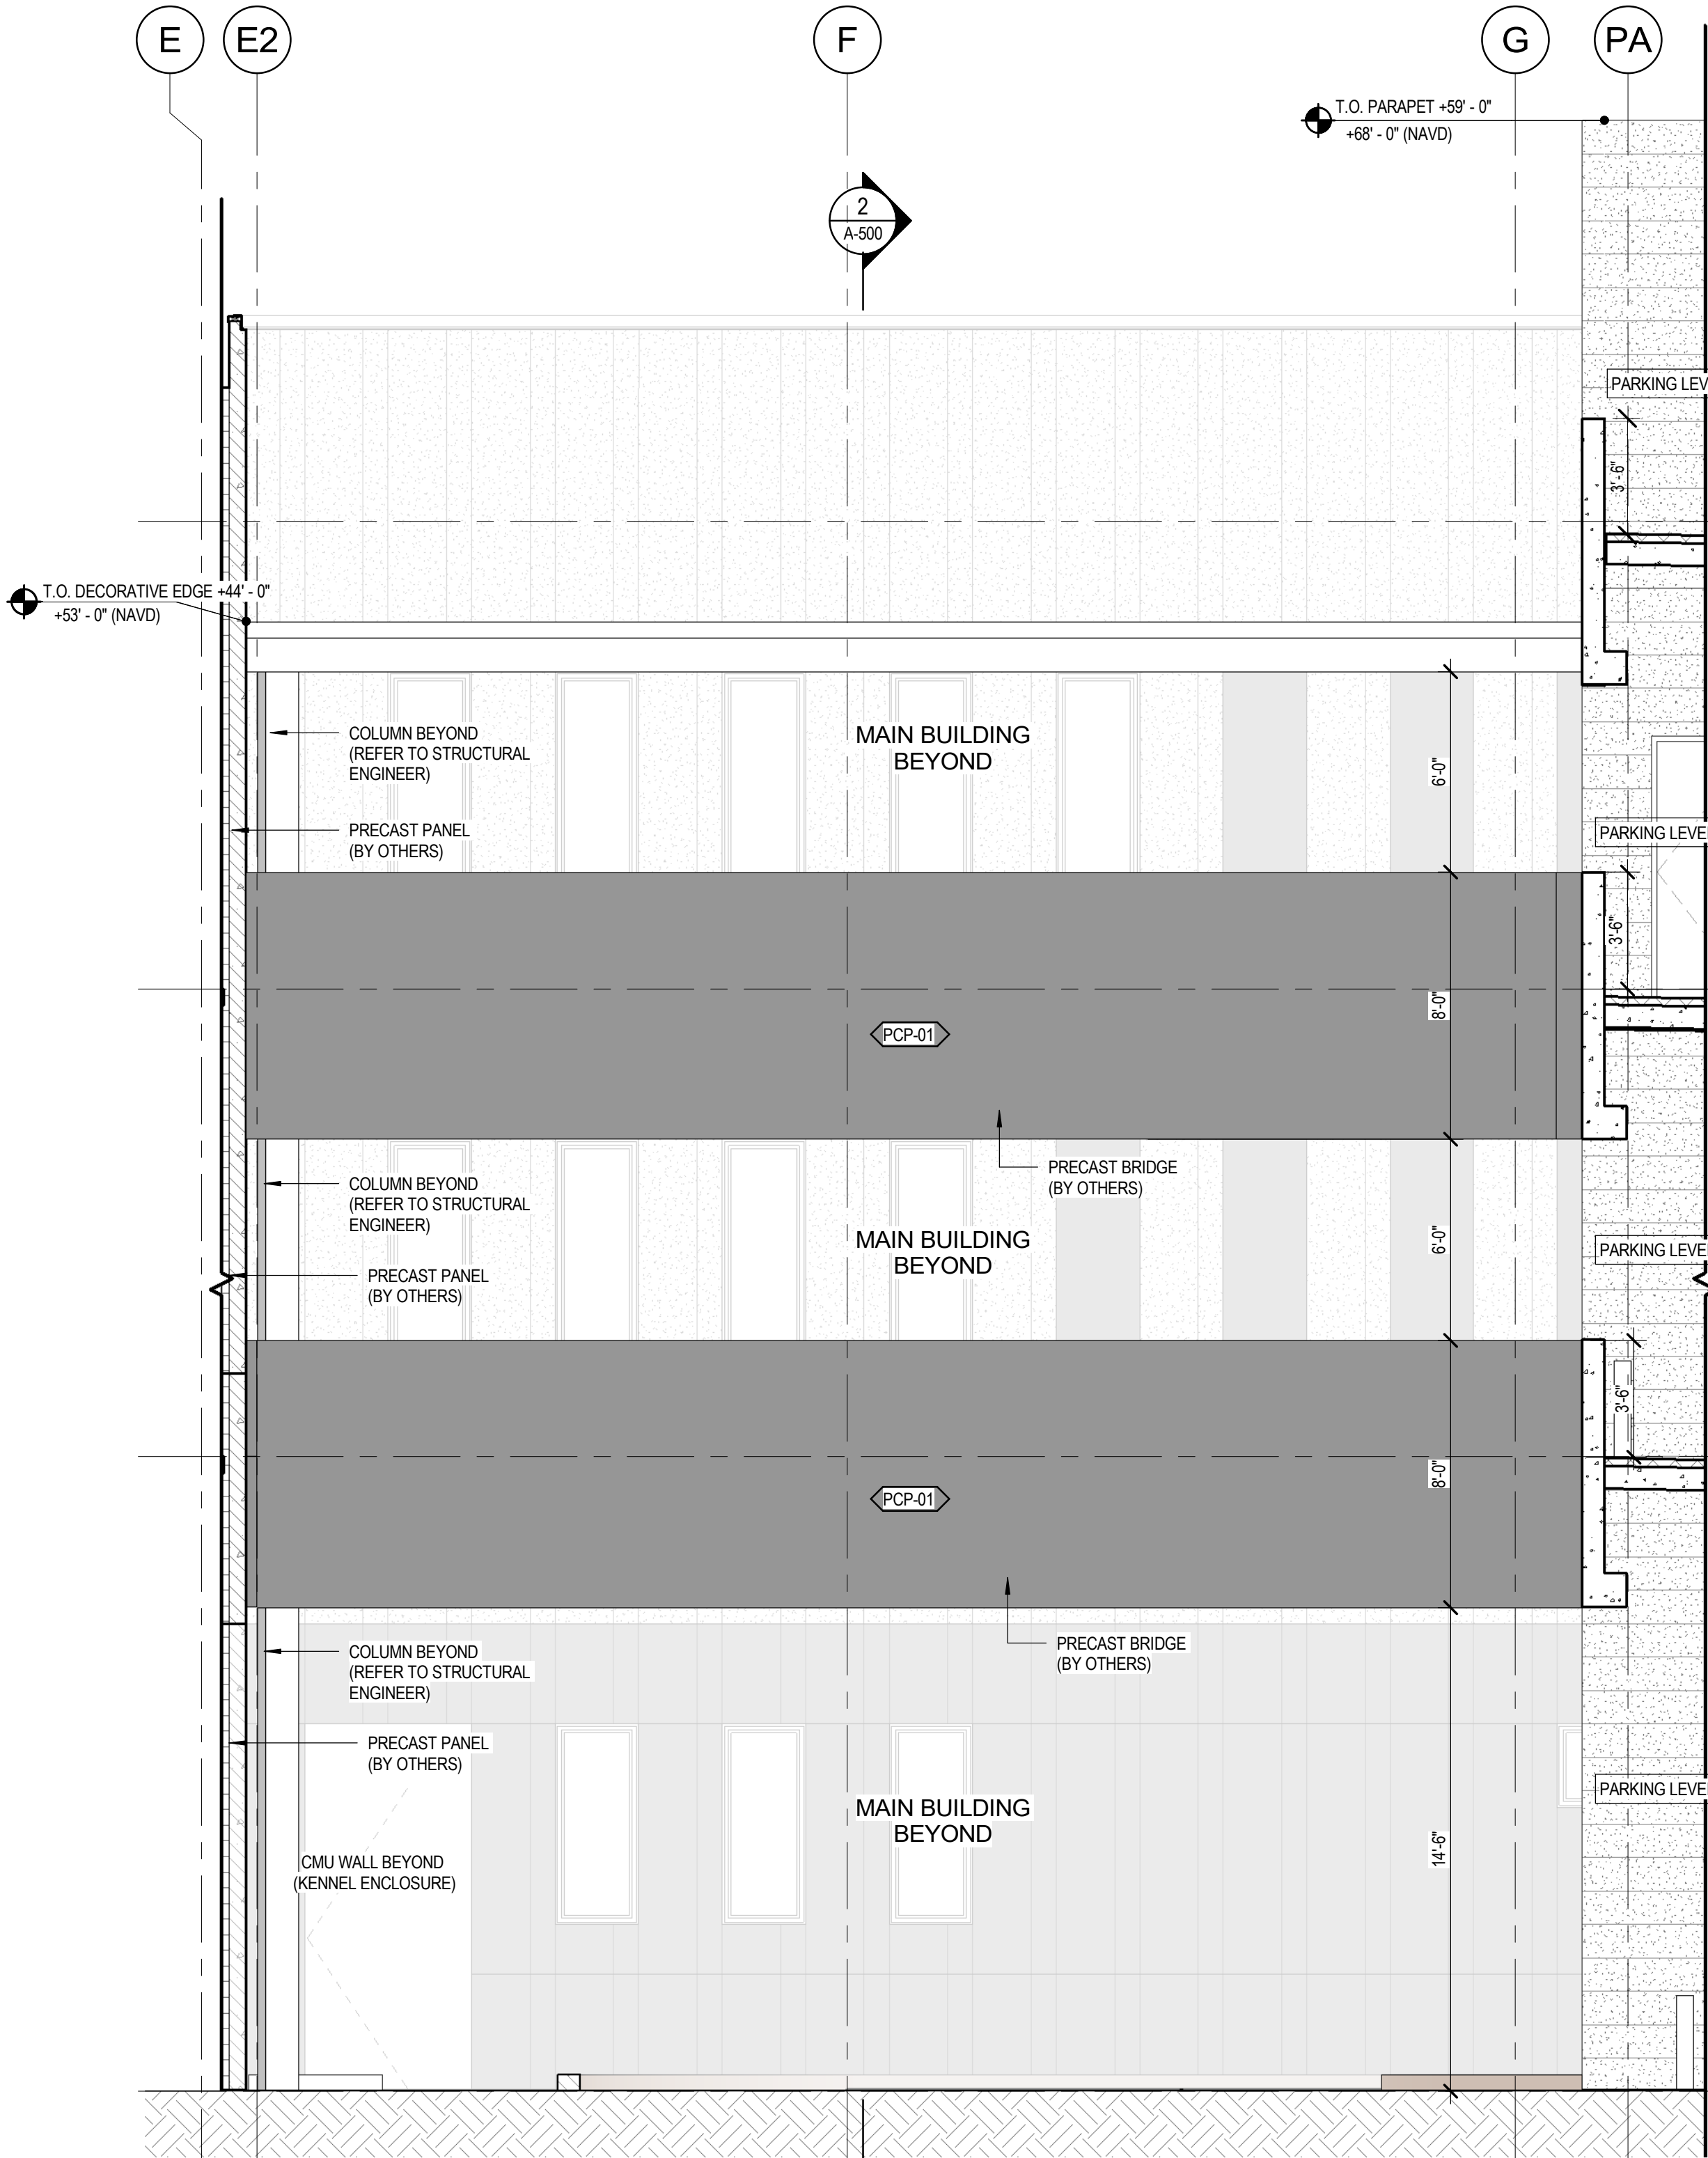

3 BRIDGE ELEVATION
1/4" = 1'-0"

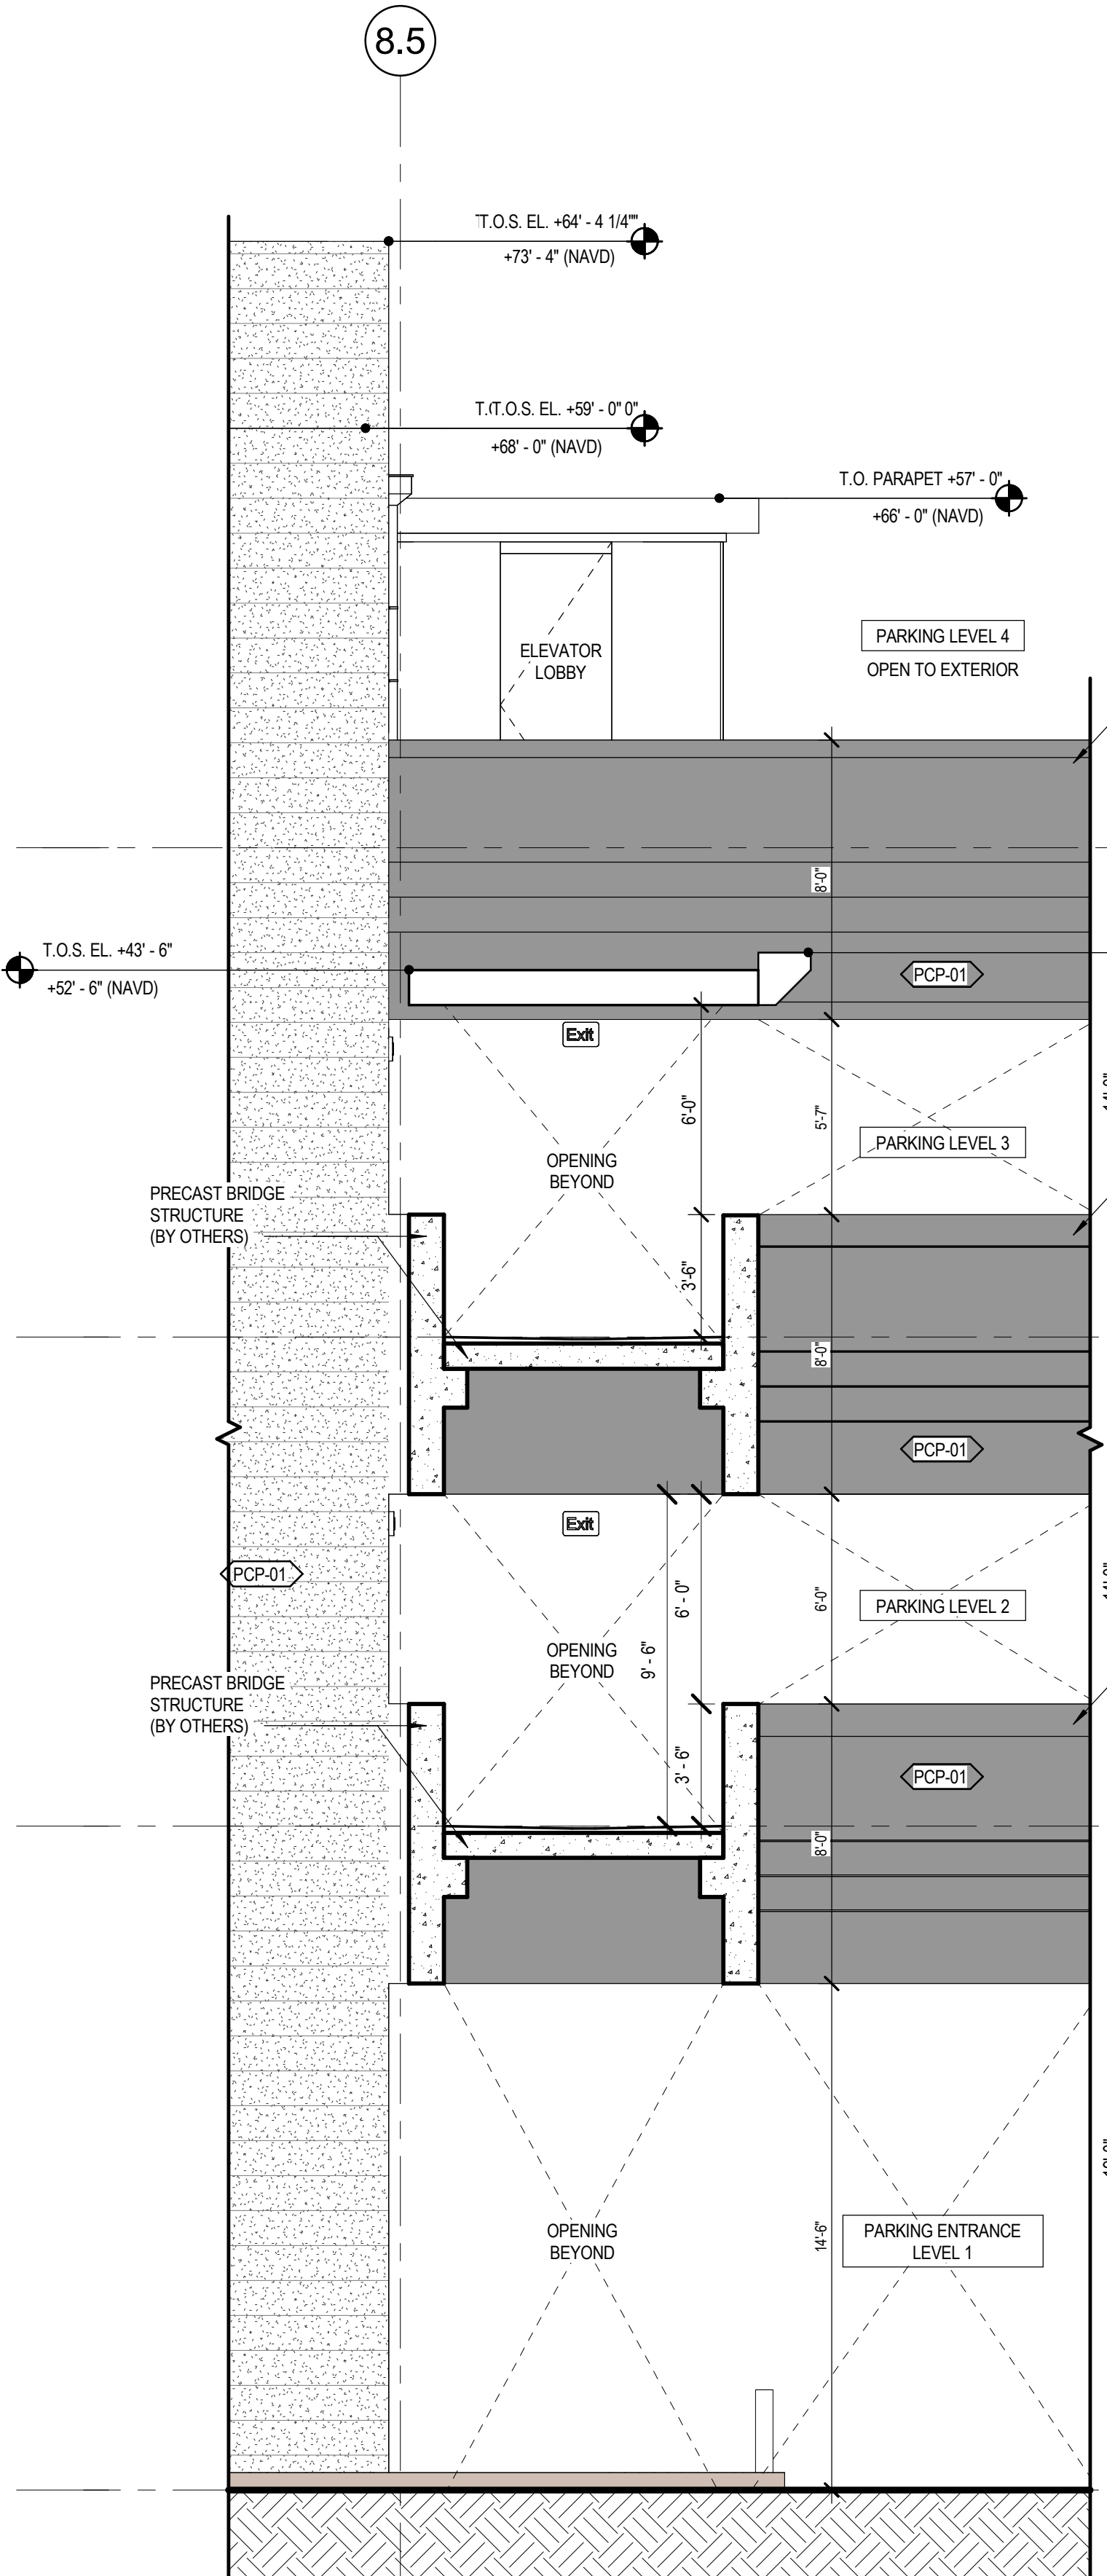

2 PRECAST BRIDGE DETAIL
1/4" = 1'-0"

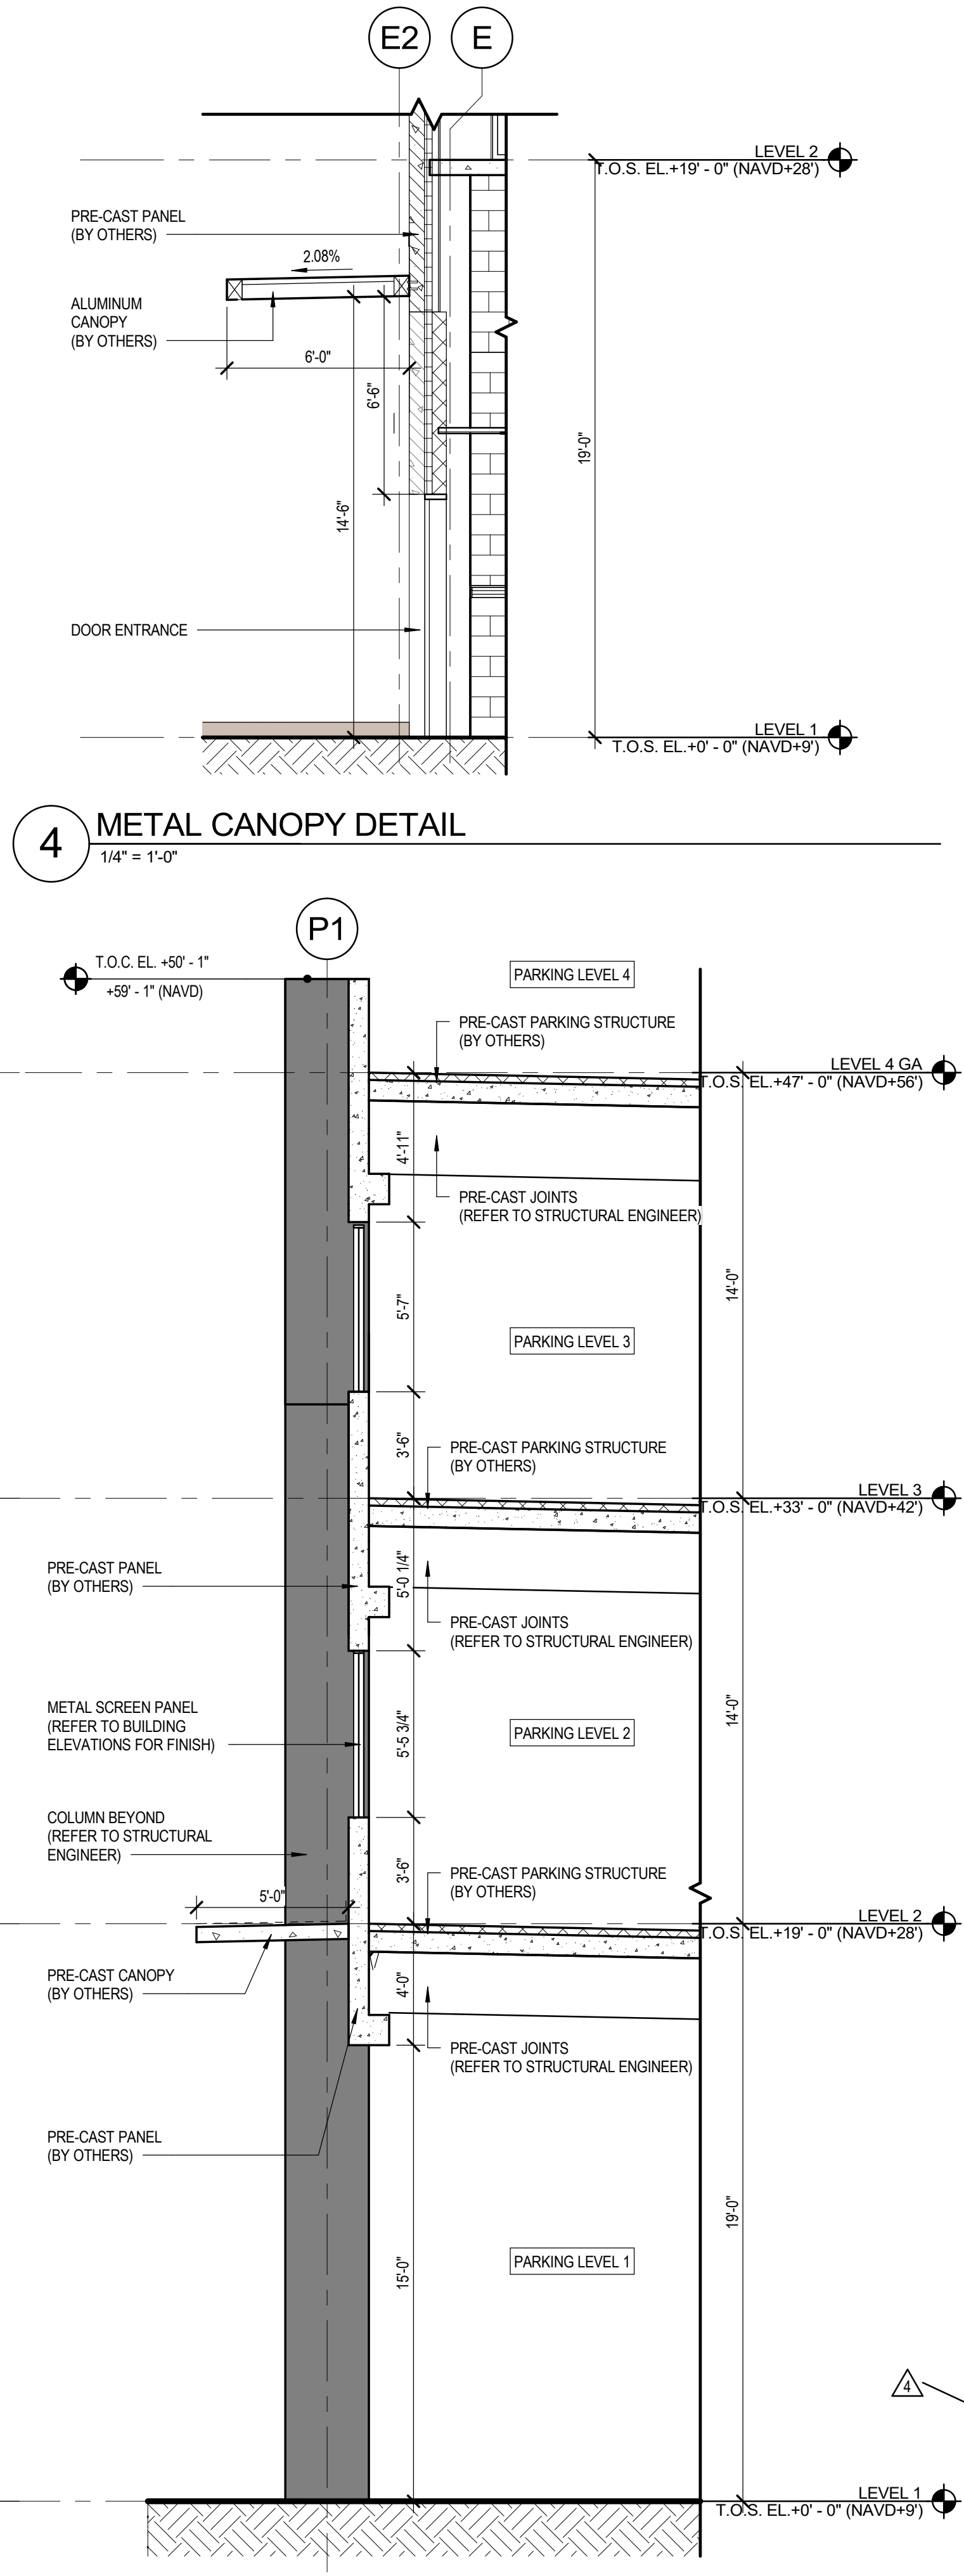

1 PRECAST CANOPY DETAIL
1/4" = 1'-0"

CITY OF HOLLYWOOD
2207 RALEIGH ST
HOLLYWOOD, FL 33020
T: 954.521.3435

ARCHITECT OF RECORD
O'DONNELL, DANNWOLF AND PARTNERS ARCHITECTS INC.
2432 HOLLYWOOD BLVD.
HOLLYWOOD, FL 33020
407.900.0066
T: 954.518.0833

DESIGN & LANDSCAPE ARCHITECT
CANAL HOUSE, 3223 GRACE STREET NW
WASHINGTON, DC 20007 USA
T: 202.644.1413

STRUCTURAL ENGINEER
OSBORN ENGINEERING
15 W. CHURCH STREET - SUITE 201
ORLANDO, FL 32801-3350
T: 407.630.6253

MEP/FP ENGINEER
OD ASSOCIATES INC
181 MELODY LANE, SUITE 107
FORT PIERCE, FL 34989
T: 772.466.1165

CIVIL ENGINEER
KIMLEY-HORN
8201 PETERS ROAD, SUITE 200
PLANTATION, FL 33324
T: 954.535.5100

ENVIRONMENTAL ENGINEER
LANGAN ENGINEERING AND ENVIRONMENTAL SERVICES, INC.
110 EAST BROADWAY BOULEVARD, SUITE 1300
FORT LAUDERDALE, FL 33301
T: 954.320.2100

LIFE SAFETY CONSULTANT
SLS CONSULTING, INC.
260 PALERMO AVE
CORAL GABLES, FL 33134
T: 305.461.9822

RTCC CONSULTANT
WINBOURNE CONSULTING, LLC
1300 HARRISON ST., SUITE 204
HOLLYWOOD, FL 33020

FOR PERMITTING USE ONLY

EDWARD O'DONNELL
FL ARCHITECT REG. NO.: AR93533

© 2020 O'DONNELL, DANNWOLF AND PARTNERS ARCHITECTS INC. THIS DRAWING, IN BOTH PRINTED AND ELECTRONIC FORM, MAY NOT BE USED, DUPLICATED, MODIFIED OR CHANGED IN ANY MANNER WITHOUT THE WRITTEN CONSENT OF O'DONNELL, DANNWOLF AND PARTNERS ARCHITECTS INC. ANY USE, DUPLICATION, MODIFICATION OR CHANGE WILL SUBJECT THE USER AND ITS AGENTS TO LIABILITY OF SUCH ACTS.

ARCHITECTURE AND DESIGN

2432 HOLLYWOOD BLVD., HOLLYWOOD, FL 33020
T: 954.518.0833 | F: 954.518.0131
www.odparchitects.com

PROJECT
CITY OF HOLLYWOOD
NEW POLICE HEADQUARTERS
ADDRESS: 401 S PARK RD HOLLYWOOD, FL 33021

REVISIONS

NO	DATE	ISSUANCE DESCRIPTION
1	01/03/2023	PRELIMINARY TAC
2	02/23/2023	FINAL TAC
3	03/22/2023	FINAL TAC SIGN-OFF
4	08/24/2023	FINAL TAC SIGN-OFF - ADDENDUM

SCALE: As Indicated
SHEET SIZE: ARCH-D (A4) (DO NOT SCALE DRAWINGS)
DATE: 03/22/23
STARTED BY: ODP
DRAWING TITLE:
CANOPY / BRIDGE SECTIONS
SHEET NO.
A-500

© COPYRIGHT 2023 BY THE ARCHITECTS. ALL RIGHTS RESERVED. O'DONNELL, DANNWOLF AND PARTNERS ARCHITECTS INC. IS NOT PERMITTED.

