



This document, together with the concepts and designs presented herein, as an instrument of service, is intended only for the specific purpose and client for which it was prepared. Reuse of and improper reliance on this document without written authorization and adaptation by Kinney-Horn and Associates, Inc. shall be without liability to Kinney-Horn and Associates, Inc.

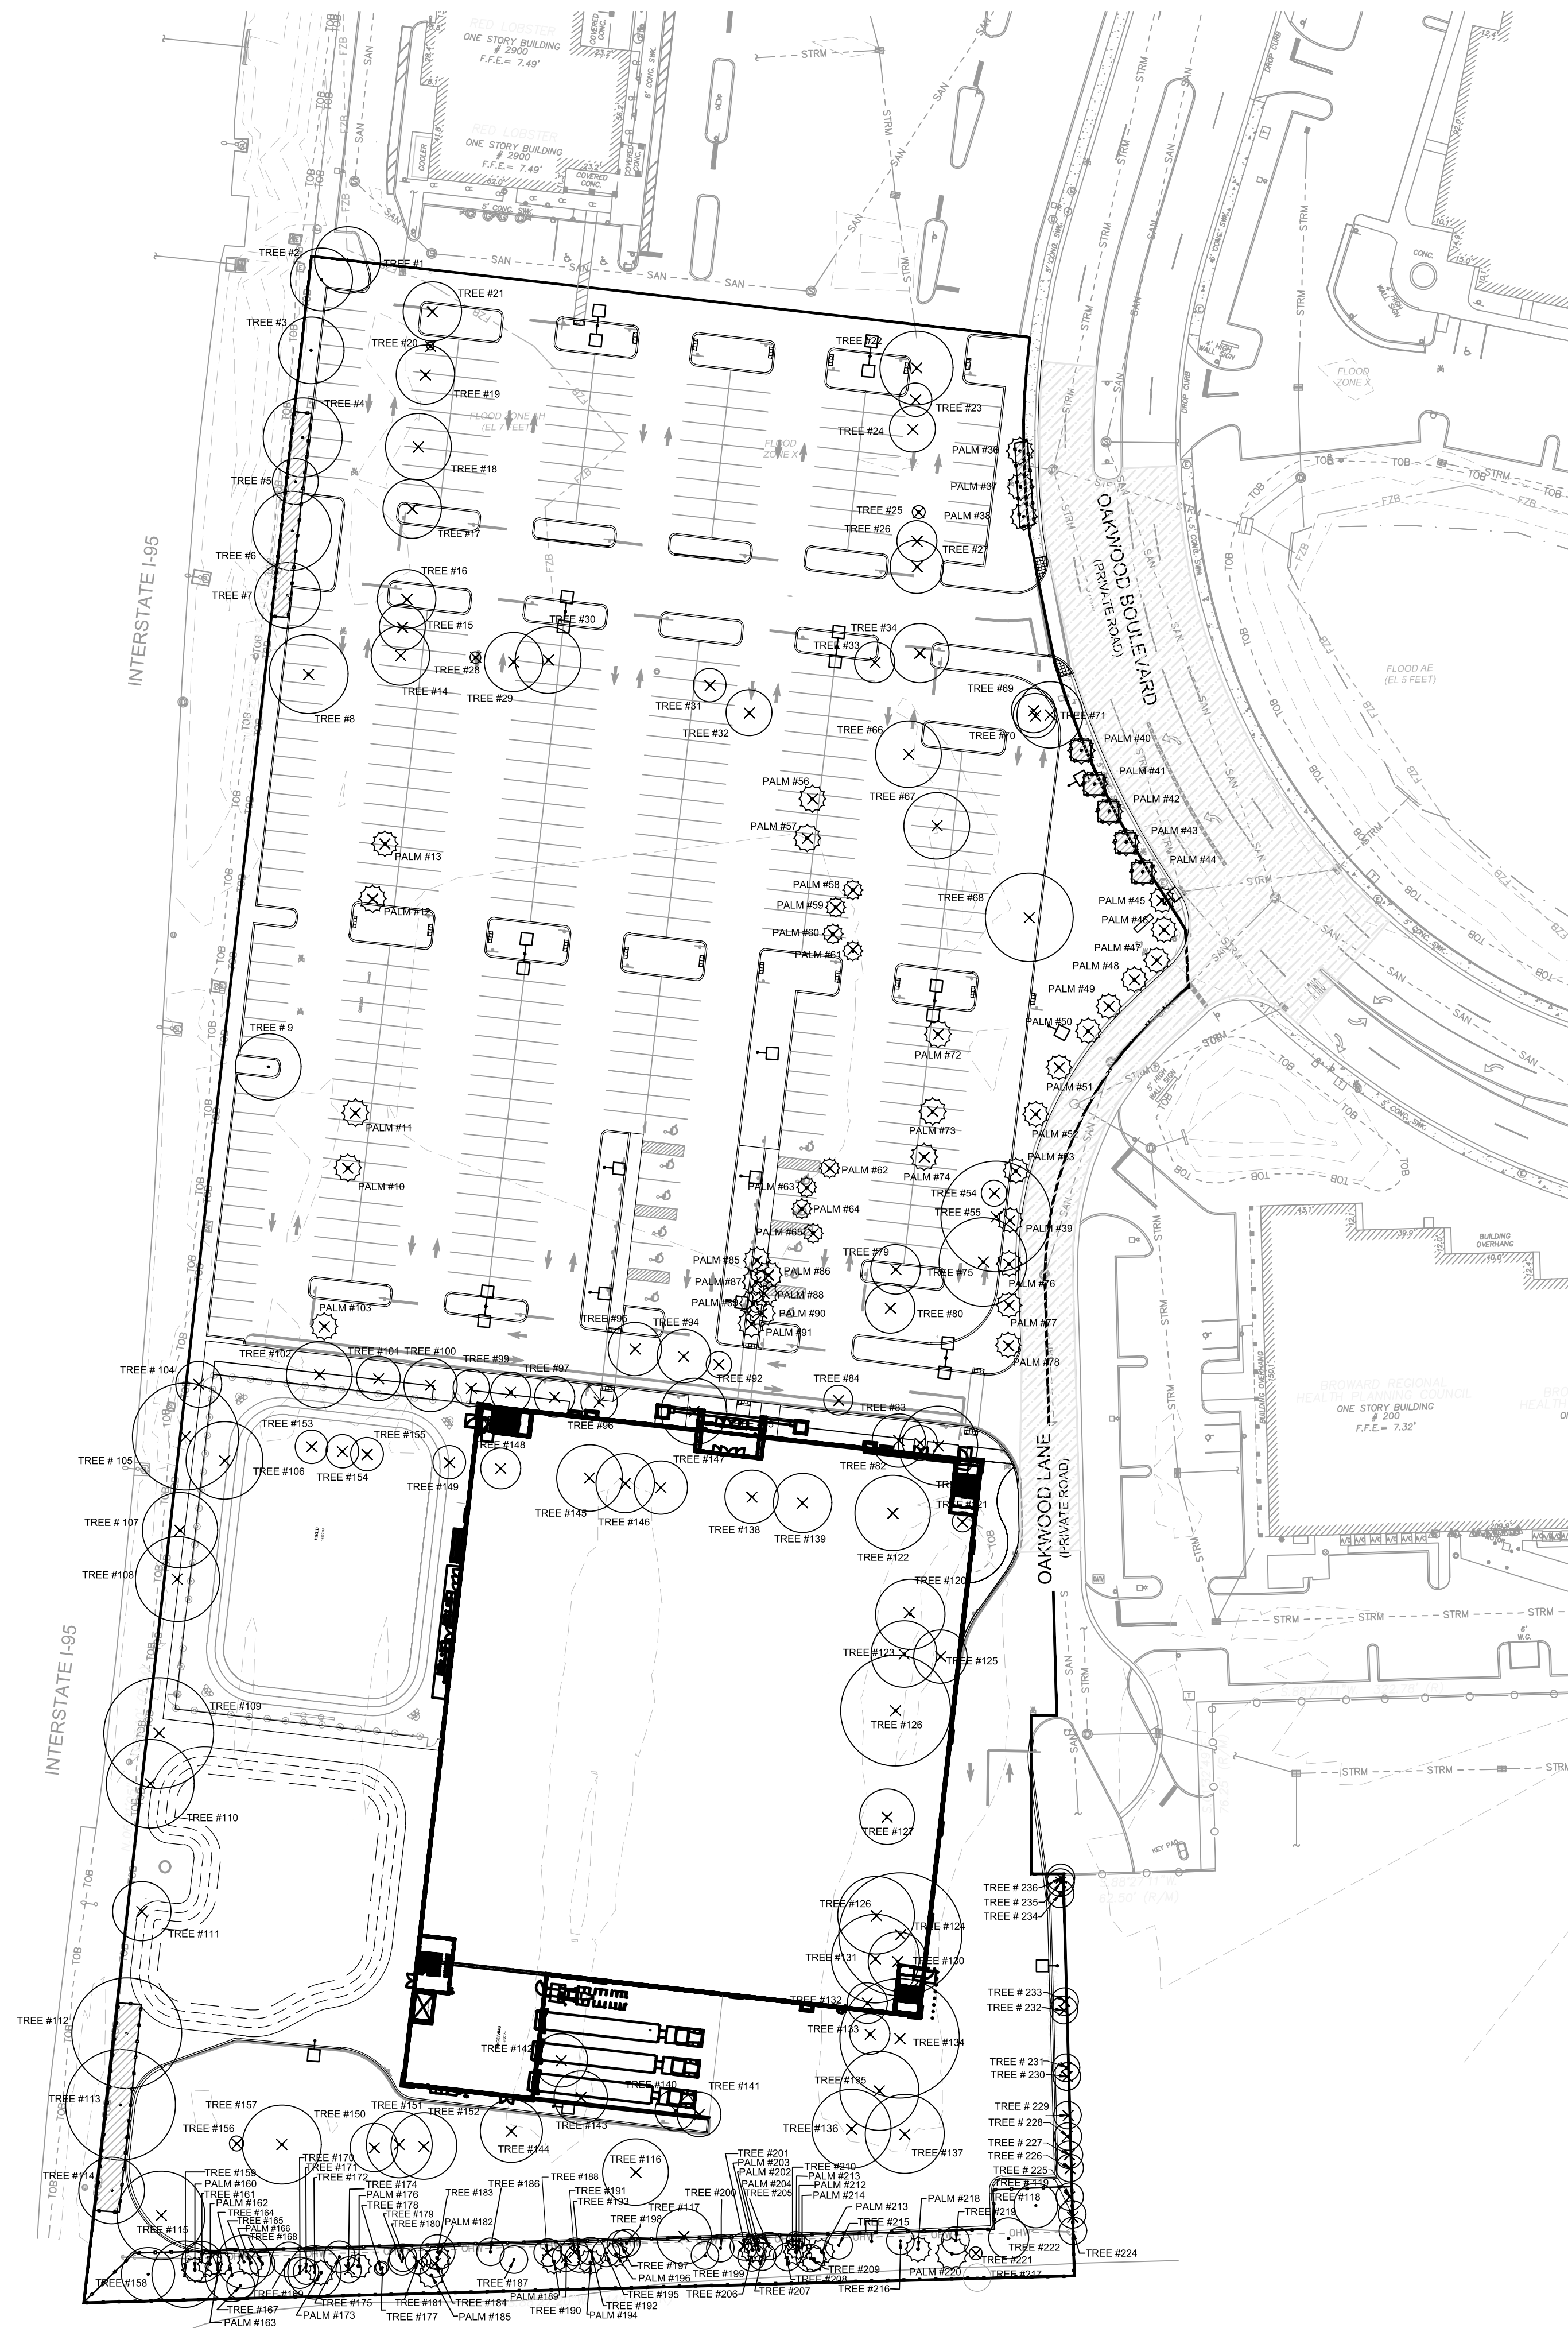

TREE DISPOSITION GRAPHIC LEGEND

<u>SYMBOL</u>	<u>DESCRIPTION</u>	<u>SYMBOL</u>	<u>DESCRIPTION</u>
	TREE TO BE REMOVED		PALM TO BE REMOVED
TREE #		PALM #	
	EXISTING TREE NOT IN SCOPE		TREE PROTECTION FENCE
TREE #			
	TREE TO REMAIN		PALM TO REMAIN
TREE #		PALM #	

*PLEASE REFER TO SHEET L-101 FOR TREE DISPOSITION LIST AND MITIGATION CALCULATIONS.

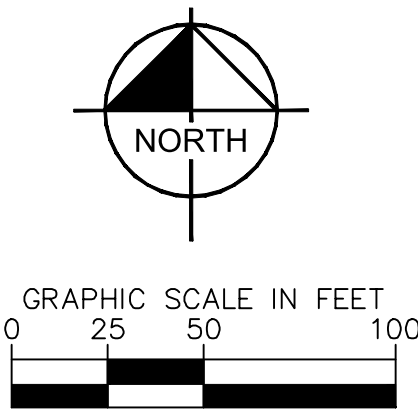

CALL 48 HOURS
BEFORE YOU DIG


IT'S THE LAW!
DIAL 811

811

Know what's **below**.
Call before you dig.

SUNSHINE STATE ONE CALL OF FLORIDA, INC.

THIS ITEM HAS BEEN DIGITALLY SIGNED AND SEALED BY BENJAMIN V. JOHNSON, PLA ON THE DATE ADJACENT TO THE SEAL.
PRINTED COPIES OF THIS DOCUMENT ARE NOT CONSIDERED SIGNED AND SEALED AND THE SIGNATURE MUST BE VERIFIED ON ANY ELECTRONIC COPIES

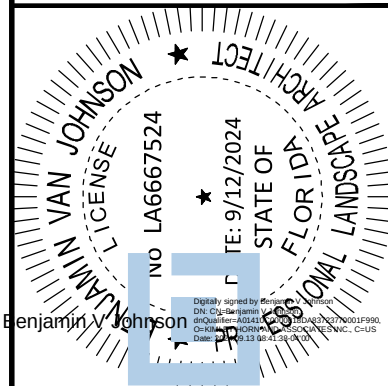

KHA PROJECT	DATE
043326005	9/3/2024
SCALE AS SHOWN	DESIGNED BY
	DRAWN BY
	CHECKED BY

TREE DISPOSITION PLAN

**OAKWOOD SOUTH
RETAIL SHOPPING
CENTER**

CITY OF HOLLYWOOD

SHEET NUMBER

L-100

[illegible]

Kimley»»Horn

445 24TH STREET, SUITE 200, VERO BEACH, FL 32960
PHONE: 772-794-4100
WWW.KIMLEY-HORN.COM REGISTRY NO. 35106

This document, together with the concepts and designs presented herein, as an instrument of service, is intended only for the specific purpose and client for which it was prepared. Reuse of and improper reliance on this document without written authorization and adaptation by Kinley-Horn and Associates, Inc. shall be without liability to Kinley-Horn and Associates, Inc.

TREE DISPOSITION and MITIGATION LIST

KHA TREE NO.	SCIENTIFIC NAME	COMMON NAME	DBH (In.)	SPREAD(ft)	Height (Ft)	Condition	DISPOSITION	MITIGATION
1	Conocarpus erectus	Green Buttonwood	28	30	45	Fair	Remain	
2	Quercus virginiana	Live Oak	17	28	60	Good	Remain	
3	Quercus virginiana	Live Oak	20	30	50	Good	Remain	
4	Quercus virginiana	Live Oak	18	36	50	Good	Remain	
5	Quercus virginiana	Live Oak	18	21	50	Fair	Remain	
6	Quercus virginiana	Live Oak	26	36	55	Good	Remain	
7	Quercus virginiana	Live Oak	21	30	45	Good	Remain	
8	Conocarpus erectus	Green Buttonwood	23	36	40	Good	Remove	
9	Conocarpus erectus	Green Buttonwood	30	30	30	Fair	Remove	
10	Washingtonia Palm	Mexican Fan Palm	12	24	30	Good	Remove	
11	Washingtonia Palm	Mexican Fan Palm	13	24	24	Good	Remove	
12	Washingtonia Palm	Mexican Fan Palm	12	24	40	Good	Remove	
13	Washingtonia Palm	Mexican Fan Palm	12	24	24	Good	Remove	
14	Conocarpus erectus	Green Buttonwood	38	27	30	Fair	Remove	
15	Conocarpus erectus	Green Buttonwood	24	21	30	Fair	Remove	
16	Conocarpus erectus	Green Buttonwood	22	27	30	Fair	Remove	
17	Conocarpus erectus	Green Buttonwood	24	27	34	Poor	Remove	
18	Conocarpus erectus	Green Buttonwood	29	30	34	Fair	Remove	
19	Conocarpus erectus	Green Buttonwood	22	27	45	Poor	Remove	
20	Ilex cassine	Holly	!	3	10	Poor	Remove	
21	Conocarpus erectus	Green Buttonwood	18	27	35	Poor	Remove	
22	Conocarpus erectus	Green Buttonwood	33	33	50	Fair	Remove	
23	Tabebuia heterophylla	Pink Trumpet Tree	7	15	16	Fair	Remove	
24	Tabebuia heterophylla	Pink Trumpet Tree	7	21	18	Good	Remove	
25	Ilex cassine	Holly	3	3	6	Good	Remove	
26	Conocarpus erectus	Green Buttonwood	31	18	31	Fair	Remove	
27	Conocarpus erectus	Green Buttonwood	35	24	50	Fair	Remove	
28	Ilex cassine	Holly	2	5	15	Poor	Remove	
29	Conocarpus erectus	Green Buttonwood	22	27	34	Fair	Remove	
30	Conocarpus erectus	Green Buttonwood	23	30	36	Fair	Remove	
31	Conocarpus erectus	Green Buttonwood	12	15	28	Fair	Remove	
32	Conocarpus erectus	Green Buttonwood	14	21	40	Good	Remove	
33	Conocarpus erectus	Green Buttonwood	6	18	20	Good	Remove	
34	Conocarpus erectus	Green Buttonwood	43	27	45	Good	Remove	
36	Washingtonia palm	Mexican Fan Palm	9	12	60	Fair	Remain	
37	Washingtonia palm	Mexican Fan Palm	9	12	60	Fair	Remain	
38	Washingtonia palm	Mexican Fan Palm	15	12	60	Good	Remain	
39	Washingtonia palm	Mexican Fan Palm	12	12	60	Good	Remove	
40	Washingtonia palm	Mexican Fan Palm	12	12	35	Good	Remain	
41	Washingtonia palm	Mexican Fan Palm	12	12	55	Good	Remain	
42	Washingtonia palm	Mexican Fan Palm	12	12	55	Good	Remain	
43	Washingtonia palm	Mexican Fan Palm	12	12	55	Good	Remain	
44	Washingtonia palm	Mexican Fan Palm	12	12	55	Good	Remain	
45	Washingtonia palm	Mexican Fan Palm	12	12	55	Good	Remove	
46	Washingtonia palm	Mexican Fan Palm	12	12	55	Good	Remove	
47	Washingtonia palm	Mexican Fan Palm	26	12	55	Good	Remove	
48	Washingtonia palm	Mexican Fan Palm	12	12	55	Good	Remove	
49	Washingtonia palm	Mexican Fan Palm	12	12	55	Good	Remove	
50	Washingtonia palm	Mexican Fan Palm	12	12	55	Good	Remove	
51	Washingtonia palm	Mexican Fan Palm	10	12	55	Good	Remove	
52	Washingtonia palm	Mexican Fan Palm	12	12	55	Good	Remove	
53	Washingtonia palm	Mexican Fan Palm	14	12	55	Good	Remove	
54	Quercus virginiana	Live Oak	11	12	50	Poor	Remove	
55	Quercus virginiana	Live Oak	20	50	45	Good	Remove	
56	Washingtonia palm	Mexican Fan Palm	12	12	50	Fair	Remove	
57	Washingtonia palm	Mexican Fan Palm	12	12	50	Fair	Remove	
58	Phoenix robelinii	Pygmy Date Palm	4	9	12	Good	Remove	
59	Phoenix robelinii	Pygmy Date Palm (dbl)	4	16	12	Good	Remove	
60	Phoenix robelinii	Pygmy Date Palm (dbl)	4	16	12	Good	Remove	
61	Phoenix robelinii	Pygmy Date Palm (dbl)	4	16	12	Good	Remove	
62	Phoenix robelinii	Pygmy Date Palm (dbl)	4	16	12	Good	Remove	
63	Phoenix robelinii	Pygmy Date Palm (dbl)	4	16	12	Good	Remove	
64	Phoenix robelinii	Pygmy Date Palm (dbl)	4	16	12	Good	Remove	
65	Phoenix robelinii	Pygmy Date Palm (dbl)	4	16	12	Good	Remove	
66	Tabebuia heterophylla	Pink Trumpet Tree	9	30	24	Good	Remove	
67	Tabebuia heterophylla	Pink Trumpet Tree	22	30	30	Good	Remove	
68	Conocarpus erectus	Green Buttonwood	34	40	40	Good	Remove	
69	Quercus virginiana	Live Oak	20	20	30	Poor	Remove	
70	Quercus virginiana	Live Oak	17	20	40	Fair	Remove	
71	Quercus virginiana	Live Oak	17	30	35	Fair	Remove	
72	Washingtonia palm	Mexican Fan Palm	12	12	60	Good	Remove	
73	Washingtonia palm	Mexican Fan Palm	12	12	60	Good	Remove	
74	Washingtonia palm	Mexican Fan Palm	12	12	60	Good	Remove	
75	Quercus virginiana	Live Oak	19	40	50	Good	Remove	
76	Washingtonia palm	Mexican Fan Palm	12	12	45	Fair	Remove	
77	Washingtonia palm	Mexican Fan Palm	12	12	45	Fair	Remove	
78	Washingtonia palm	Mexican Fan Palm	12	12	45	Fair	Remove	
79	Tabebuia heterophylla	Pink Trumpet Tree	12	22	25	Fair	Remove	
80	Tabebuia heterophylla	Pink Trumpet Tree	10	22	25	Fair	Remove	

TREE MITIGATION CALCULATIONS		
TOTAL MITIGATION REQUIRED (DBH IN INCHES)		2,039
TOTAL DBH PROVIDED (IN INCHES)		247
TOTAL PALMS REMOVED (EA.)		38
TOTAL PALMS PROVIDED (EA.)		38

TREE TRUST FUND CALCULATIONS		
TOTAL MITIGATION REQUIRED (DBH IN INCHES)		2,039
TOTAL DBH PROVIDED		247
TOTAL DBH DELTA		1,792
TOTAL TREE REPLACEMENT TREE DEFICIT (12 FT" HT. x 2" DBH):		896

TOTAL TREE TRUST FUND CONTRIBUTION (TREE DEFICIT x \$350)	\$	313,600.00
---	----	------------

81	Conocarpus erectus	Green Buttonwood	20	24	50	Fair	Remove	
82	Conocarpus erectus	Green Buttonwood	18	16	50	Fair	Remove	
83	Conocarpus erectus	Green Buttonwood	40	36	50	Fair	Remove	
84	Conocarpus erectus	Green Buttonwood	6	13	15	Fair	Remove	
85	Washingtonia palm	Mexican Fan Palm	12	12	45	Fair	Remove	
86	Washingtonia palm	Mexican Fan Palm	12	12	45	Fair	Remove	
87	Washingtonia palm	Mexican Fan Palm	12	12	45	Fair	Remove	
88	Washingtonia palm	Mexican Fan Palm	12	12	45	Fair	Remove	
89	Washingtonia palm	Mexican Fan Palm	12	12	45	Fair	Remove	
90	Washingtonia palm	Mexican Fan Palm	12	12	45	Fair	Remove	
91	Washingtonia palm	Mexican Fan Palm	12	12	45	Fair	Remove	
92	Tabebuia heterophylla	Pink Trumpet Tree	8	12	18	Fair	Remove	
93	Conocarpus erectus	Green Buttonwood	43	30	40	Fair	Remove	
94	Tabebuia heterophylla	Pink Trumpet Tree	10	24	38	Fair	Remove	
95	Tabebuia heterophylla	Pink Trumpet Tree	14	24	50	Poor	Remove	
96	Conocarpus erectus	Green Buttonwood	16	17	45	Poor	Remove	
97	Conocarpus erectus	Green Buttonwood	26	18	45	Fair	Remove	
98	Conocarpus erectus	Green Buttonwood	21	18	40	Fair	Remove	
99	Conocarpus erectus	Green Buttonwood	31	17	40	Fair	Remove	
100	Conocarpus erectus	Green Buttonwood	21	24	40	Fair	Remove	
101	Conocarpus erectus	Green Buttonwood	32	20	40	Poor	Remove	
102	Conocarpus erectus	Green Buttonwood	25	25	40	Fair	Remove	
103	Washingtonia palm	Mexican Fan Palm	12	12	20	Good	Remove	
104	Conocarpus erectus	Green Buttonwood	30	21	55	Fair	Remove	
105	Quercus virginiana	Live Oak	25	48	55	Good	Remove	
106	Conocarpus erectus	Green Buttonwood	34	35	60	Fair	Remove	
107	Conocarpus erectus	Green Buttonwood	28	34	40	Good	Remove	
108	Conocarpus erectus	Green Buttonwood	30	38	45	Good	Remove	
109	Quercus virginiana	Live Oak	19	50	55	Good	Remove	
110	Quercus virginiana	Live Oak	28	40	40	Good	Remove	
111	Quercus virginiana	Live Oak	14	27	30	Good	Remove	
112	Quercus virginiana	Live Oak	26	50	50	Good	Remain	
113	Quercus virginiana	Live Oak	26	50	50	Good	Remain	
114	Conocarpus erectus	Green Buttonwood	24	30	240	Fair	Remain	
115	Conocarpus erectus	Green Buttonwood	30	40	35	Good	Remove	
116	Buckia buceras	Black Olive	16	18	35	Poor	Remove	
117	Conocarpus erectus	Green Buttonwood	10	25	30	Poor	Remain	
118	Quercus virginiana	Live Oak	14	20	25	Fair	Remain	
120	Quercus virginiana	Live Oak	21	32	45	Good	Remove	
121	Conocarpus erectus	Green Buttonwood	5	9	12	Poor	Remove	
122	Conocarpus erectus	Green Buttonwood	43	34	50	Good	Remove	
123	Quercus virginiana	Live Oak	20	30	45	Good	Remove	
124	Quercus virginiana	Live Oak	20	56	55	Good	Remove	
125	Tabebuia heterophylla	Pink Trumpet Tree	16	24	30	Good	Remove	
126	Quercus virginiana	Live Oak	16	50	50	Good	Remove	
127	Tabebuia heterophylla	Pink Trumpet Tree	13	25	30	Good	Remove	
128	Quercus virginiana	Live Oak	12	26	35	Good	Remove	
129	Quercus virginiana	Live Oak	14	16	30	Fair	Remove	
130	Quercus virginiana	Live Oak	9	27	30	Fair	Remove	
131	Quercus virginiana	Live Oak	16	40	36	Fair	Remove	
132	Quercus virginiana	Live Oak	11	18	30	Fair	Remove	
133	Quercus virginiana	Live Oak	14	18	30	Poor	Remove	
134	Quercus virginiana	Live Oak	30	54	50	Good	Remove	
135	Quercus virginiana	Live Oak	16	36	50	Good	Remove	
136	Quercus virginiana	Live Oak	32	30	45	Fair	Remove	
137	Quercus virginiana	Live Oak	18	36	55	Fair	Remove	
138	Conocarpus erectus	Green Buttonwood	30	24	45	Good	Remove	
139	Conocarpus erectus	Green Buttonwood	37	27	45	Good	Remove	
140	Conocarpus erectus	Green Buttonwood	8	18	20	Poor	Remove	
141	Conocarpus erectus	Green Buttonwood	11	20	25	Good	Remove	
142	Conocarpus erectus	Green Buttonwood	20	24	30	Good	Remove	
143	Conocarpus erectus	Green Buttonwood	9	24	30	Good	Remove	
144	Conocarpus erectus	Green Buttonwood	8	24	28	Fair	Remove	
145	Conocarpus erectus	Green Buttonwood	36	30	55	Fair	Remove	
146	Conocarpus erectus	Green Buttonwood	40	27	55	Fair	Remove	
147	Conocarpus erectus	Green Buttonwood	42	24	50	Poor	Remove	
148	Conocarpus erectus	Green Buttonwood	31	18	40	Poor	Remove	
149	Conocarpus erectus	Green Buttonwood	18	15	35	Poor	Remove	
150	Conocarpus erectus	Green Buttonwood	36	22	40	Poor	Remove	
151	Conocarpus erectus	Green Buttonwood	41	30	50	Poor	Remove	
152	Conocarpus erectus	Green Buttonwood	24	30	45	Poor	Remove	
153	Conocarpus erectus	Green Buttonwood	9	15	20	Fair	Remove	
154	Conocarpus erectus	Green Buttonwood	13	15	24	Fair	Remove	
155	Conocarpus erectus	Green Buttonwood	10	15	20	Fair	Remove	
156	Ilex cassine	Holly	7	12	12	Fair	Remove	
157	Conocarpus erectus	Green Buttonwood	46	36	60	Fair	Remove	
158	Quercus virginiana	Live Oak	12	24	30	Poor	Remain	
159	Quercus virginiana	Live Oak	15	30	35	Poor	Remain	
160	Ptchospemna macarthurii	MacArthur Palm	3	6	10	Fair	Remain	

161	<i>Ficus lyrata</i>	Fiddle Leaf Fig Tree	9	18	20	Poor	Remain	
162	<i>Ptchospemna macarthurii</i>	MacArthur Palm	4	5	8	Fair	Remain	
163	<i>Ptchospemna macarthurii</i>	MacArthur Palm	4	5	8	Fair	Remain	
164	<i>Quercus virginiana</i>	Live Oak	12	18	26	Poor	Remain	
165	<i>Conocarpus erectus serceus</i>	Silver Buttonwood	12	12	10	Poor	Remain	
166	<i>Ptchospemna macarthurii</i>	MacArthur Palm	4	5	8	Fair	Remain	
167	<i>Quercus virginiana</i>	Live Oak	5	15	25	Poor	Remain	
168	<i>Quercus virginiana</i>	Live Oak	6	12	18	Poor	Remain	
169	<i>Quercus virginiana</i>	Live Oak	8	16	20	Poor	Remain	
170	<i>Quercus virginiana</i>	Live Oak	8	14	20	Poor	Remain	
171	<i>Conocarpus erectus</i>	Green Buttonwood	10	12	18	Fair	Remain	
172	<i>Conocarpus erectus</i>	Green Buttonwood	10	16	20	Fair	Remain	
173	<i>Ptchospemna macarthurii</i>	MacArthur Palm	4	5	8	Poor	Remain	
174	<i>Schefflera</i>	Umbrella Tree	6	6	12	Poor	Remove	Invasive
175	<i>Conocarpus erectus</i>	Green Buttonwood	6	7	12	Fair	Remain	
176	<i>Ptchospemna macarthurii</i>	MacArthur Palm	2	4	8	Fair	Remain	
177	<i>Conocarpus erectus</i>	Green Buttonwood	6	7	12	Fair	Remain	
178	<i>Conocarpus erectus</i>	Green Buttonwood	6	7	12	Fair	Remain	
179	<i>Conocarpus erectus</i>	Green Buttonwood	6	7	12	Fair	Remain	
180	<i>Conocarpus erectus</i>	Green Buttonwood	6	7	12	Fair	Remain	
181	<i>Schefflera</i>	Umbrella Tree	8	6	12	Poor	Remove	Invasive
182	<i>Ptchospemna macarthurii</i>	MacArthur Palm	3	6	12	Fair	Remain	
183	<i>Quercus virginiana</i>	Live Oak	10	16	20	Poor	Remain	
184	<i>Schefflera</i>	Umbrella Tree	4	5	12	Poor	Remove	Invasive
185	<i>Sabal palmetto</i>	Sabal Palm	14	8	12	Fair	Remain	
186	<i>Quercus virginiana</i>	Live Oak	10	17	22	Fair	Remain	
187	<i>Conocarpus erectus</i>	Green Buttonwood	10	16	20	Fair	Remain	
188	<i>Schefflera</i>	Umbrella Tree	6	7	12	Poor	Remove	Invasive
189	<i>Sabal palmetto</i>	Sabal Palm	14	8	10	Fair	Remain	
190	<i>Schefflera</i>	Umbrella Tree	5	6	12	Fair	Remove	Invasive
191	<i>Schefflera</i>	Umbrella Tree	4	4	8	Fair	Remove	Invasive
192	<i>Conocarpus erectus</i>	Green Buttonwood	10	16	20	Fair	Remain	
193	<i>Schefflera</i>	Umbrella Tree	3	4	6	Fair	Remove	Invasive
194	<i>Ptchospemna macarthurii</i>	MacArthur Palm	3	4	5	Fair	Remain	
195	<i>Conocarpus erectus</i>	Green Buttonwood	6	10	16	Fair	Remain	
196	<i>Sabal palmetto</i>	Sabal Palm	14	8	10	Fair	Remain	
197	<i>Conocarpus erectus serceus</i>	Silver Buttonwood	4	5	10	Poor	Remain	
198	<i>Conocarpus erectus serceus</i>	Silver Buttonwood	4	5	10	Poor	Remain	
199	<i>Conocarpus erectus</i>	Green Buttonwood	5	6	15	Poor	Remain	
200	<i>Quercus virginiana</i>	Live Oak	8	12	15	Fair	Remain	
201	<i>Schefflera</i>	Umbrella Tree	4	5	12	Poor	Remove	Invasive
202	<i>Ptchospemna macarthurii</i>	MacArthur Palm	4	4	5	Fair	Remain	
203	<i>Ptchospemna macarthurii</i>	MacArthur Palm	3	3	4	Fair	Remain	
204	<i>Ptchospemna macarthurii</i>	MacArthur Palm	3	4	4	Fair	Remain	
205	<i>Quercus virginiana</i>	Live Oak	3	20	25	Fair	Remain	
206	<i>Conocarpus erectus</i>	Green Buttonwood	14	20	18	Poor	Remain	
207	<i>Conocarpus erectus</i>	Green Buttonwood	12	18	16	Poor	Remain	
208	<i>Conocarpus erectus</i>	Green Buttonwood	10	18	20	Poor	Remain	
209	<i>Conocarpus erectus</i>	Green Buttonwood	22	20	20	Poor	Remain	
210	<i>Schefflera</i>	Umbrella Tree	8	8	20	Fair	Remove	Invasive
211	<i>Schefflera</i>	Umbrella Tree	8	8	18	Fair	Remove	Invasive
212	<i>Ptchospemna macarthurii</i>	MacArthur Palm	5	6	9	Fair	Remain	
213	<i>Ptchospemna macarthurii</i>	MacArthur Palm	4	5	7	Fair	Remain	
214	<i>Ptchospemna macarthurii</i>	MacArthur Palm	5	4	7	Fair	Remain	
215	<i>Quercus virginiana</i>	Live Oak	18	36	35	Fair	Remain	
216	<i>Quercus virginiana</i>	Live Oak	16	24	30	Fair	Remain	
217	<i>Schefflera</i>	Umbrella Tree	6	8	30	Poor	Remain	N.I.S.
218	<i>Sabal palmetto</i>	Sabal Palm	14	9	12	Fair	Remain	
219	<i>Quercus virginiana</i>	Live Oak	12	15	25	Fair	Remain	
220	<i>Sabal palmetto</i>	Sabal Palm	24	15	16	Fair	Remain	
221	<i>Schefflera</i>	Umbrella Tree	6	8	10	Poor	Remove	Invasive
222	<i>Quercus virginiana</i>	Live Oak	16	18	20	Fair	Remain	
223	<i>Quercus virginiana</i>	Live Oak	10	18	25	Poor	Remain	
224	<i>Ficus benjamina</i>	Ficus Tree	1	2	2	Poor	Remove	Invasive
225	<i>Ficus benjamina</i>	Ficus Tree	1	3	3	Poor	Remove	Invasive
226	<i>Ficus benjamina</i>	Ficus Tree Cluster	3	3	3"	Poor	Remove	Invasive
227	<i>Ficus benjamina</i>	Ficus Tree Cluster	3	3	4	Poor	Remove	Invasive
228	<i>Ficus benjamina</i>	Ficus Tree	2	4	5"	Poor	Remove	Invasive
229	<i>Ficus benjamina</i>	Ficus Tree	1	3	3"	Poor	Remove	Invasive
230	<i>Ficus benjamina</i>	Ficus Tree	2	3	3	Poor	Remove	Invasive
231	<i>Ficus benjamina</i>	Ficus Tree	2	4	5	Poor	Remove	Invasive
232	<i>Ficus benjamina</i>	Ficus Tree	2	3	5	Poor	Remove	Invasive
233	<i>Schefflera</i>	Umbrella Tree	6	4	7"	Poor	Remove	Invasive
234	<i>Ficus benjamina</i>	Ficus Tree	1	3	3	Poor	Remove	Invasive
235	<i>Ficus benjamina</i>	Ficus Tree	1	2	3	Poor	Remove	Invasive
236	<i>Ficus benjamina</i>	Ficus Tree	2	3	6	Poor	Remove	Invasive
							TOTAL DBH REMOVED (IN.)	2039
N.I.S. = Not in Scope							TOTAL PALMS REMOVED (EA.)	38

This document, together with the concepts and designs presented herein, as an instrument of service, is intended only for the specific purpose and client for which it was prepared. Reuse of and improper reliance on this document without written authorization and adaptation by Kimley-Horn and Associates, Inc. shall be without liability to Kimley-Horn and Associates, Inc.

TREE REMOVAL AND TREE TO REMAIN PRUNING SPECIFICATIONS

PART 1 - DEFINITIONS

- A. Natural Resource - Existing trees or palms.
- B. Critical Root Zone - The minimum volume of roots necessary to have for tree health and stability.
- C. DBH - Diameter Breast High - Indicates the location on the trunk, approximately 4.5' above ground, to measure the diameter of a tree.
- D. Preserved Trees - Trees that are to be saved/remain in place.
- E. Owner's Representative - A representative, hired and paid for by the owner, that supervises the construction of the procedures shown on the tree disposition plans.
- F. Tree Protection Zone (TPZ) - The area surrounding a tree defined by a specified distance, which excavation and other construction related activities should be avoided. The TPZ is variable depending on species, factors, age and health of the plant, soil conditions, and proposed construction.
- G. Contractor's Certified Arborist - an independent ISA Certified Arborist, hired and paid for by the contractor, that supervises the construction of the procedures shown on the tree disposition plans.

PART 2 - TREE BARRIER

- A. Tree Protector Barrier Material.
 - 1. Six (6) foot tall wire mesh construction fence supported by eight (8) foot tall metal T-Bar Posts and Post Caps.
 - 2. The tree protector barrier shall have a two (2) foot by two (2) foot "tree protection zone" sign affixed to the fence every twenty (20) feet placed in such a manner to be clearly visible to the construction workers. The sign must be made up of weather resistant material.
 - 3. The eight (8) foot tall metal T-Bar Post and Post Cap shall be placed a maximum of six (6) foot intervals.

PART 3 - EXECUTION

- A. If hazards are determined by qualified certified arborist in an individual tree then those hazards can be mitigated according to the specifications given by the Qualified Certified Arborist.
 - 1. The tree disposition list. This item is to be coordinated by the Qualified Certified Arborist with the Owner's Representative.
 - 2. All pruning shall be done in accordance with ANSI A300 (Part 1) Pruning and best management practices.
 - 3. The Contractor's Certified Arborist shall be present during all pruning operations.
- B. Root Pruning - Refer to Arborist Report
 - 1. Trenching locations shall be approved in the field by the Owner's Representative and the Contractor's Certified Arborist.
 - 2. All roots shall be cut by hand.
 - 3. The trench shall be backfilled minus debris and large rocks, as directed by the Contractor's Certified Arborist.
 - 4. Phased root pruning timeframes vary by species. Contractor's certified arborist shall direct pruning schedule.
- C. Tree Protector Barrier
 - 1. See detail in this sheet.
 - 2. Tree Protector Barrier shall be placed by the Contractor around each tree to remain as directed by the Contractor's Certified Arborist.
- D. Tree Removals
 - 1. Contractor shall remove and discard all trees shown as "Remove" on the Tree Disposition Plan and the Tree Disposition List. Tree stump shall be ground below grade. Care shall be taken to not damage the existing trees marked to remain and their critical root zones shall not be compacted by equipment.
 - 2. If Tree Protector Barrier is damaged, repair shall be performed immediately.
 - 3. Contractor shall remove and haul away from the job site all wood generated from tree removals, including stumps, the same day the removal happens.
 - 4. Burn pits are not allowed.

PART 4 - PENALTIES


- A. Repair of Damaged Trees To Remain
 - 1. If any damage to trees to remain or other natural resources should occur by accident or negligence during the construction period, shall be immediately inspected by Qualified Certified Arborist who shall determine the prescription of care at the Contractor's expense.

PART 5 - TREE PROTECTION

- A. Contractor's Certified Arborist to determine the location of the Tree Protector Barrier around each tree to remain based on his/her analysis of each existing tree to remain that is adjacent to construction improvements such as utility installation, pavement addition and/or restoration, etc.
- B. Contractor shall maintain and repair the Tree Protector Barrier during site construction operations.
- C. Contractor's access to the fenced tree protection areas will be permitted only with approval of Owner's Representative and Contractor's Certified Arborist's written directive.
- D. There shall no be change in grade within the critical root zone as per ANSI Standards.
- E. Contractor shall clear by hand all vegetation to grade within the critical root zones of trees to remain.
- F. Contractor shall not install conduit, sprinklers, or any utility line in any critical root zone areas without the approval of the Contractor's Certified Arborist and Owner's Representative.

PART 6 - IRRIGATION

- A. Contractor shall irrigate trees as specified by Landscape Architect and Qualified Certified Arborist.
- B. On a monthly basis an irrigation audit shall be conducted by an irrigation specialist for review by Landscape Architect or Qualified Certified Arborist.

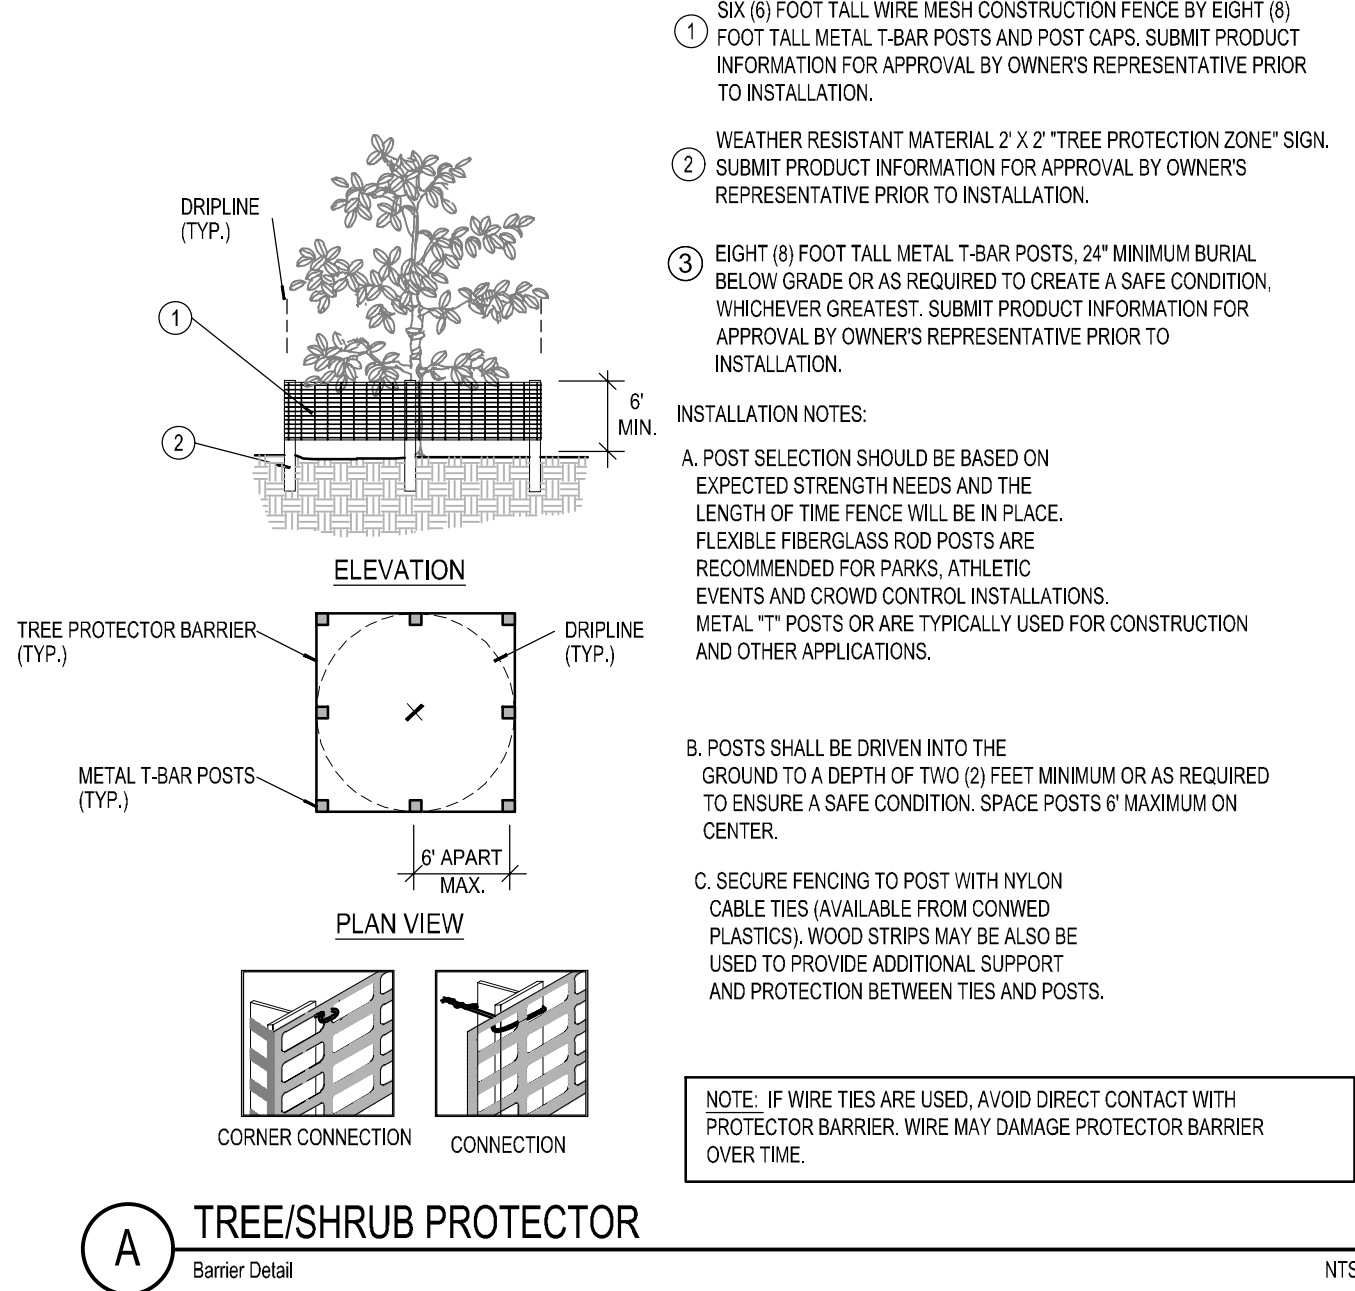

- SIX (6) FOOT TALL WIRE MESH CONSTRUCTION FENCE BY EIGHT (8) FOOT TALL METAL T-BAR POSTS AND POST CAPS. SUBMIT PRODUCT INFORMATION FOR APPROVAL BY OWNER'S REPRESENTATIVE PRIOR TO INSTALLATION.
 - WEATHER RESISTANT MATERIAL 2' X 2' "TREE PROTECTION ZONE" SIGN. SUBMIT PRODUCT INFORMATION FOR APPROVAL BY OWNER'S REPRESENTATIVE PRIOR TO INSTALLATION.
 - EIGHT (8) FOOT TALL METAL T-BAR POSTS. 24" MINIMUM BURIAL BELOW GRADE OR AS REQUIRED TO CREATE A SAFE CONDITION, WHICHEVER GREATEST. SUBMIT PRODUCT INFORMATION FOR APPROVAL BY OWNER'S REPRESENTATIVE PRIOR TO INSTALLATION.
- INSTALLATION NOTES:**
- A. POST SELECTION SHOULD BE BASED ON EXPECTED STRENGTH NEEDS AND THE LENGTH OF TIME FENCE WILL BE IN PLACE. FLEXIBLE FIBERGLASS ROD POSTS ARE RECOMMENDED FOR PARKS, ATHLETIC EVENTS AND CROWD CONTROL INSTALLATIONS. METAL "T" POSTS OR ARE TYPICALLY USED FOR CONSTRUCTION AND OTHER APPLICATIONS.
- B. POSTS SHALL BE DRIVEN INTO THE GROUND TO A DEPTH OF TWO (2) FEET MINIMUM OR AS REQUIRED TO ENSURE A SAFE CONDITION. SPACE POSTS 6' MAXIMUM ON CENTER.
- C. SECURE FENCING TO POST WITH NYLON CABLE TIES (AVAILABLE FROM COINED PLASTICS). WOOD STRIPS MAY BE ALSO BE USED TO PROVIDE ADDITIONAL SUPPORT AND PROTECTION BETWEEN TIES AND POSTS.

THIS ITEM HAS BEEN DIGITALLY SIGNED AND SEALED BY BENJAMIN V. JOHNSON, PLA ON THE DATE ADJACENT TO THE SIGNATURE. PRINTED COPIES OF THIS DOCUMENT ARE NOT CONSIDERED SIGNED AND SEALED AND THE SIGNATURE MUST BE VERIFIED ON ANY ELECTRONIC COPIES.

KHA PROJECT	043326005
DATE	9/3/2024
SCALE	AS SHOWN
DESIGNED BY	NIR
DRAWN BY	NIR
CHECKED BY	KD

TREE DISPOSITION DETAILS

OAKWOOD SOUTH
RETAIL SHOPPING
CENTER

CITY OF HOLLYWOOD FL

SHEET NUMBER
L-102

CALL 48 HOURS
BEFORE YOU DIG


IT'S THE LAW!
DIAL 811

Know what's below.
Call before you dig.

SUNSHINE STATE ONE CALL OF FLORIDA, INC.

Kimley»Horn

445 24TH STREET, SUITE 200, VERO BEACH, FL 32960
PHONE: 772-794-4100
WWW.KIMLEY-HORN.COM REGISTRY NO. 35106

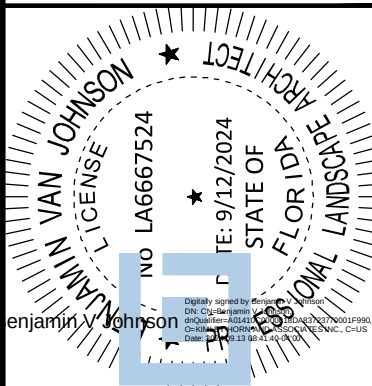

KHA PROJECT	043326005
DATE	9/3/2024
SCALE	AS SHOWN
DESIGNED BY	NIR
DRAWN BY	NIR
CHECKED BY	KD

TREE DISPOSITION DETAILS

OAKWOOD SOUTH
RETAIL SHOPPING
CENTER

CITY OF HOLLYWOOD FL

SHEET NUMBER
L-102

CALL 48 HOURS
BEFORE YOU DIG


IT'S THE LAW!
DIAL 811

Know what's below.
Call before you dig.

SUNSHINE STATE ONE CALL OF FLORIDA, INC.


Kimley»Horn

445 24TH STREET, SUITE 200, VERO BEACH, FL 32960
PHONE: 772-794-4100
WWW.KIMLEY-HORN.COM REGISTRY NO. 35106

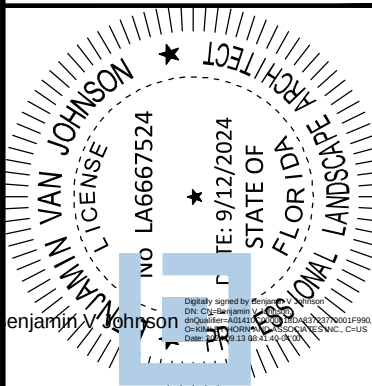

KHA PROJECT	043326005
DATE	9/3/2024
SCALE	AS SHOWN
DESIGNED BY	NIR
DRAWN BY	NIR
CHECKED BY	KD

This document, together with the concepts and designs presented herein, is intended only for the specific purpose and client for which it was prepared. Reuse of and improper reliance on this document without written authorization and adaptation by Kimley-Horn and Associates, Inc. shall be without liability to Kimley-Horn and Associates, Inc.

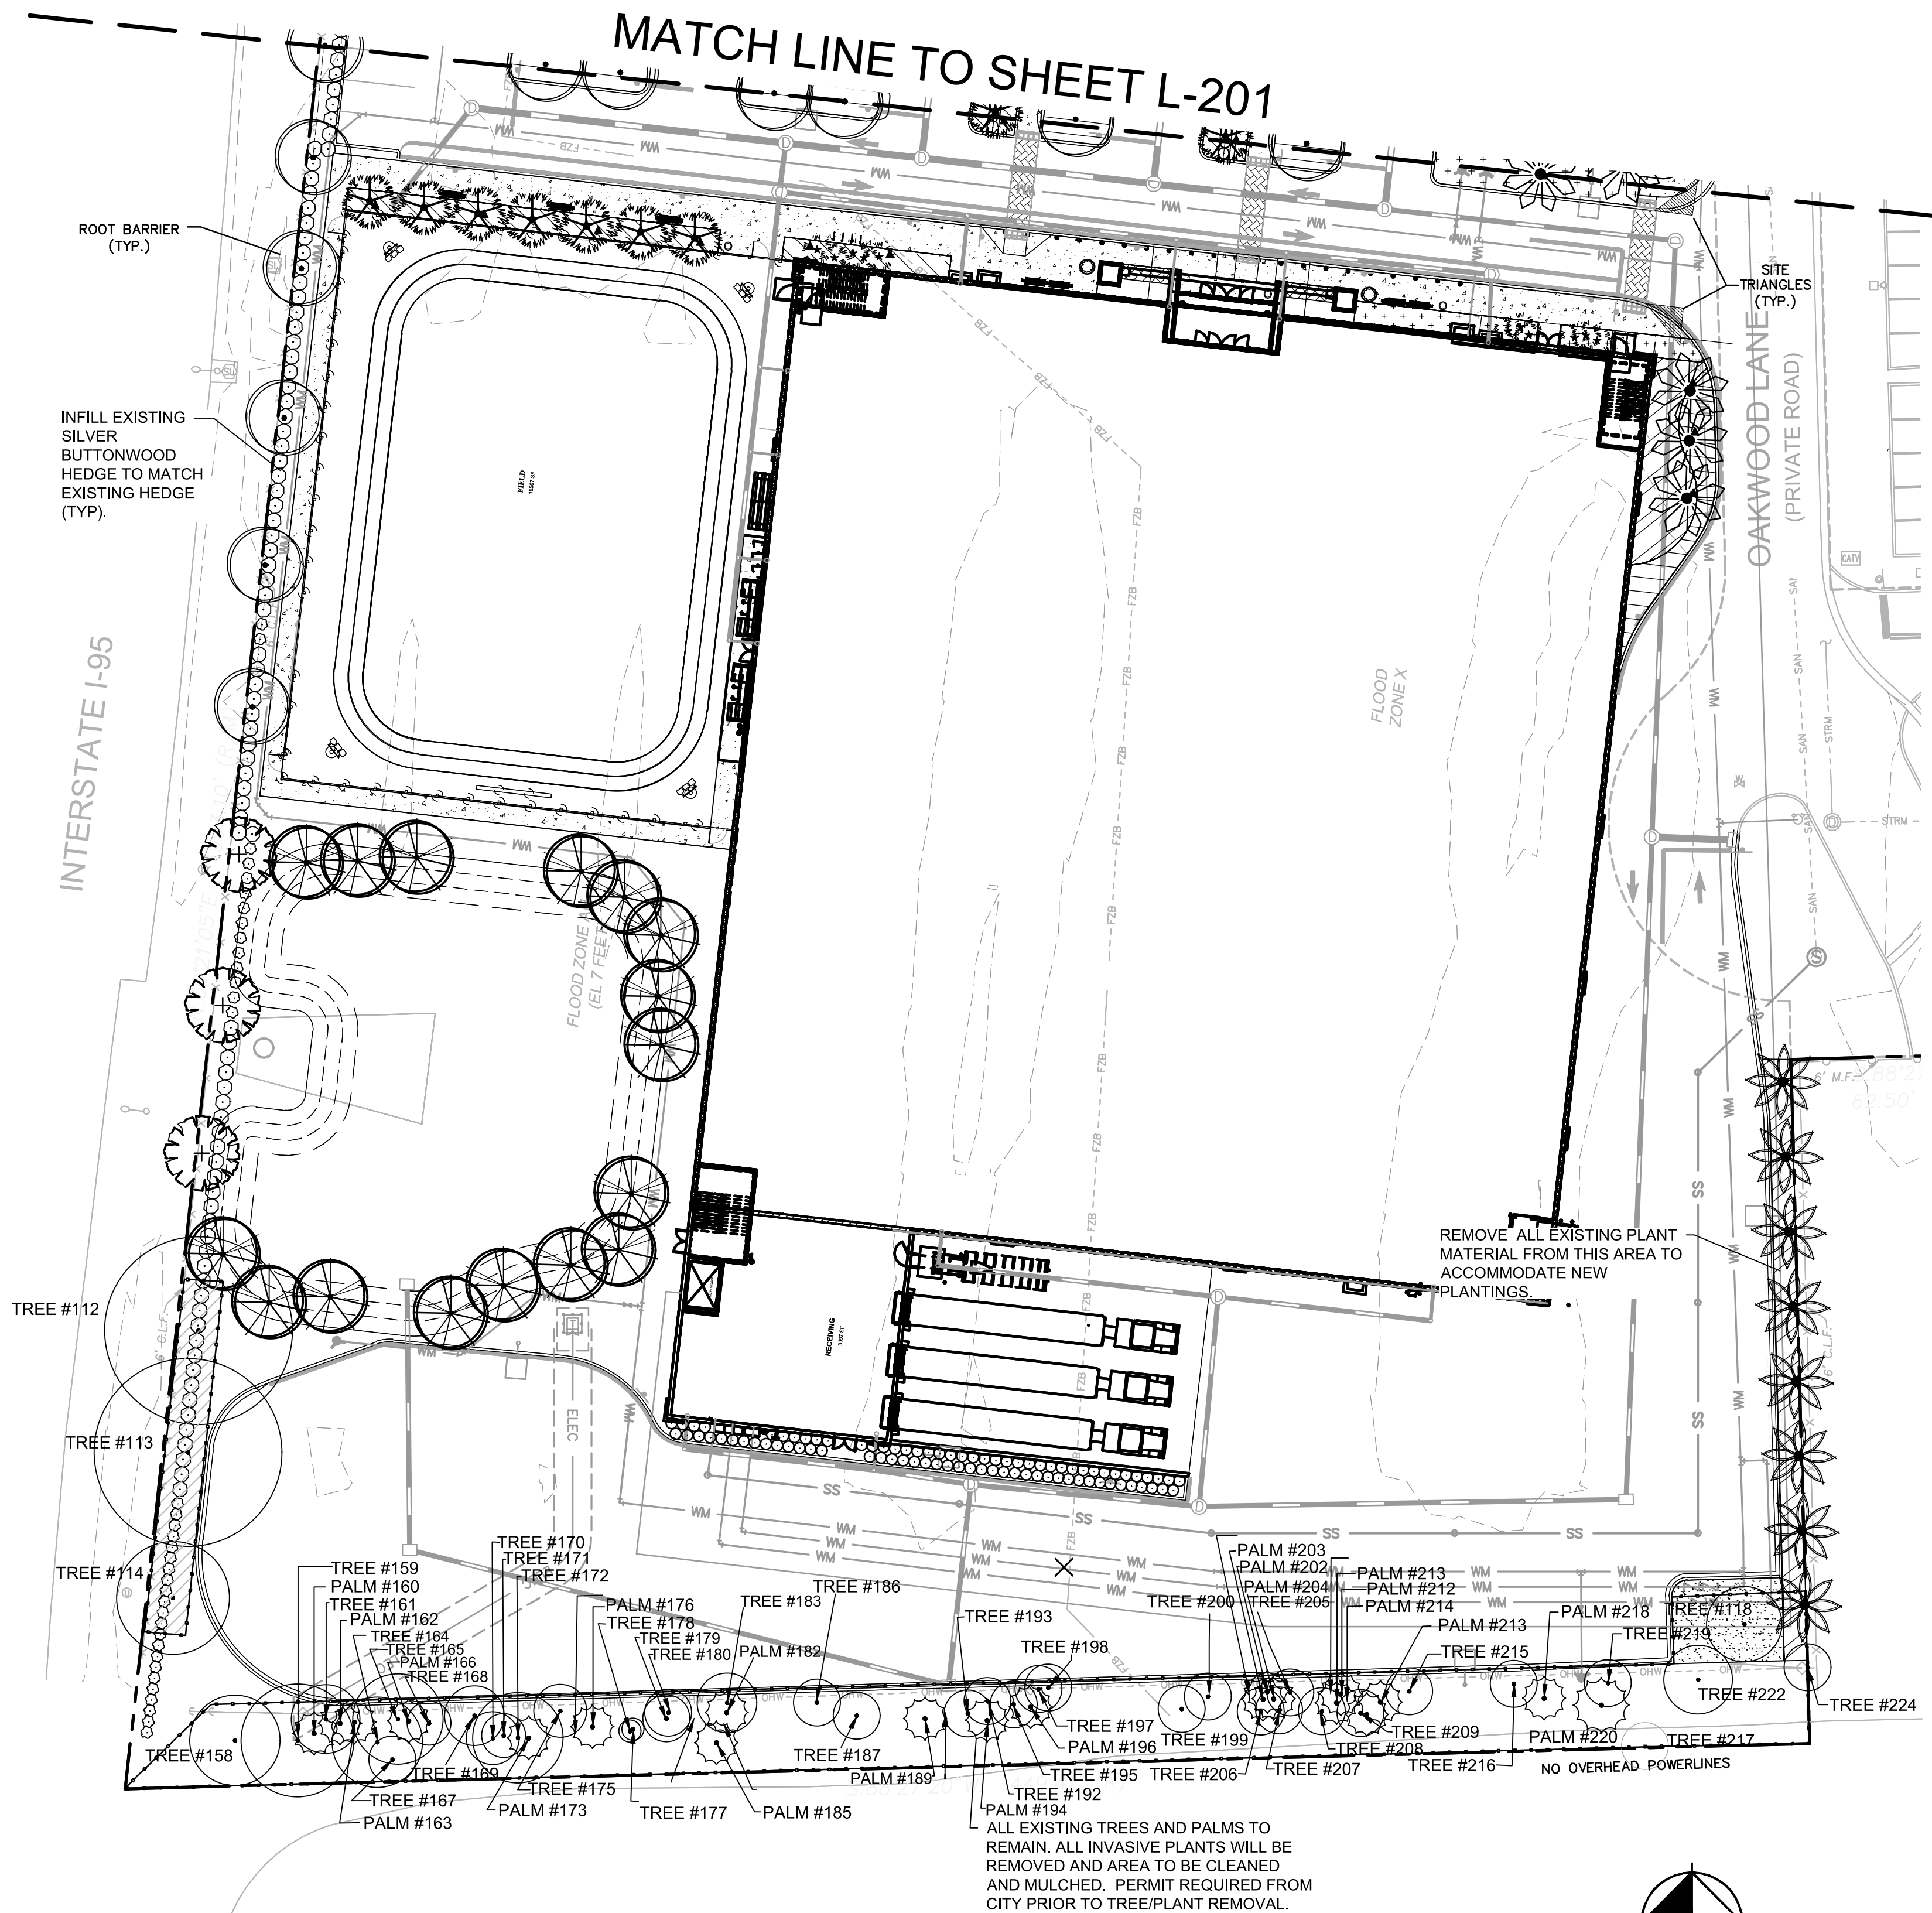

PLANT SCHEDULE


SYMBOL	CODE	QTY	COMMON NAME	BOTANICAL NAME	CONTAINER	DBH	HT	NATIVE	WATER USE
TREES									
	CO	35	SATINLEAF	CHRYSOHYLLUM OLIVIFORME	F.G.	3" DBH MIN.	12' HT MIN. X 5' SPR	YES	LOW
	CD	15	PIGEON PLUM	COCCOLOBA DIVERSIFOLIA	F.G.	2" DBH MIN.	12' HT MIN. X 5' SPR	YES	LOW
	IA	5	EAST PALATKA HOLLY	ILEX X ATTENUATA 'EAST PALATKA'	F.G.	2" DBH MIN.	12' HT MIN. X 5' SPR	YES	MODERATE
	IE	13	EAST PALATKA HOLLY	ILEX X ATTENUATA 'EAST PALATKA'	F.G.	3" DBH MIN.	14' HT X 6' SPR	YES	MODERATE
	QV	3	SOUTHERN LIVE OAK	QUERCUS VIRGINIANA	F.G.	3" DBH MIN.	14' HT X 6' SPR	YES	LOW
	TD	16	BALD CYPRESS	TAXODIUM DISTICHUM	F.G.	5.5" DBH MIN.	14-16' HT. MIN., 8' CLEAR TRUNK	YES	NO
PALM TREE									
	AA	21	ALEXANDRA PALM	ARCHONTOPHOENIX ALEXANDRAE	F.G.		8' GW	NO	MODERATE
	PR	11	PYGMY DATE PALM	PHOENIX ROEBELENI	F.G.		8' GW	NO	MODERATE
	RR	10	ROYAL PALM	ROYSTONEA REGIA	F.G.		10' GW	YES	LOW
	VM	8	MONTGOMERY PALM	VEITCHIA MONTGOMERYANA	F.G.		8' GW	NO	LOW
STREET TREES									
	RO	3	ROYAL PALM	ROYSTONEA REGIA	F.G.		10' GW	YES	LOW
	VE	5	MONTGOMERY PALM	VEITCHIA MONTGOMERYANA	F.G.		10' GW	NO	LOW
SYMBOL	CODE	QTY	COMMON NAME	BOTANICAL NAME	CONT	SPACING	SIZE	NATIVE	WATER USE
SHRUBS									
	CB	184	SILVER BUTTONWOOD MAINTAINED AT 36" HT., FULL TO BASE	CONOCARPUS ERECTUS 'SERICEUS'	CONT.	30" O.C.	30"X30"	YES	
	ES	163	TO REMAIN	EXISTING SHRUB	-				
SHRUB AREAS									
	HC	738	DWARF FIREBUSH	HAMELIA PATENS 'COMPACTA'	CONT.	24" O.C.	18"X18"	YES	LOW
	JJ	612	WAX JASMINE	JASMINUM VOLUBILE	CONT.	30" O.C.	20" FULL	NO	MODERATE
	RA	897	WHITE INDIAN HAWTHORN	RHAPHIOLEPIS INDICA 'ALBA'	CONT.	24" O.C.	18"X18"	NO	MODERATE
SYMBOL	CODE	QTY	COMMON NAME	BOTANICAL NAME	CONT	O.C.	SIZE	NATIVE	WATER USE
GROUND COVERS									
	AD	48	FOXTAIL FERN	ASPARAGUS DENSIFLORUS 'MYERS'	CONT.	20" O.C.	18"X18"	NO	
	LM	2,243	LIRIOPE	LIRIOPE MUSCARI 'EVERGREEN GIANT'	CONT.	12" O.C.	12" HT. MIN.	NO	
	TK	1,601	DWARF MINIMA ASIATIC JASMINE	TRACHELOSPERMUM ASIATICUM 'KENROKUEN'	CONT.	15" O.C.	10" FULL	YES	LOW
SOD/SEED									
	SOD	5,227 SF	FLORATAM ST. AUGUSTINE SOD	STENOTAPHRUM SECUNDATUM 'FLORATAM'	SOD		SOD	NO	

LANDSCAPE REQUIREMENTS		
PLANT MATERIAL REQUIREMENTS (PER ARTICLE 9.5.E)		
PLANT MATERIAL	REQUIRED	PROPOSED
	75% OF PLANT MATERIAL IS IDENTIFIED IN HOLLYWOOD TECHNICAL LANDSCAPE MANUAL	MET
NATIVE SPECIES	60% OF TREES (81 X 60%=48 REQUIRED) 50% OF SHRUBS (X 50%=1041 REQUIRED)	81 1065
PARKING LOT REQUIREMENTS (PER ARTICLE 9.2.C.1)		
ISLANDS	REQUIRED	PROPOSED
TREES	1 TREE OR PALM PER ISLAND ISLAND = 24 PARKING ISLANDS	51
WIDTH	7' MIN	7' MIN
STREET TREES (PER PD DEVELOPMENT STANDARDS SEC 8.4) 312 LF		
	1 CANOPY TREE PER 50 LF=7 TREE REQUIRED (312 LF/50)	PROPOSED 13 TOTAL (8 EXISTING + 5 PROPOSED) = 4 TREES 3 ROYAL PALMS = 3 TREES 7 TOTAL TREES
BUFFER REQUIREMENTS (PER PD)		
	NONE	
SITE REQUIREMENTS (PER SECTION 6.8.8)		
SITE	REQUIRED	PROPOSED
LANDSCAPE AREAS	ALL PERVIOUS AREAS SHALL BE LANDSCAPED OR COVERED WITH LIVING GROUND COVER OR SOD ALL LANDSCAPED AREA WILL RECEIVE 100% IRRIGATION 40% OF TOTAL SITE MUST BE LANDSCAPED OPEN SPACE = 29117.5F (67,983 X 40%)	67,983 SF 20 PROPOSED + 47 EXISTING 9 PROPOSED PALMS = 3 TREES 7 ROYAL PALMS = 7 TREES
TREES	1 TREE/ 1,000 SF = (67,083 SF/1000SF) = 67 TREES	
PALMS	3 PALMS = 1 CANOPY TREE 15 SPECIMEN PALM (ROYAL PALM) = 1 CANOPY TREE	
		TOTAL TREES: (30 PROPOSED + 47 EXISTING) = 77 TOTAL TREES TOTAL SHRUBS: 1644 PROPOSED

TREE MITIGATION CALCULATIONS	
TOTAL MITIGATION REQUIRED (DBH IN INCHES)	2,039
TOTAL DBH PROVIDED (IN INCHES)	247
TOTAL PALMS REMOVED (EA.)	38
TOTAL PALMS PROVIDED (EA.)	38

TREE TRUST FUND CALCULATIONS	
TOTAL MITIGATION REQUIRED (DBH IN INCHES)	2,039
TOTAL DBH PROVIDED	247
TOTAL DBH DELTA	1,792
TOTAL TREE REPLACEMENT TREE DEFICIT (12 FT' HT. x 2" DBH):	896
TOTAL TREE TRUST FUND CONTRIBUTION (TREE DEFICIT x \$390)	\$ 313,600.00

THIS ITEM HAS BEEN DIGITALLY SIGNED AND SEALED BY BENJAMIN V. JOHNSON, PLA ON THE DATE ADJACENT TO THE SIGNATURE. PRINTED COPIES OF THIS DOCUMENT ARE NOT CONSIDERED SIGNED AND SEALED AND THE SIGNATURE MUST BE VERIFIED ON ANY ELECTRONIC COPIES.

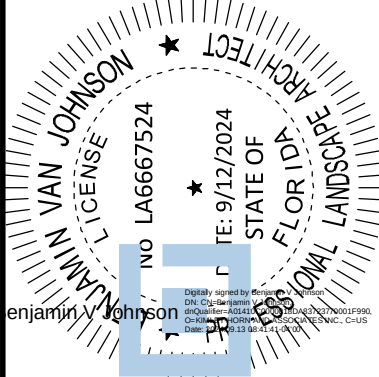

KHA PROJECT	043326005
DATE	9/3/2024
SCALE	AS SHOWN
DESIGNED BY	NF
DRAWN BY	NF
CHECKED BY	KD

LANDSCAPE PLAN

OAKWOOD SOUTH
RETAIL SHOPPING
CENTER

SHEET NUMBER
L-200

CITY OF HOLLYWOOD

REVISIONS

DATE
BY


CALL 48 HOURS
BEFORE YOU DIG

IT'S THE LAW!
DIAL 811

Know what's below.
Call before you dig.

SUNSHINE STATE ONE CALL OF FLORIDA, INC.

This document, together with the concepts and designs presented herein, as an instrument of service, is intended only for the specific purpose and client for which it was prepared. Reuse of and improper reliance on this document without written authorization and adaptation by Kimley-Horn and Associates, Inc. shall be without liability to Kimley-Horn and Associates, Inc.

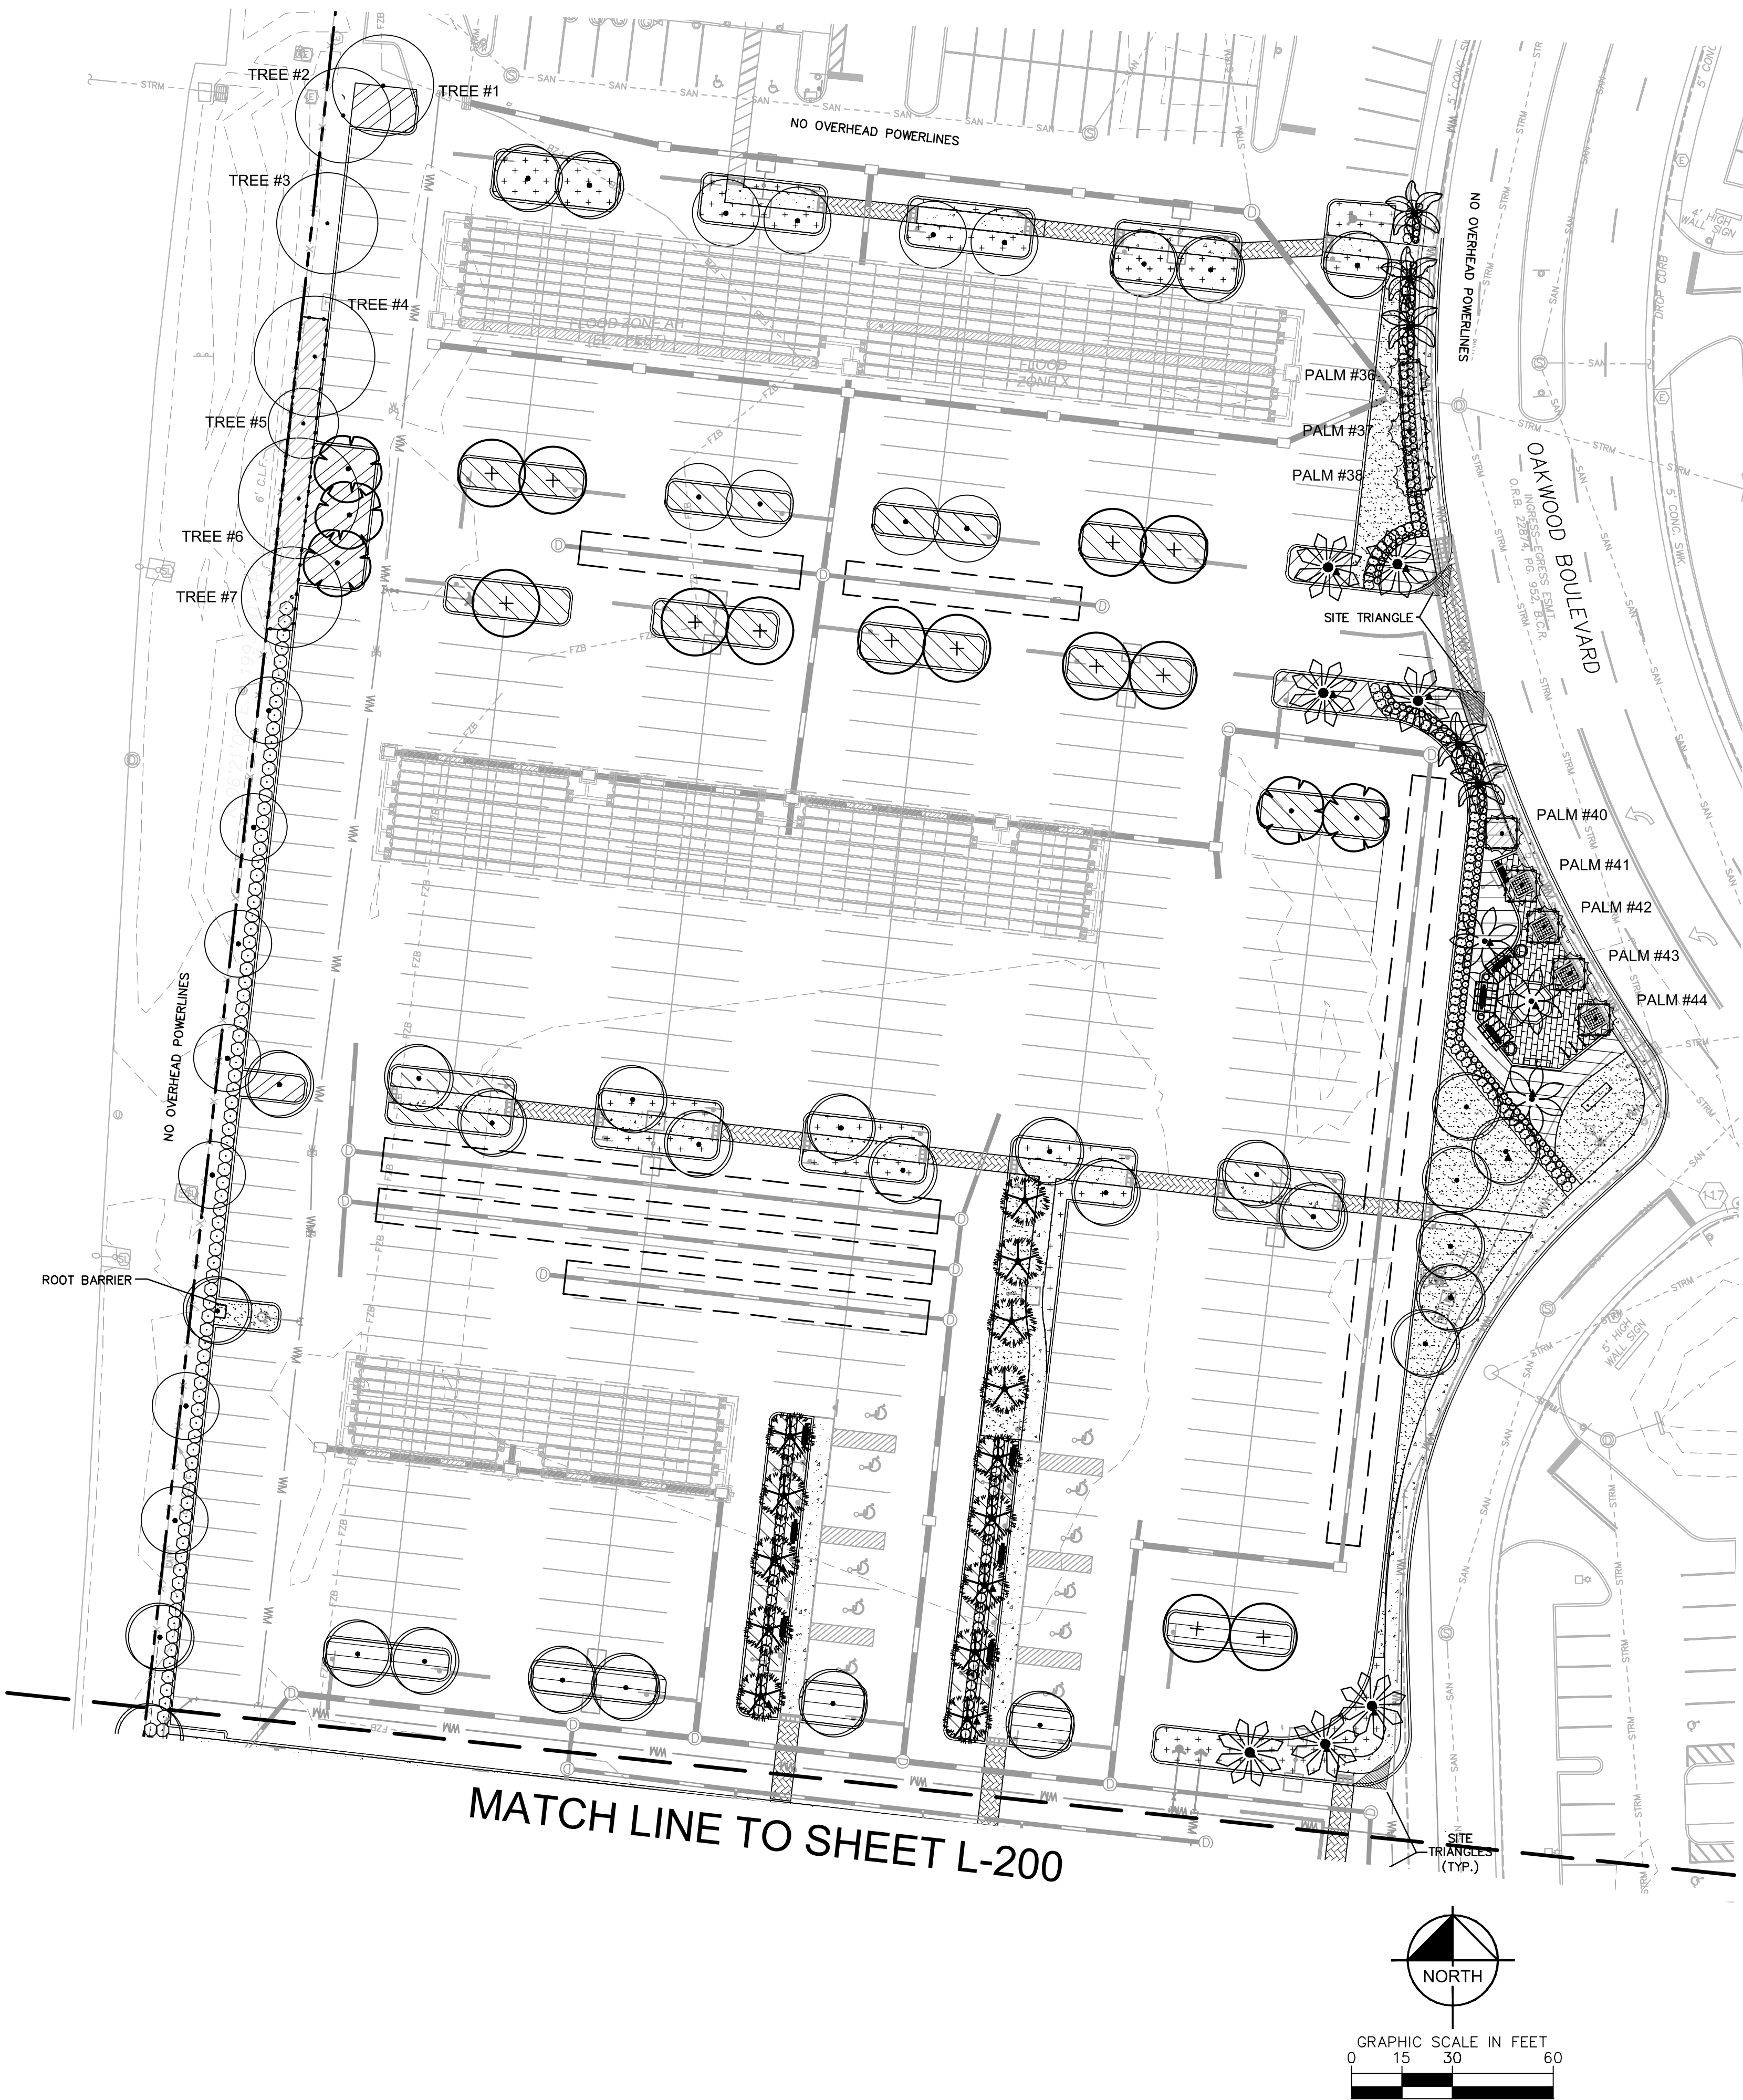

PLANT KEY

SYMBOL CODE COMMON / BOTANICAL NAME

TREES

TD	BALD CYPRESS / TAXODIUM DISTICHUM
IA	EAST PALATKA HOLLY / ILEX X ATTENUATA 'EAST PALATKA'
IE	EAST PALATKA HOLLY / ILEX X ATTENUATA 'EAST PALATKA'
CD	PIGEON PLUM / COCCOLOBA DIVERSIFOLIA
CO	SATINLEAF / CHRYSOPHYLLUM OLIVIFORME
QV	SOUTHERN LIVE OAK / QUERCUS VIRGINIANA

PALM TREE

AA	ALEXANDRA PALM / ARCHONTOPHOENIX ALEXANDRAE
VM	MONTGOMERY PALM / VEITCHIA MONTGOMERYANA
PR	PYGM DATE PALM / PHOENIX ROEBELENI
RR	ROYAL PALM / ROYSTONEA REGIA

STREET TREES

VE	MONTGOMERY PALM / VEITCHIA MONTGOMERYANA
RO	ROYAL PALM / ROYSTONEA REGIA

SHRUBS

ES	EXISTING SHRUB
CB	SILVER BUTTWOOD / CONOCARPUS ERECTUS 'SERICEUS'

SHRUB AREAS

HC	DWARF FIREBUSH / HAMAMELIA PATENS 'COMPACTA'
JJ	WAX JASMINE / JASMINUM VOLUBILE
RA	WHITE INDIAN HAWTHORN / RHAPHIOLEPIS INDICA 'ALBA'

GROUND COVERS


TK	DWARF MINIMA ASIATIC JASMINE / TRACHELOSPERMUM ASIATICUM 'KENROKUN'
AD	FOXTAIL FERN / ASPARAGUS DENSIFLORUS 'MYERS'
LM	LIRIOPE / LIRIOPE MUSCARI 'EVERGREEN GIANT'

SOD/SEED


SOD	FLORATAM ST. AUGUSTINE SOD / STENOTAPHRUM SECUNDATUM 'FLORATAM'
-----	---

LANDSCAPE NOTES:


1. PLANT MATERIAL SHALL BE HEALTHY, VIGOROUS AND FREE FROM DISEASES, INSECTS EGGS, AND SHALL HAVE A HEALTHY NORMAL ROOT SYSTEM, FURNISHED IN THE MINIMUM SIZES INDICATED IN THE SCHEDULE. NO SUBSTITUTIONS SHALL BE PERMITTED WITHOUT A WRITTEN PERMISSION FROM THE CITY OF HOLLYWOOD.
2. ALL PLANTS SHALL BE FLORIDA GRADE NO. 1 OR BETTER
3. ALL PLANTING SOIL AND TOP SOIL SHALL CONSIST OF 50% MUCK, 70% SAND, AND SHALL BE FREE OF HEAVY CLAY, COARSE SAND, ROCKS LARGER THAN 2", LUMPS, STICKS OR ANY OTHER DEBRIS.
4. FERTILIZER SHALL BE 12-12-12, 50% ORGANIC OR SLOW RELEASE NITROGEN.
5. TERRA-CONE OR APPROVED EQUIV. BE PROVIDED ACCORDING TO MANUFACTURER'S RECOMMENDATION.
6. ALL PLANT MATERIALS EXCEPT TREES SHALL BE GUARANTEED FOR 180 DAYS AFTER THE COMPLETED PROJECTS IS ACCEPTED BY THE CITY. TREES SHALL BE GUARANTEED FOR ONE (1) YEAR.
7. CONTRACTOR SHALL CONFIRM PLANT QUANTITIES PRIOR TO BIDDING.
8. CONTRACTOR IS RESPONSIBLE FOR MAINTENANCE OF LANDSCAPE AREA AND PLANTS FOR 90 DAYS STARTING ON THE DATE OF SUBSTANTIAL COMPLETION.
9. MULCH SHALL BE EUCALYPTUS GRADE A OR BETTER, USE OF CYPRESS BARK MULCH IS PROHIBITED IN THE PUBLIC RIGHT-OF-WAY.
10. THE ESTABLISHMENT PERIOD SHALL BEGIN AT THE TIME OF ACCEPTANCE OF INSTALLATION OF PLANTING AND IRRIGATION, AND EXTEND FOR 90 DAYS PAST THAT DATE, AND SHALL INCLUDE THE FOLLOWING ACTIVITIES:
 - a. SUPPLY WATER IN SUFFICIENT AMOUNTS REQUIRED TO INSURE ESTABLISHMENT AND GOOD GROWTH FOLLOWING INDUSTRY STANDARDS. WATERING SCHEDULE MAY BE INTERRUPTED DURING PERIODS OF HEAVY RAINFALL (0.50" OR MORE PER DAY).
 - b. STRAIGHTEN TREES AND PALMS AS REQUIRED (INCLUDING RE-GUYNING AND RE-STAKING AS REQUIRED).
 - c. WEEDING IS REQUIRED.
 - d. MOWING EVERY 21 DAYS.
 - e. MAINTAIN AND REPAIR IRRIGATION SYSTEM AS REQUIRED.
 - f. INSECT AND DISEASE CONTROL AS REQUIRED.
 - g. REMOVE STAKES AND GUYS AT THE END OF THE MAINTENANCE PERIOD.
11. ALL SOD AND LANDSCAPE SHALL RECEIVE 100% COVERAGE FROM AN AUTOMATIC IRRIGATION SYSTEM USING AN APPROVED WATER SOURCE.
12. IRRIGATION SYSTEM SHALL ALSO BE EQUIPPED WITH RAIN SENSOR.
13. ALL TREES AND PALMS SHALL BE PLANTED AT LEAST FIVE (5) FEET AWAY FROM ANY UNDERGROUND UTILITY LINE.
14. ALL TREES AND PALMS SHALL BE PLANTED AT LEAST SEVEN AND A HALF (7.5) FEET AWAY FROM ANY FIRE HYDRANT.
15. ANY SPECIES THAT ARE LISTED AS CATEGORY I AND II SPECIES ON THE MOST CURRENT 'FLORIDA EXOTIC PEST PLANT COUNCIL LIST ARE PROHIBITED TO BE PLANTED ON PRIVATE PROPERTY OR ON CITY PROPERTY INCLUDING ROW AND SWALE AREAS - SEC. 106.01.
16. A MAXIMUM OF 50% OF THE REQUIRED TREES MAY BE OF A PALM SPECIES. SEC.3.5
17. STREET TREES: AT TIME OF INSTALLATION, SHADE TREES MUST BE A MINIMUM OF 12' OVERALL HEIGHT, APPROVED PALM TREES ARE TO HAVE A MINIMUM OF 8' CLEAR TRUNK (CT).
18. IDENTIFY ALL TREES TO REMAIN ON SITE WITH THE CORRESPONDING TREE PROTECTION AND PROTECTION BARRIERS. PROVIDE A TREE PROTECTION BARRIER DETAIL ON PLAN AS APPROVED BY CITY OF HOLLYWOOD. OUTLINE THE TREE PROTECTION BARRIER TO SCALE AROUND EACH TREE/PALM TO REMAIN ON PLAN.
19. PROVIDE A RECENT TREE SURVEY TO SHOW THE EXISTING TREES ON SITE AND IN SWALE AREAS.
20. SHOW ALL TREES ON SITE TO SCALE. SUPERIMPOSE EXISTING TREES ON PROPOSED SITE PLAN. THE TREE LEGEND MUST INCLUDE THE TREE NUMBER, COMMON NAME, BOTANICAL NAME, DBH, OVERALL HEIGHT, SPREAD, CONDITION, AND DISPOSITION (TO REMAIN, TO BE RELOCATED, TO BE REMOVED). SHOW ALL CANOPY INCLUDING CROWNS OF TREES FROM ADJACENT LOT LOCATED WITHIN 10' FROM PROPERTY LINE.
21. PROVIDE SIGHT TRIANGLES ON PLANS AT INTERSECTION OF DRIVEWAY AND PROPERTY LINE.
22. NATIVE PLANT REQUIREMENTS: 60% TREES, 50% SHRUBS - SEC. 3.4.
23. LABEL ALL SIDES OF PROPERTY WHETHER THERE ARE 'EXISTING OVERHEAD POWERLINES' OR 'NO OVERHEAD POWERLINES'. PROVIDE FPL APPROVED TREES FOR PLANTING UNDER POWERLINES.
24. TREE REMOVAL DISCLAIMER: WRITE THIS STATEMENT ON ALL SHEETS FOR EXISTING/PROPOSED LANDSCAPE: 'TREES AND PALMS SHALL NOT BE REMOVED WITHOUT FIRST OBTAINING AN APPROVED TREE REMOVAL PERMIT FROM THE CITY OF HOLLYWOOD.'
25. ABOVE GROUND EQUIPMENT: WHERE REQUIRED FOR SCREENING PURPOSES, HEDGE SHALL BE PLANTED AT EQUIPMENT HEIGHT FOR VISUAL SCREENING.
26. NO TREE REMOVALS ALLOWED WITHOUT AN APPROVED CITY OF HOLLYWOOD TREE REMOVAL PERMIT.
27. FOR BUILDING PERMITS: NO TREE REMOVAL OR PLANTING ALLOWED WITHOUT AN APPROVED SUB-PERMIT.
28. EQUIPMENT (DUMPSTERS, ELECTRICAL TRANSFORMERS, ETC., WITH THE EXCEPTION OF FIRE HYDRANTS) MUST BE SCREENED ON AT LEAST THREE SIDES BY LANDSCAPE MATERIAL A MINIMUM OF 30 INCHES TALL. LANDSCAPING MUST NOT INTERFERE WITH THE NORMAL OPERATION OF THE EQUIPMENT.
29. IF YOU ARE PLANNING A PROJECT ON YOUR PROPERTY THAT INVOLVES DIGGING, SUCH AS INSTALLING A MAILBOX, FENCES, PLANTING TREES, YOU ARE ENCOURAGED TO CALL 811 A FEW DAYS BEFORE YOU START TO MAKE SURE YOU DO IT SAFELY. UTILITY COMPANIES WILL MARK BURIED LINES SO THAT YOU CAN DIG SAFELY AROUND THEM. VISIT CALL811.COM FOR DETAILS.

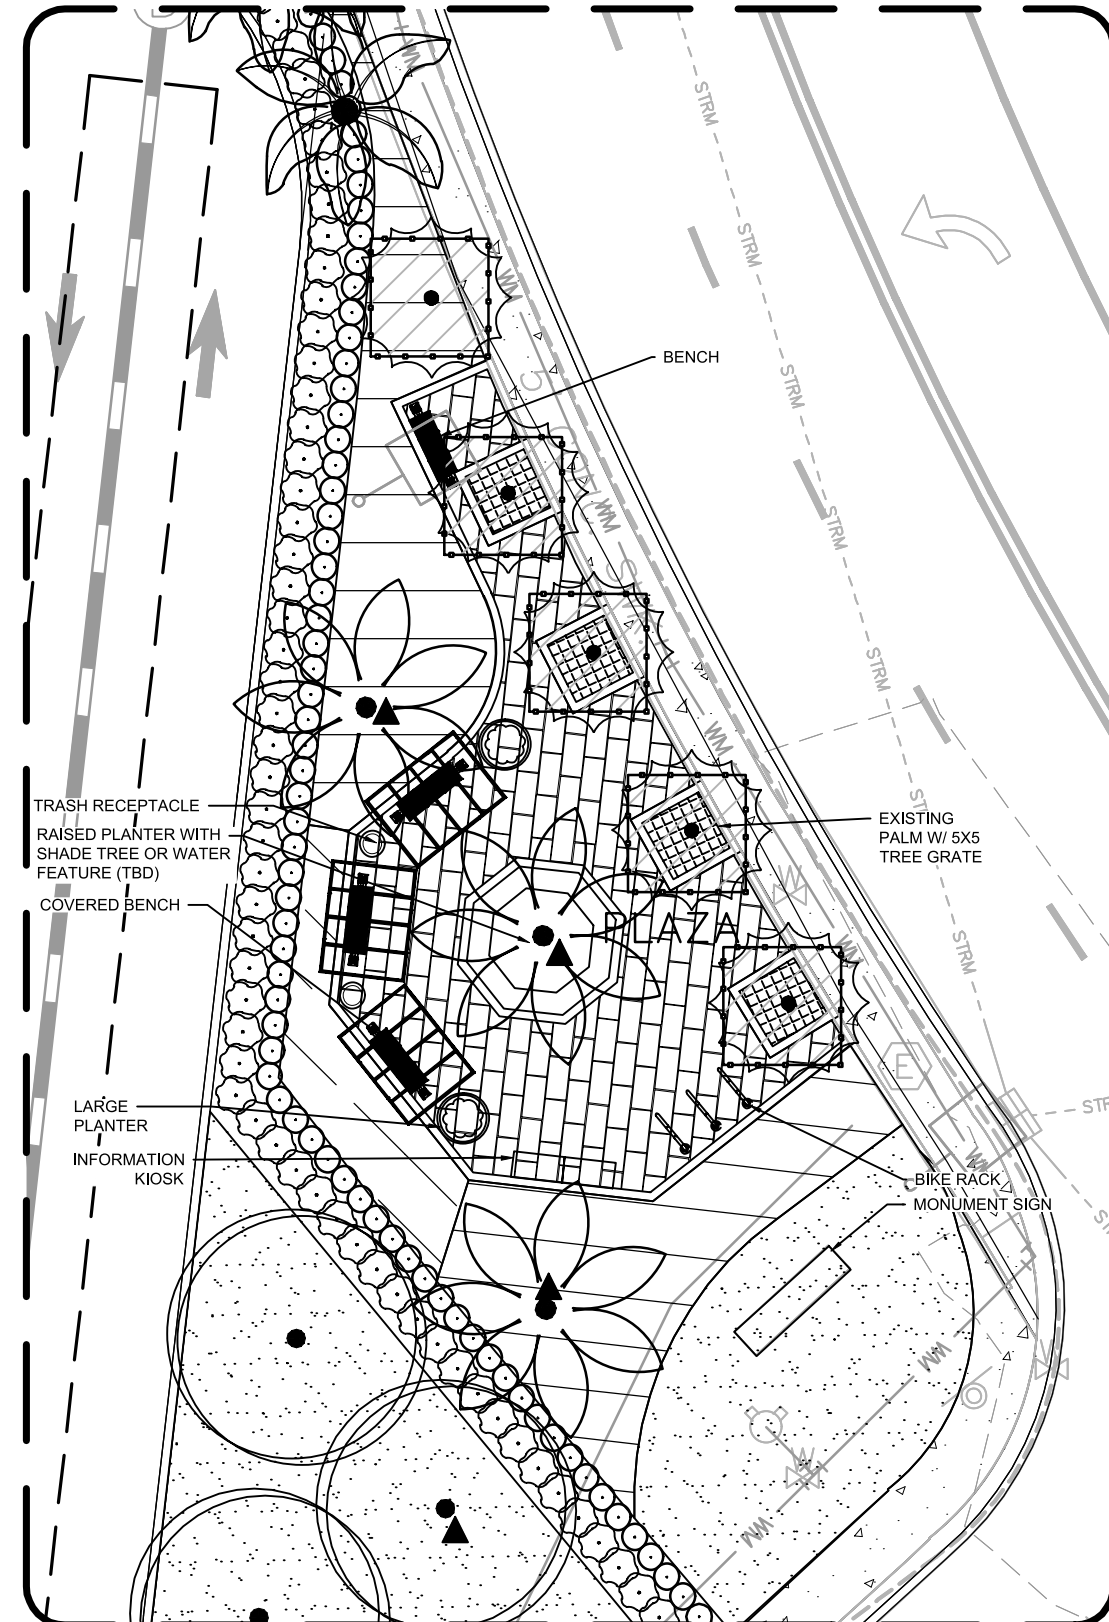

PLAN ENLARGEMENT

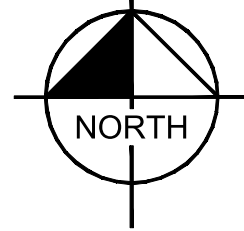

THIS ITEM HAS BEEN DIGITALLY SIGNED AND SEALED BY BENJAMIN V. JOHNSON, PLA ON THE DATE ADJACENT TO THE SIGNATURE. PRINTED COPIES OF THIS DOCUMENT ARE NOT CONSIDERED SIGNED AND SEALED AND THE SIGNATURE MUST BE VERIFIED ON ANY ELECTRONIC COPIES.

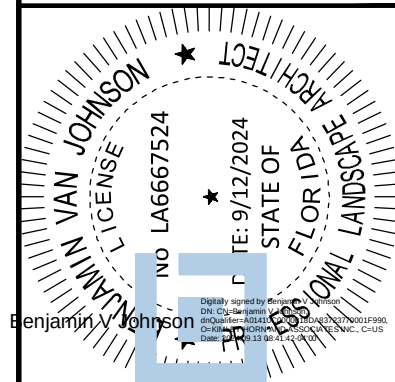

KHA PROJECT	043326005
DATE	9/3/2024
SCALE	AS SHOWN
DESIGNED BY	NF
DRAWN BY	NF
CHECKED BY	KD

LANDSCAPE PLAN

OAKWOOD SOUTH
RETAIL SHOPPING
CENTER

FL

CITY OF HOLLYWOOD

SHEET NUMBER

L-201

CALL 48 HOURS
BEFORE YOU DIG

IT'S THE LAW!
DIAL 811




SUNSHINE STATE ONE CALL OF FLORIDA, INC.

Kimley»Horn


445 24TH STREET, SUITE 200, VERO BEACH, FL 32960
PHONE: 772-794-4100
WWW.KIMLEY-HORN.COM REGISTRY NO. 35106

No.	REVISIONS	DATE	BY


This document, together with the concepts and designs presented herein, as an instrument of service, is intended only for the specific purpose and client for which it was prepared. Reuse of and improper reliance on this document without written authorization and assentation by Kimley-Horn and Associates, Inc. shall be without liability to Kimley-Horn and Associates, Inc.

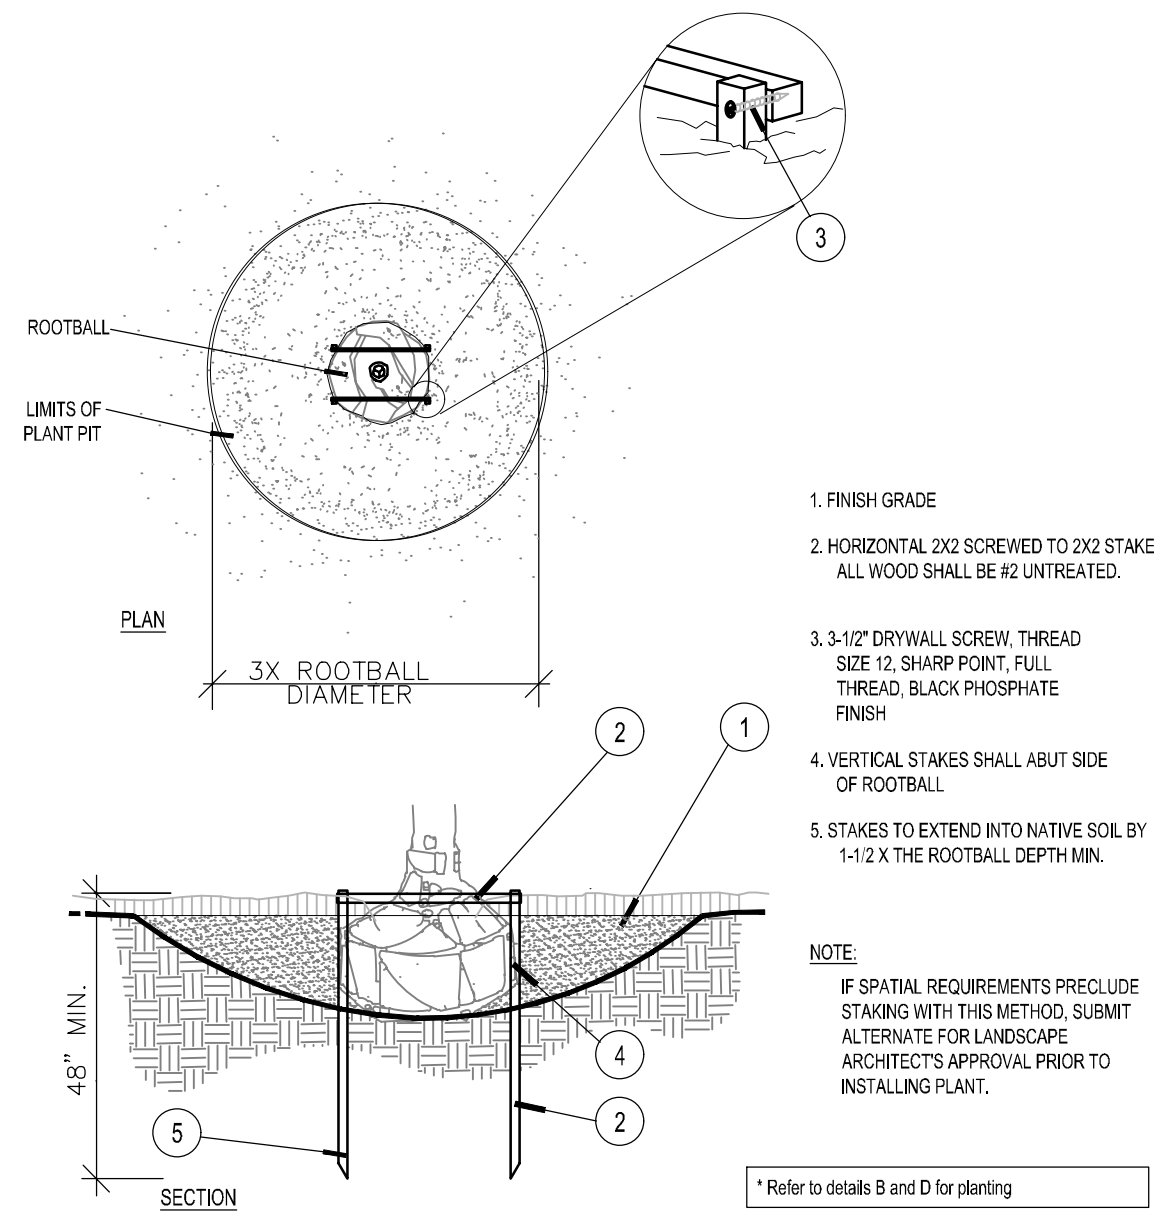


A Staking - up to 65 gal. or B&B to 3-1/2" Cal. NTS

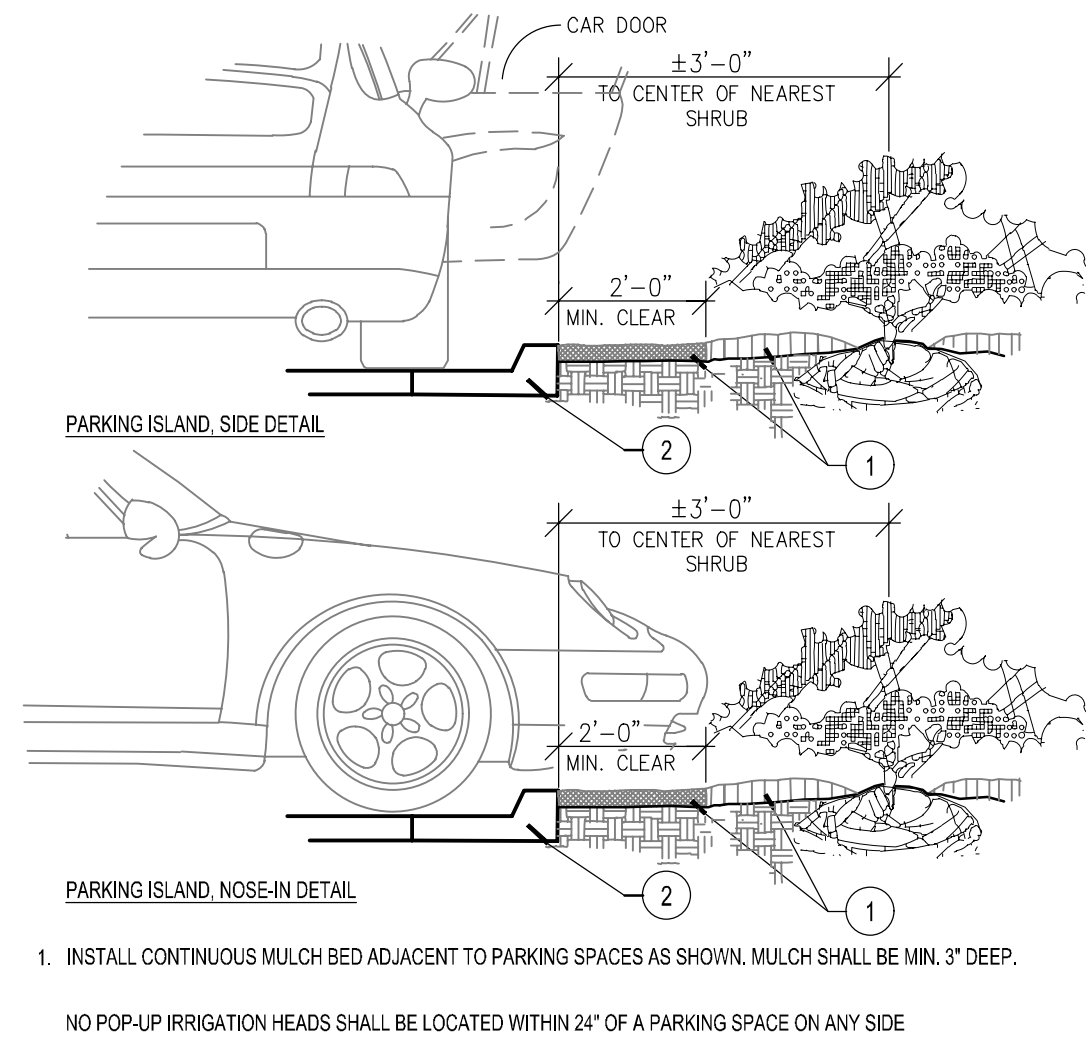


E Parking Space/Curb Planting NTS

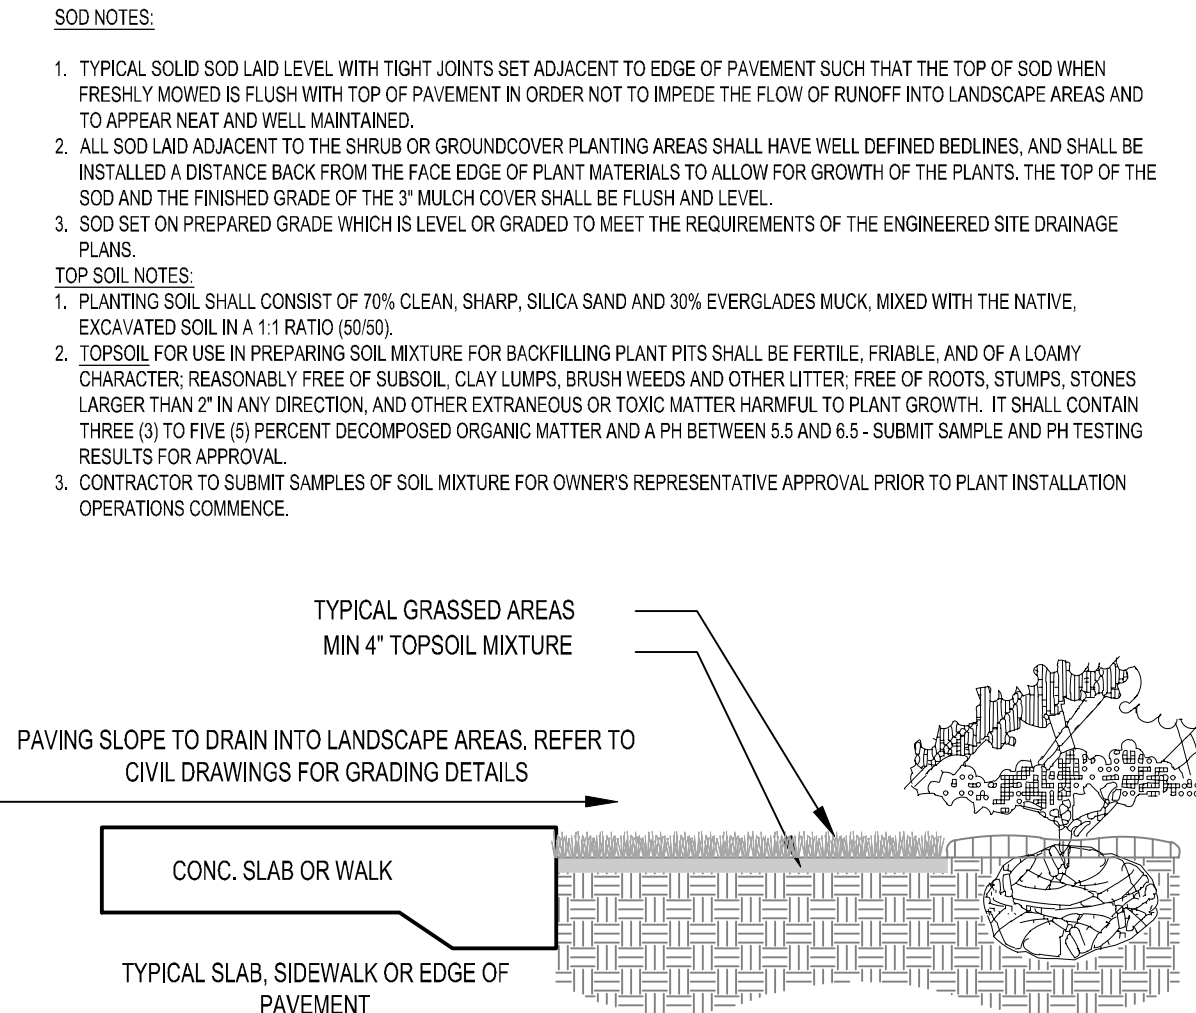


B SOD NTS

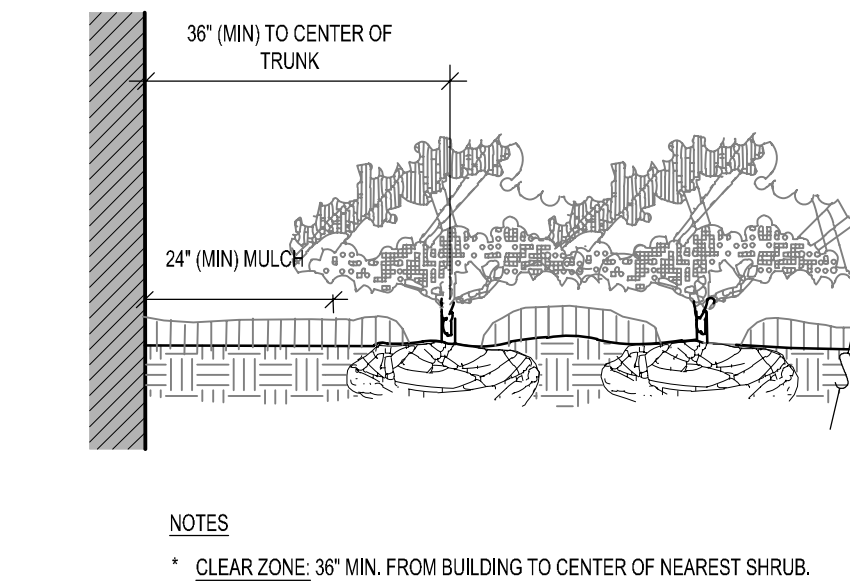


F Plantings Adjacent to Buildings NTS

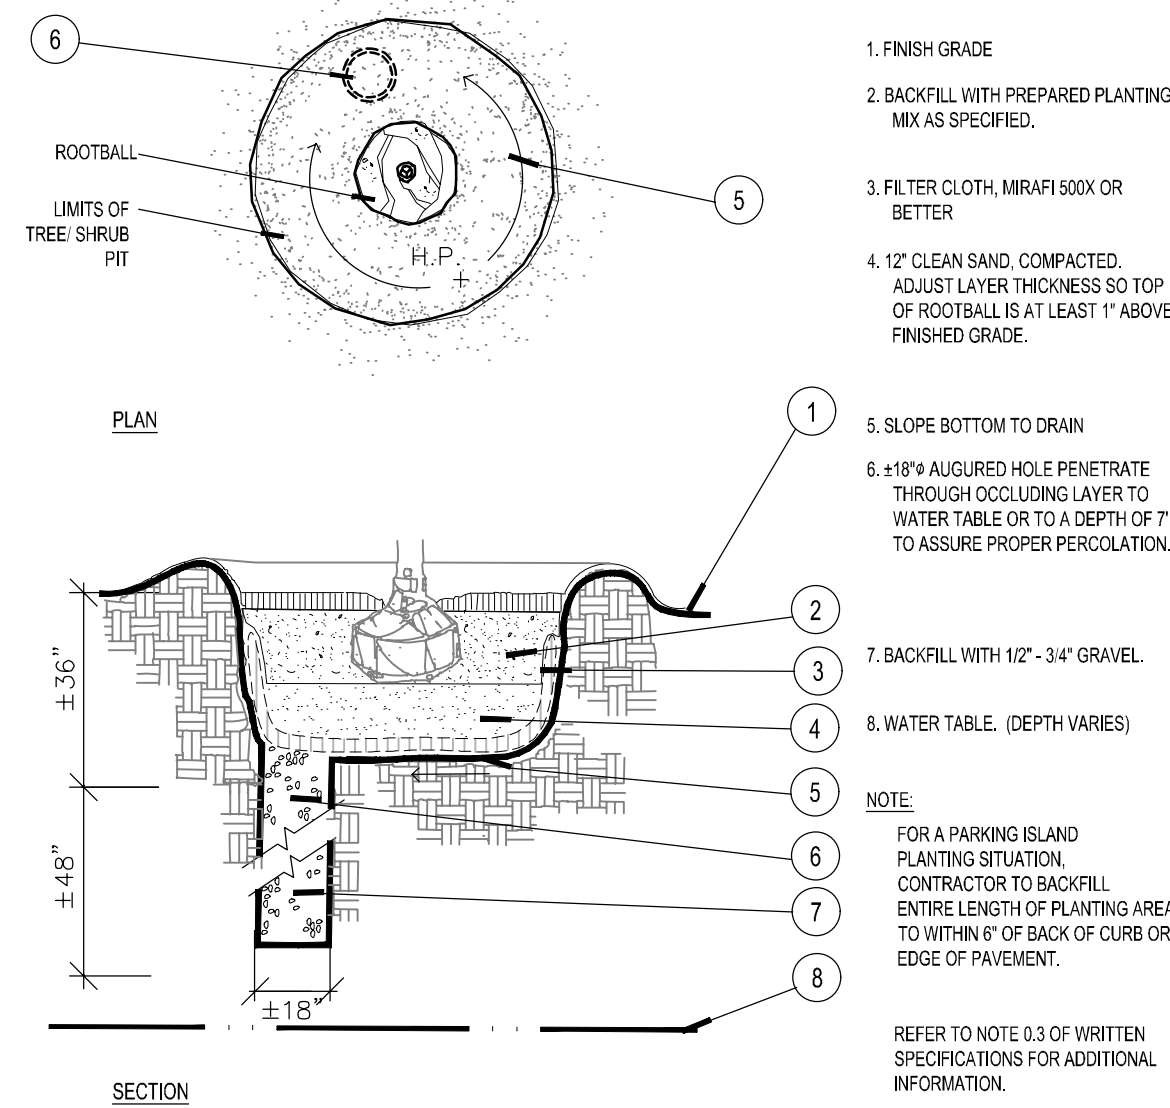


C Poor Drainage Condition NTS

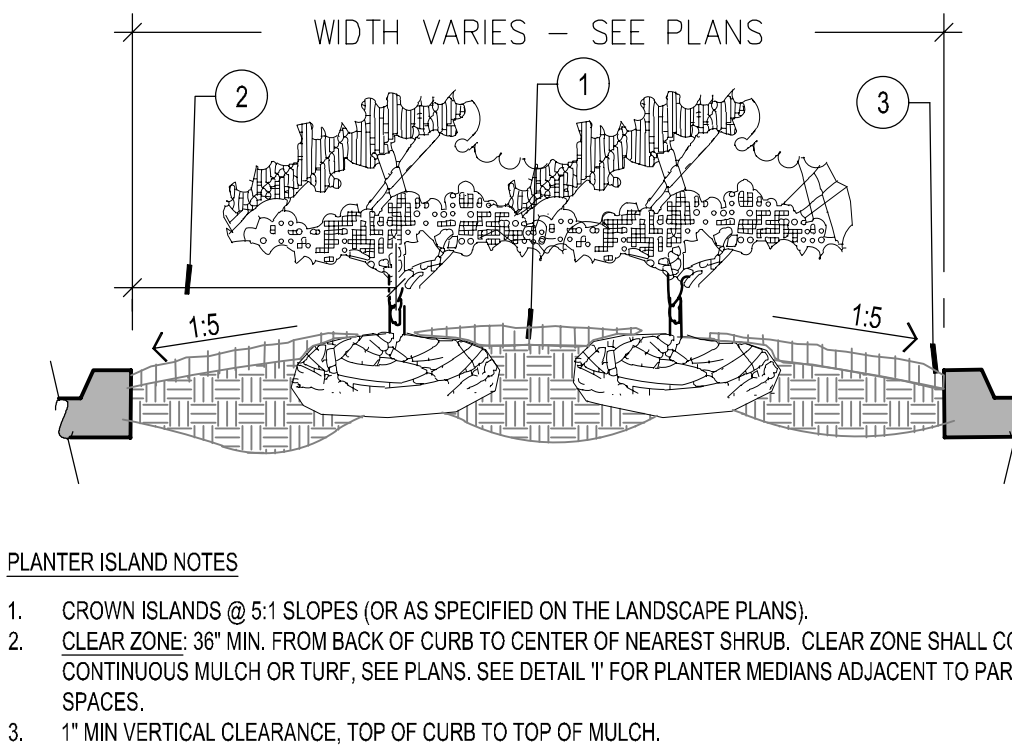

G Planted Parking Lot Islands / Medians NTS

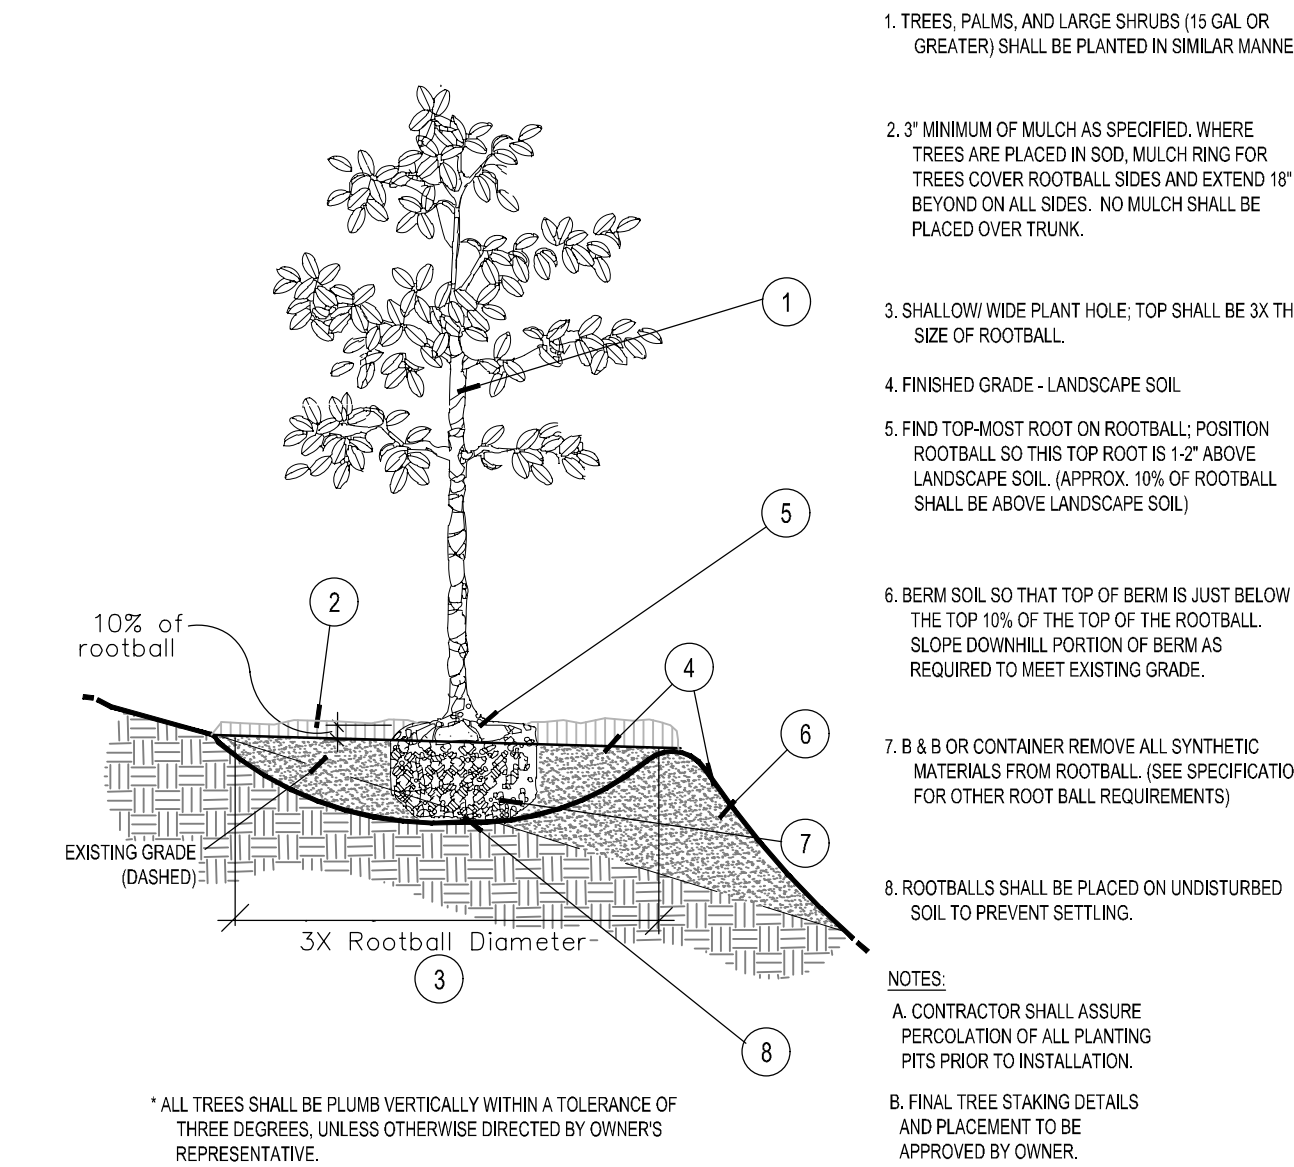

D Planting on a Slope NTS

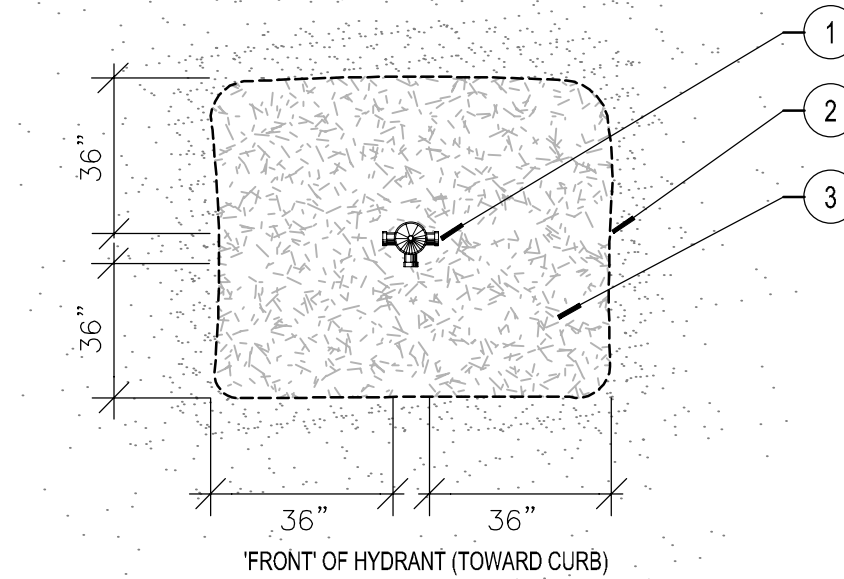


M Fire Hydrant Clear Zone NTS

THIS ITEM HAS BEEN DIGITALLY SIGNED AND SEALED BY BENJAMIN V. JOHNSON, P.L.A. ON THE DATE ADJACENT TO THE SIGNATURE. PRINTED COPIES OF THIS DOCUMENT ARE NOT CONSIDERED SIGNED AND SEALED AND THE SIGNATURE MUST BE VERIFIED ON ANY ELECTRONIC COPIES.

Kimley»Horn

445 24TH STREET, SUITE 200, VERO BEACH, FL 32960
PHONE: 772-794-4100
WWW.KIMLEY-HORN.COM REGISTRY NO. 35106

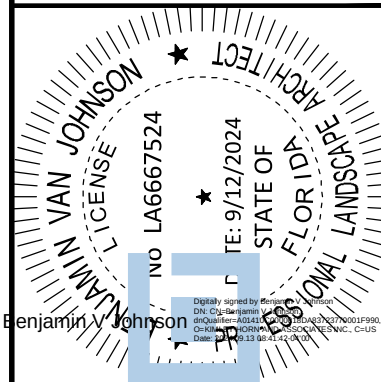

KHA PROJECT	DATE	SCALE	DESIGNED BY	DRAWN BY	CHECKED BY
043326005	9/3/2024	AS SHOWN	NF	NF	KD

LANDSCAPE DETAILS

OAKWOOD SOUTH
RETAIL SHOPPING
CENTER

FL

CITY OF HOLLYWOOD

SHEET NUMBER
L-202

CALL 48 HOURS
BEFORE YOU DIG



IT'S THE LAW!
DIAL 811


Know what's below.
Call before you dig.

SUNSHINE STATE ONE CALL OF FLORIDA, INC.

This document, together with the concepts and designs presented herein, is intended only for the specific purpose and client for which it was prepared. Reuse of and improper reliance on this document without written authorization and adaptation by Kimley-Horn and Associates, Inc. shall be without liability to Kimley-Horn and Associates, Inc.

DRAWING NO.:
L-01

TYPICAL PALM STAKING DETAIL

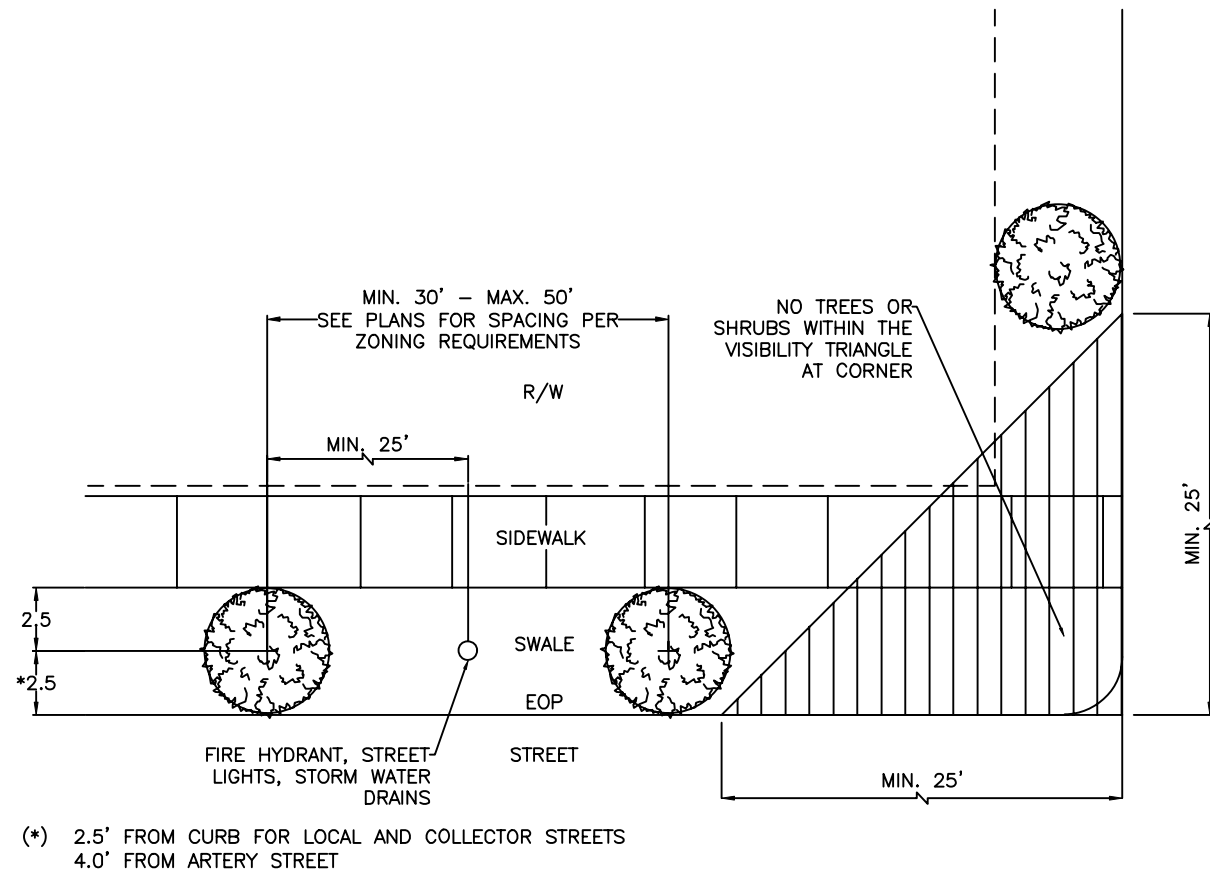


- NOTES:
- PER CITY OF HOLLYWOOD'S LANDSCAPE MANUAL SEC. 4.3, SWALE AREA TREES CANNOT BE:
1. WITHIN 25 FEET FROM INTERSECTING STREET
 2. WITHIN 25 FEET FROM PUBLIC STORM DRAIN, STREET LIGHT OR FIRE HYDRANT
 3. WITHIN 10 FEET OF AN INTERSECTING ALLEY
 4. WITHIN 25 FEET OF A COMMERCIAL OR INDUSTRIAL DRIVEWAY

DRAWING NO.:
L-06

STREET TREE LOCATION DETAIL

DRAWING NO.:
L-02

SHRUB AND GROUNDCOVER DETAIL

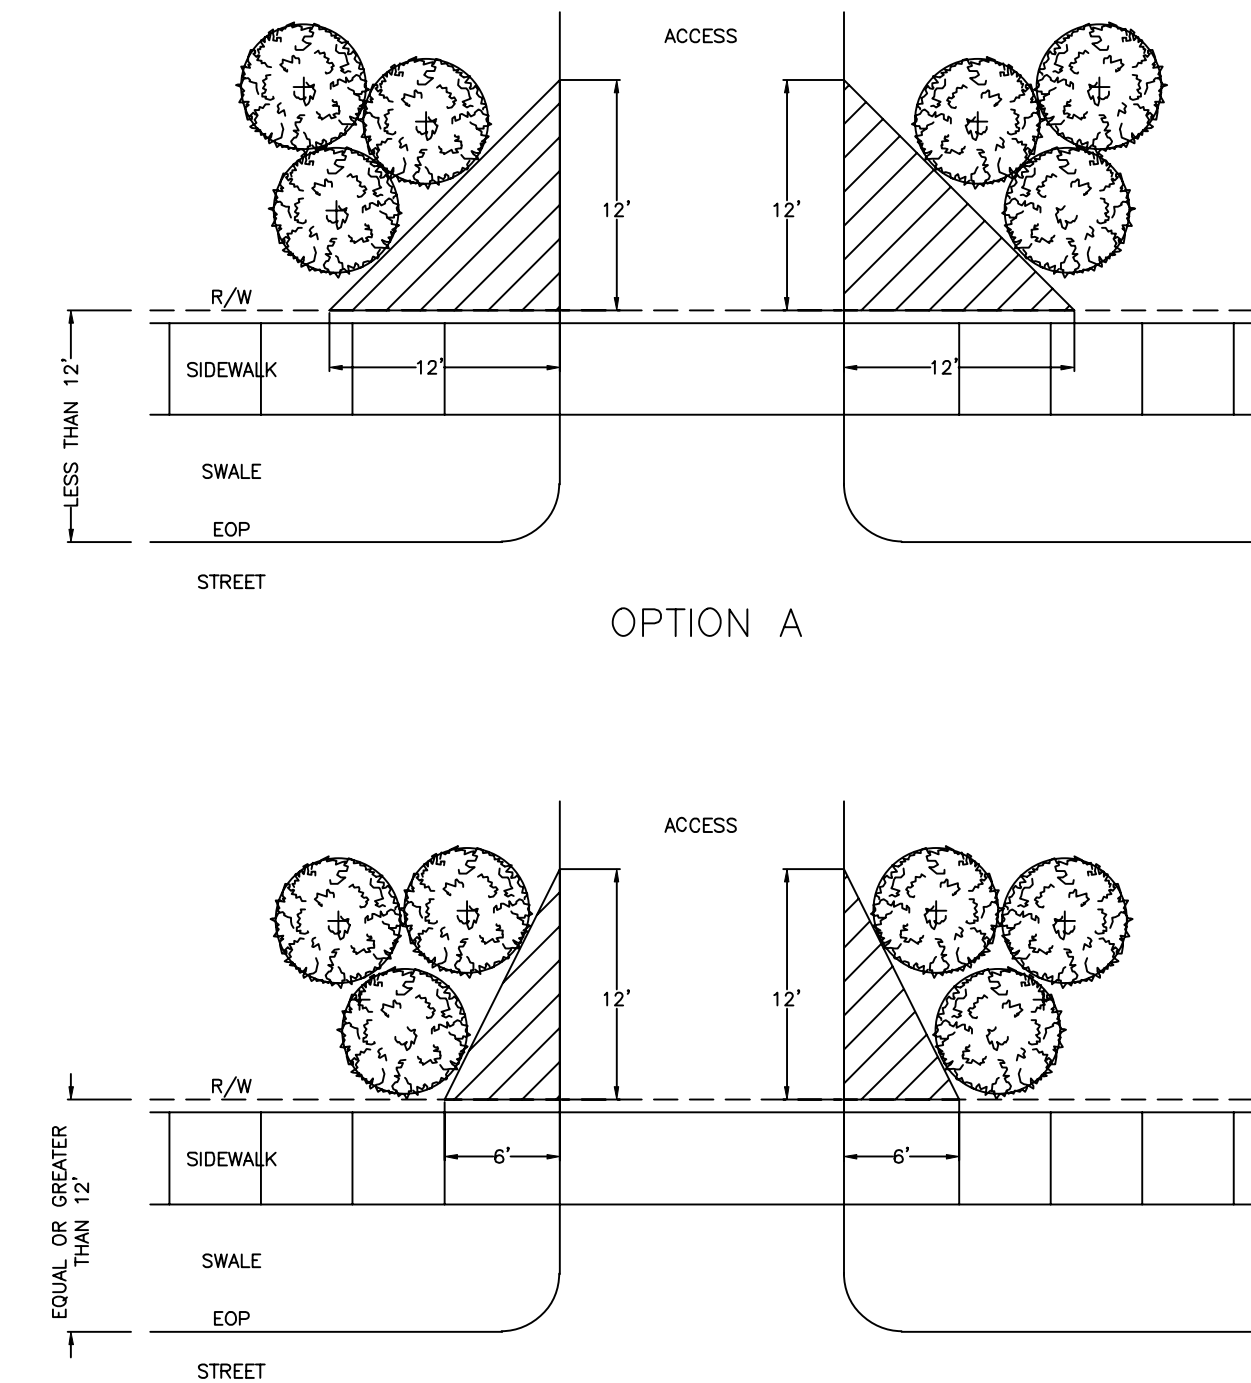


- NOTES:
1. ALL FENCES, WALLS, BUSHES, HEDGES, AND ANY OTHER LANDSCAPING OR PLANT MATERIAL WITHIN THE VIEW TRIANGLE SHALL PROVIDE UNOBSTRUCTED CROSS VISIBILITY AT A LEVEL BETWEEN 30 INCHES AND 72 INCHES ABOVE GROUND LEVEL.
 2. TREES HAVING OVER 72 INCHES OF CLEAR TRUNK WITH LIMBS AND FOLIAGE TRIMMED IN SUCH A MANNER AS NOT TO EXTEND INTO THE VIEW TRIANGLE SHALL BE PERMITTED WITHIN SAID AREAS, PROVIDED THEY IN NO WAY IMPEDE VISIBILITY. NO LANDSCAPING ELEMENTS, EXCEPT FOR REQUIRED GRASS OR GROUND COVER, SHALL BE LOCATED CLOSER THAN 36 INCHES FROM THE EDGE OF ANY VEHICULAR TRAVEL LANE.

DRAWING NO.:
L-07

VISIBILITY TRIANGLE DETAIL

DRAWING NO.:
L-03

TREE PLANTING DETAIL

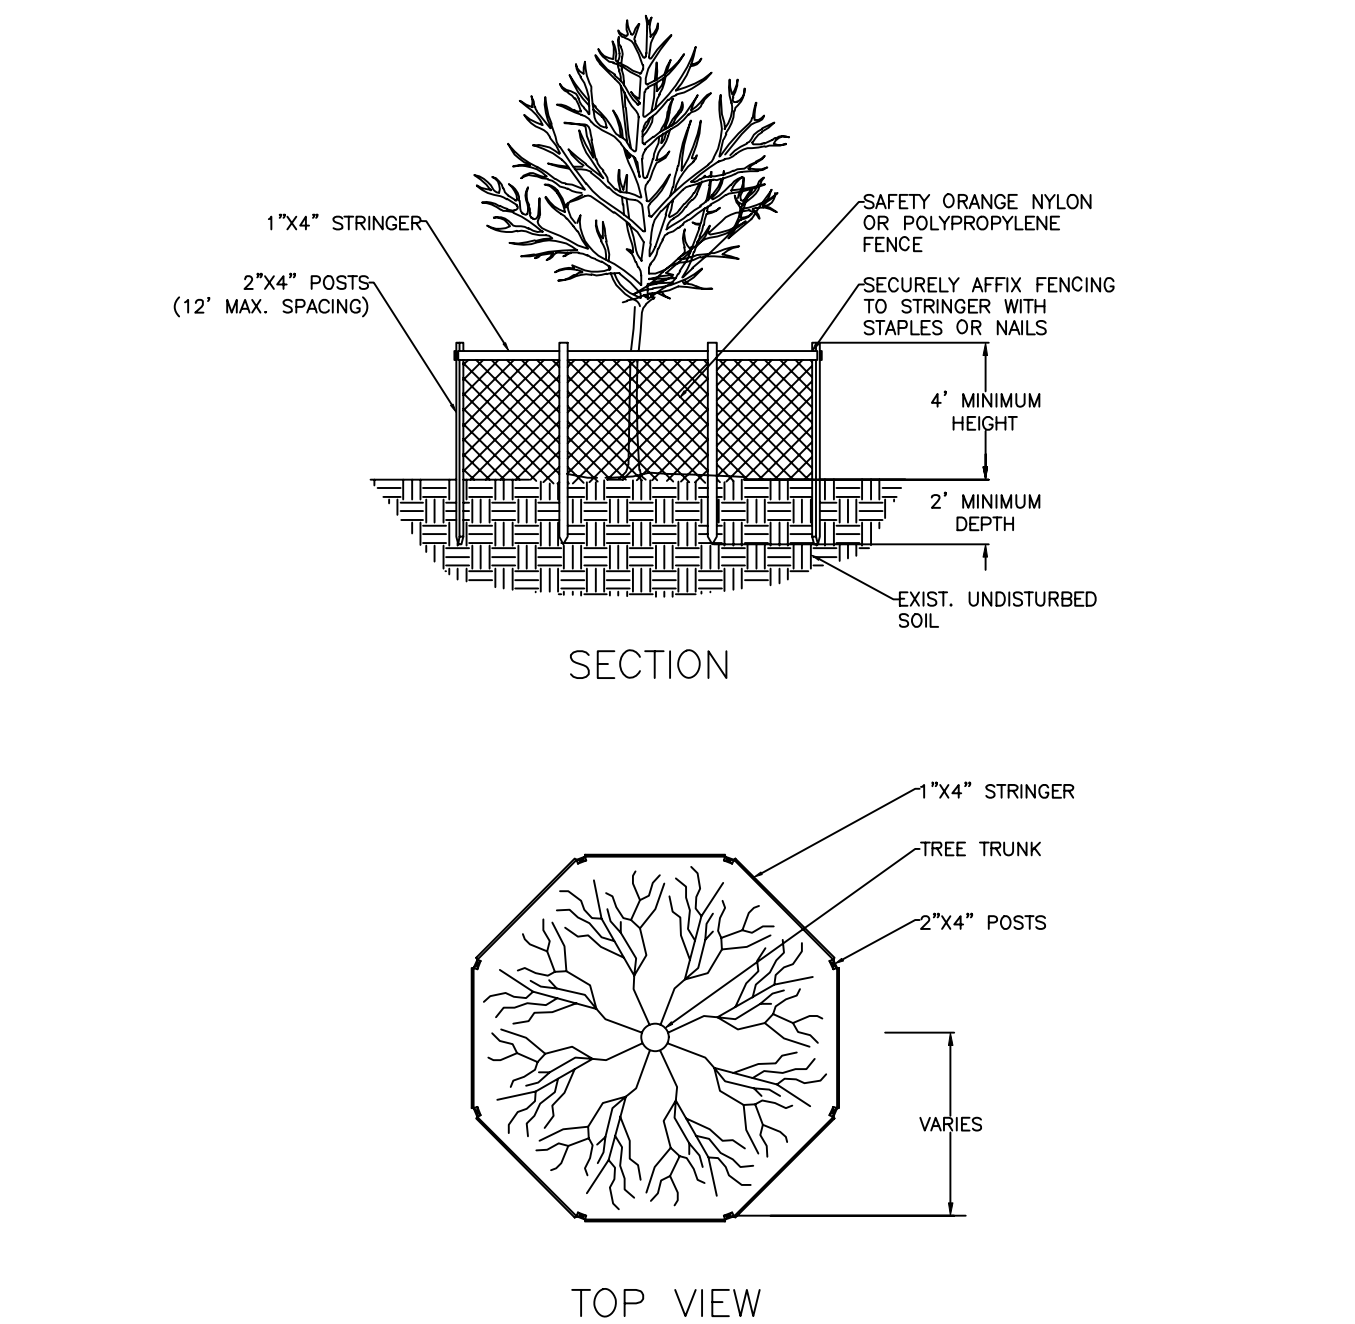


- NOTES:
1. BARRICADE CIRCLE TO BE CENTERED ON TREE TRUNK(S). FOR GROUPS OF TREES, PLACE BARRICADES BETWEEN TREES AND CONSTRUCTION ACTIVITY.
 2. TREE PROTECTION BARRICADES SHALL BE LOCATED TO PROTECT EXISTING, RELOCATED AND NEW TREES IN CONSTRUCTION AREAS. THE PROTECTIVE BARRIER SHALL BE PLACED AROUND THE TREE AT A DISTANCE 6 FEET FROM THE TREE TRUNK OR AT THE CANOPY DRIP LINE, WHICHEVER IS GREATER OR AS SHOWN ON LANDSCAPE PLAN.

DRAWING NO.:
L-08

TREE PROTECTION DETAIL

DRAWING NO.:
L-04

TYPICAL SCREEN FOR UTILITIES

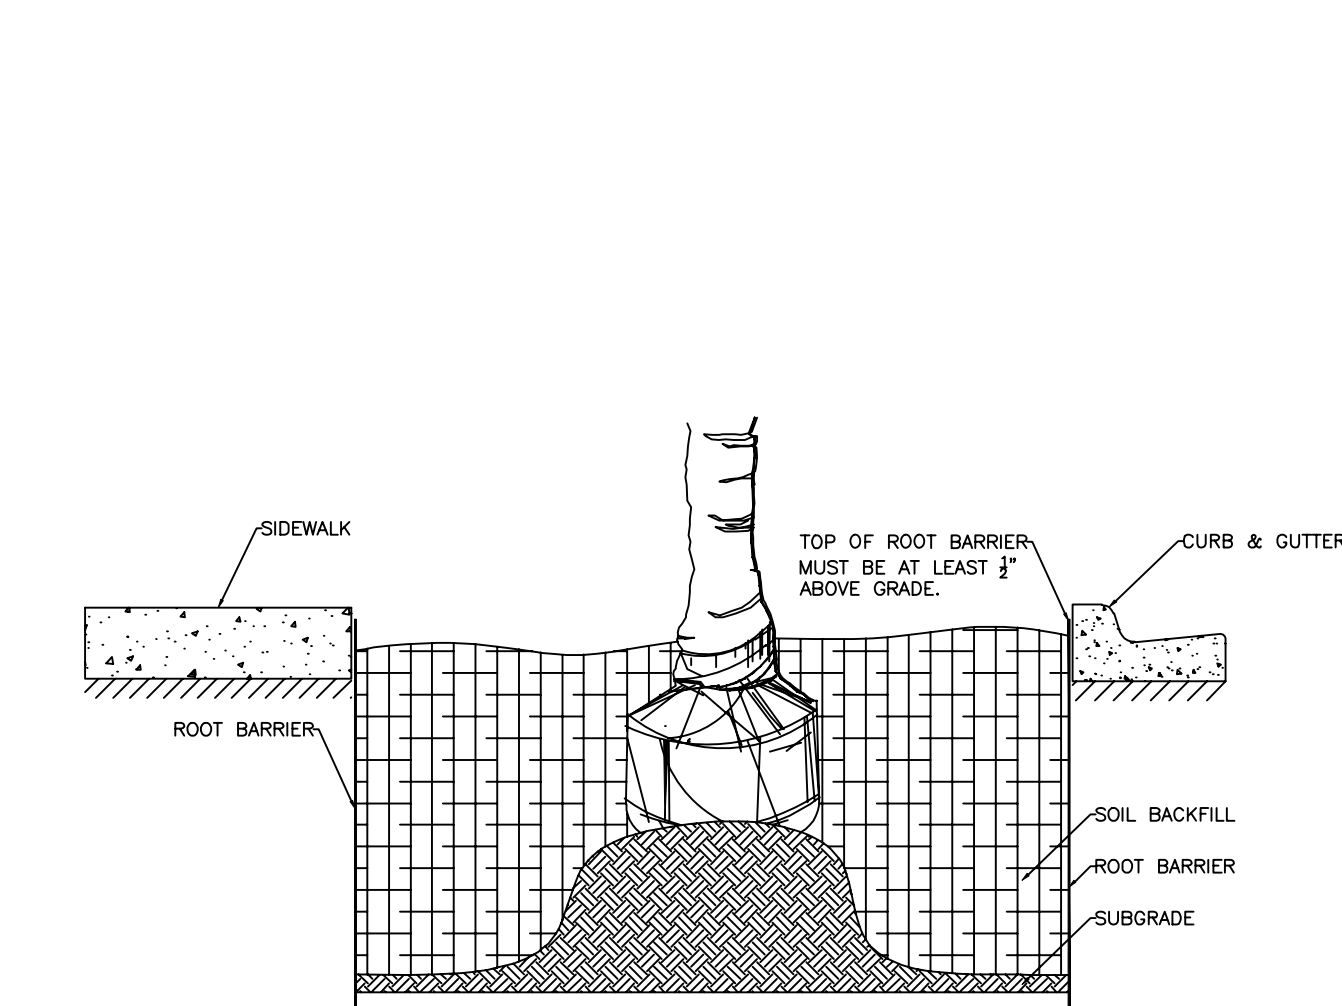

- NOTE:
1. ROOT BARRIERS WHEN USED FOR SWALE TREES THAT ARE PLANTED WITHIN FIVE FEET OF A SIDEWALK OR ROADWAY SHALL BE PLACED AGAINST THE EDGE OF THE SIDEWALK AND THE EDGE OF THE PAVEMENT, AND SHALL EXTEND FIVE FEET IN BOTH DIRECTIONS PARALLEL TO THE SIDEWALK AND ROADWAY.

DRAWING NO.:
L-09

ROOT BARRIER DETAIL

CALL 48 HOURS BEFORE YOU DIG

IT'S THE LAW! DIAL 811

Know what's below. Call before you dig.

SUNSHINE STATE ONE CALL OF FLORIDA, INC.

NO.	REVISIONS	DATE	BY

Kimley»Horn

445 24TH STREET, SUITE 200, VERO BEACH, FL 32960
PHONE: 772-794-4100
WWW.KIMLEY-HORN.COM

REGISTRY NO. 35106

THIS ITEM HAS BEEN DIGITALLY SIGNED AND SEALED BY BENJAMIN V. JOHNSON. PLA ON THE DATE ADJACENT TO THE SIGNATURE. PRINTED COPIES OF THIS DOCUMENT ARE NOT CONSIDERED SIGNED AND SEALED AND THE SIGNATURE MUST BE VERIFIED ON ANY ELECTRONIC COPIES.

BENJAMIN V. JOHNSON
FLORIDA
LANDSCAPE ARCHITECT
NO. 1231187
DATE 9/12/2024
EXPIRATION DATE 9/12/2024
NO. 1231187

KHA PROJECT 043326005	DATE 9/3/2024	SCALE AS SHOWN	DESIGNED BY NIR	DRAWN BY NIR	CHECKED BY KD
--------------------------	------------------	-------------------	--------------------	-----------------	------------------

HOLLYWOOD PLANTING DETAILS

OAKWOOD SOUTH
RETAIL SHOPPING
CENTER

FL

CITY OF HOLLYWOOD

SHEET NUMBER
L-203

This document, together with the concepts and designs presented herein, as an instrument of service, is intended only for the specific purpose and client for which it was prepared. Reuse of and improper reliance on this document without written authorization and adaptation by Kimley-Horn and Associates, Inc. shall be without liability to Kimley-Horn and Associates, Inc.

GENERAL LANDSCAPE SPECIFICATIONS AND NOTES

A. SCOPE OF WORK

1. THE WORK CONSISTS OF: FURNISHING ALL LABOR, MATERIALS, EQUIPMENT, TOOLS, TRANSPORTATION, AND ANY OTHER APPURTENANCES NECESSARY FOR THE COMPLETION OF THIS PROJECT AS SHOWN ON THE DRAWINGS, AS INCLUDED IN THE PLANT LIST, AND AS HEREIN SPECIFIED.

2. WORK SHALL INCLUDE MAINTENANCE AND WATERING OF ALL CONTRACT PLANTING AREAS UNTIL CERTIFICATION OF ACCEPTABILITY BY THE OWNER.

B. PROTECTION OF EXISTING STRUCTURES

ALL EXISTING BUILDINGS, WALKS, WALLS, PAVING, PIPING, OTHER SITE CONSTRUCTION ITEMS, AND PLANTING ALREADY COMPLETED OR ESTABLISHED SHALL BE PROTECTED FROM DAMAGE BY THE CONTRACTOR UNLESS OTHERWISE SPECIFIED. ALL DAMAGE RESULTING FROM NEGLIGENCE SHALL BE REPAIRED OR REPLACED TO THE SATISFACTION OF THE OWNER, AT NO COST TO THE OWNER.

C. PROTECTION OF EXISTING PLANT MATERIALS OUTSIDE LIMIT OF WORK

THE CONTRACTOR SHALL BE RESPONSIBLE FOR ALL UNAUTHORIZED CUTTING OR DAMAGE TO TREES AND SHRUBS EXISTING OR OTHERWISE CAUSED BY CARELESS EQUIPMENT OPERATION, MATERIAL STOCKPILING, ETC. THIS SHALL INCLUDE COMPACTION BY DRIVING OR PARKING INSIDE THE DRIPLINE AND SPILLING OIL, GASOLINE, OR OTHER DELETERIOUS MATERIALS WITHIN THE DRIPLINE. NO MATERIALS SHALL BE BURNED WHERE HEAT WILL DAMAGE ANY PLANT. EXISTING TREES KILLED OR DAMAGED SO THAT THEY ARE MISSHAPEN AND/ OR UNSIGHTLY SHALL BE REPLACED AT THE COST TO THE CONTRACTOR OF ONE HUNDRED DOLLARS (\$100) PER CALIPER INCH ON AN ESCALATING SCALE WHICH ADDS AN ADDITIONAL TWENTY (20) PERCENT PER INCH OVER FOUR (4) INCHES CALIPER AS FIXED AND AGREED LIQUIDATED DAMAGES. CALIPER SHALL BE MEASURED SIX (6) INCHES ABOVE GROUND LEVEL FOR TREES UP TO AND INCLUDING FOUR (4) INCHES IN CALIPER AND TWELVE (12) INCHES ABOVE GROUND LEVEL FOR TREES OVER FOUR (4) INCHES IN CALIPER.

D. MATERIALS

1. GENERAL

MATERIALS LISTED BELOW SHALL BE SUBMITTED FOR APPROVAL. UPON SUBMITTALS' APPROVAL, DELIVERY OF MATERIALS MAY COMMENCE.

MATERIAL	SUBMITTAL
MULCH	PRODUCT DATA
TOPSOIL MIX	AMENDMENT MIX; PRODUCT DATA/ TEST RESULTS
PLANTS	PHOTOGRAPHS OF ONE (1) OF EACH SPECIES (OR TAGGED IN NURSERY) INDICATE SIZES (HEIGHT/WIDTH) AND QUALITY PER SPEC.
	CLIENT-REQUESTED TAGGING MAY SUBSTITUTE PHOTOS.
FERTILIZER	PRODUCT DATA
INOCULANT	PRODUCT DATA
HERBICIDE	PRODUCT DATA

2. PLANT MATERIALS

A. PLANT SPECIES AND SIZE SHALL CONFORM TO THOSE INDICATED ON THE DRAWINGS. NOMENCLATURE SHALL CONFORM TO STANDARDIZED PLANT NAMES, 1942 EDITION. ALL NURSERY STOCK SHALL BE IN ACCORDANCE WITH GRADES AND STANDARDS FOR NURSERY PLANTS, LATEST EDITION, PUBLISHED BY THE FLORIDA DEPARTMENT OF AGRICULTURE AND CONSUMER SERVICES. ALL PLANTS SHALL BE FLORIDA GRADE NO. 1 OR BETTER AS DETERMINED BY THE FLORIDA DIVISION OF PLANT INDUSTRY. ALL PLANTS SHALL BE HEALTHY, VIGOROUS, SOUND, WELL-BRANCHED, AND FREE OF DISEASE AND INSECTS, INSECT EGGS AND LARVAE AND SHALL HAVE ADEQUATE ROOT SYSTEMS. TREES FOR PLANTING IN ROWS SHALL BE UNIFORM IN SIZE AND SHAPE. ALL MATERIALS SHALL BE SUBJECT TO APPROVAL BY THE OWNER. WHERE ANY REQUIREMENTS ARE OMITTED FROM THE PLANT LIST, THE PLANTS FURNISHED SHALL BE NORMAL FOR THE VARIETY. PLANTS SHALL BE PRUNED PRIOR TO DELIVERY ONLY WITH APPROVAL FROM OWNER OR OWNER'S REPRESENTATIVE. NO SUBSTITUTIONS SHALL BE MADE WITHOUT WRITTEN PERMISSION FROM THE OWNER'S REPRESENTATIVE.

B. MEASUREMENTS: THE HEIGHT AND/OR WIDTH OF TREES SHALL BE MEASURED FROM THE GROUND OR ACROSS THE NORMAL SPREAD OF BRANCHES WITH THE PLANTS IN THEIR NORMAL POSITION. THIS MEASUREMENT SHALL NOT INCLUDE THE IMMEDIATE TERMINAL GROWTH. PLANTS LARGER IN SIZE THAN THOSE SPECIFIED IN THE PLANT LIST MAY BE USED IF APPROVED BY THE OWNER. IF THE USE OF LARGER PLANTS IS APPROVED, THE BALL OF EARTH OR SPREAD OF ROOTS SHALL BE INCREASED IN PROPORTION TO THE SIZE OF THE PLANT.

C. INSPECTION: PLANTS SHALL BE SUBJECT TO INSPECTION AND APPROVAL AT THE PLACE OF GROWTH, OR UPON DELIVERY TO THE SITE, AS DETERMINED BY THE OWNER, FOR QUALITY, SIZE, AND VARIETY; SUCH APPROVAL SHALL NOT IMPAIR THE RIGHT OF INSPECTION AND REJECTION AT THE SITE DURING PROGRESS OF THE WORK OR AFTER COMPLETION FOR SIZE AND CONDITION OF ROOT BALLS OR ROOTS, LATENT DEFECTS OR INJURIES. REJECTED PLANTS SHALL BE REMOVED IMMEDIATELY FROM THE SITE. NOTICE REQUESTING INSPECTION SHALL BE SUBMITTED IN WRITING BY THE CONTRACTOR AT LEAST ONE (1) WEEK PRIOR TO ANTICIPATED DATE.

E. SOIL MIXTURE (PLANTING MEDIUM, PLANTING MIX, MIX)

1. SOIL MIXTURE SHALL CONSIST OF 70% COARSE SAND, 30% FLORIDA PEAT AS DESCRIBED BELOW.
2. SOIL FOR USE IN PREPARING SOIL MIXTURE FOR BACKFILLING SHALL BE FERTILE, FRIABLE, AND REASONABLY FREE OF SUBSOIL, CLAY LUMPS, BRUSH WEED AND OTHER LITTER, FREE OF ROOTS, STUMPS, STONE LARGER THAN 2" IN ANY DIRECTION, AND OTHER EXTRANEOUS OR TOXIC MATTER HARMFUL TO PLANT GROWTH. IT SHALL HAVE A PH BETWEEN 5.5 AND 7.0 - SUBMIT SAMPLE AND PH TESTING RESULTS FOR APPROVAL.
3. SAND SHALL BE COARSE, CLEAN, WELL-DRAINING, NATIVE ORTOM MINED SAND. CONTRACTOR SHALL SUBMIT RESULTS OF SOIL TEST FOR PEAT AND SAND PROPOSED FOR USE UNDER THIS CONTRACT FOR APPROVAL.
4. CONTRACTOR SHALL SUBMIT SAMPLES OF SOIL MIXTURE FOR LANDSCAPE ARCHITECT REVIEW UNDER FORMAL SUBMITTAL AND SUBSEQUENTLY TO OWNER'S REPRESENTATIVE THEREAFTER FOR APPROVAL PRIOR TO PLANT INSTALLATION OPERATIONS COMMENCE.
5. FLORIDA MUCK/ FLORIDA MUCKY PEAT MAY BE PROVIDED AS A SUBSTITUTE FOR THE 30% FLORIDA PEAT, CONTINGENT UPON PRELIMINARY TEST RESULTS AND AS DETERMINED BY THE LANDSCAPE ARCHITECT DURING THE SUBMITTAL PROCESS. ANY CHANGES IN THE PERCENTAGES OR PARENT MATERIALS REQUIRED TO PROVIDE THE SPECIFIED MIXTURE AS DETERMINED BY THE LANDSCAPE ARCHITECT SHALL BE PROVIDED BY THE CONTRACTOR AT NO ADDITIONAL COST TO OWNER.
6. CONTRACTOR SHALL PROVIDE PH TEST RESULTS FOR ALL MIX COMPONENTS AND FINAL MIX.
7. CONTRACTOR SHALL PROVIDE PENETROMETER ON-SITE AT ALL TIMES FOR COMPACTION INSPECTION AT THE DISCRETION OF THE LANDSCAPE ARCHITECT.
8. PENETROMETER CRITERIA / SPECIFICATIONS SHALL RANGE FROM APPROX. 75 PSI TO LESS THAN 300 PSI OR AS DETERMINED BY THE LANDSCAPE ARCHITECT.
9. FINAL MIX SHALL BE TESTED TO HAVE A SATURATED WEIGHT OF NO MORE THAN 85 POUNDS PER CUBIC FOOT WHEN COMPACTED TO 85% STANDARD PROCTOR. FERTILIZER PRODUCT DATA AND RATE SCHEDULE SHALL BE SUBMITTED CONCURRENTLY WITH THE SOIL SUBMITTAL FOR EVALUATION BY THE LANDSCAPE ARCHITECT.
10. SOIL SHALL BE SUPPLIED BY ATLAS PEAT & SOIL INC. 8621 STATE ROAD, BOYNTON BEACH, FLORIDA 33472 PHONE: 561-734-7300.

F. WATER

WATER NECESSARY FOR PLANTING AND MAINTENANCE SHALL BE OF SATISFACTORY QUALITY TO SUSTAIN AN ADEQUATE PLANT GROWTH AND SHALL NOT CONTAIN HARMFUL, NATURAL OR MANMADE ELEMENTS DETRIMENTAL TO PLANTS. WATER MEETING THE ABOVE STANDARD SHALL BE OBTAINED ON THE SITE FROM THE OWNER, IF AVAILABLE, AND THE CONTRACTOR SHALL BE RESPONSIBLE TO MAKE ARRANGEMENTS FOR ITS USE BY HIS TANKS, HOSES, SPRINKLERS, ETC., IF SUCH WATER IS NOT AVAILABLE AT THE SITE, THE CONTRACTOR SHALL PROVIDE SATISFACTORY WATER FROM SOURCES OFF THE SITE AT NO ADDITIONAL COST TO THE OWNER.

*WATERING/IRRIGATION RESTRICTIONS MAY APPLY - REFER TO PROPERTY'S JURISDICTIONAL AUTHORITY.

G. FERTILIZER

CONTRACTOR SHALL PROVIDE FERTILIZER APPLICATION SCHEDULE TO OWNER, AS APPLICABLE TO SOIL TYPE, PLANT INSTALLATION TYPE, AND SITE'S PROPOSED USE. SUGGESTED FERTILIZER TYPES SHALL BE ORGANIC OR OTHERWISE NATURALLY-DERIVED.

*FERTILIZER RESTRICTIONS MAY APPLY - REFER TO PROPERTY'S JURISDICTIONAL AUTHORITY.

H. ROCK MULCH

ROCK MULCH MATERIAL SHALL BE TWO (2) TO THREE (3) INCHES DIAMETER CHATTAHOOCHEE ROCK (OR APPROVED EQUAL) AT A MINIMUM DEPTH OF THREE (3) INCHES IN ALL LANDSCAPE SHRUB AND GROUND COVER AREAS. THE ROCK MULCH SHALL CONFINED TO THE LANDSCAPE BED LINES ESTABLISHED BY ADJACENT SOD AREAS, HARDSCAPE AREAS, AND CURBS. CLEAR MULCH FROM EACH PLANT'S CROWN (BASE).

I. DIGGING AND HANDLING

1. PROTECT ROOTS OR ROOT BALLS OF PLANTS AT ALL TIMES FROM SUN, DRYING WINDS, WATER AND FREEZING, AS NECESSARY UNTIL PLANTING. PLANT MATERIALS SHALL BE ADEQUATELY PACKED TO PREVENT DAMAGE DURING TRANSIT. TREES TRANSPORTED MORE THAN TEN (10) MILES OR WHICH ARE NOT PLANTED WITHIN THREE (3) DAYS OF DELIVERY TO SITE SHALL BE SPRAYED WITH AN ANTITRANSPIRANT PRODUCT ("WILT-PRU" OR EQUAL) TO MINIMIZE TRANSPIRATIONAL WATER LOSS.
2. BALLED AND BURLAPPED PLANTS (BAB) SHALL BE DUG WITH FIRM, NATURAL BALLS OF SOIL OF SUFFICIENT SIZE TO ENCOMPASS THE FIBROUS AND FEEDING ROOTS OF THE PLANTS. NO PLANTS MOVED WITH A ROOT BALL SHALL BE PLANTED IF THE BALL IS CRACKED OR BROKEN. PLANTS BALLED AND BURLAPPED OR CONTAINER GROWN SHALL NOT BE HANDLED BY STEMS.
3. PLANTS MARKED "BR" IN THE PLANT LIST SHALL BE DUG WITH BARE ROOTS, COMPLYING WITH FLORIDA GRADES AND STANDARDS FOR NURSERY PLANTS, CURRENT EDITION. CARE SHALL BE EXERCISED THAT THE ROOTS DO NOT DRY OUT DURING TRANSPORTATION AND PRIOR TO PLANTING.
4. PROTECTION OF PALMS (IF APPLICABLE): ONLY A MINIMUM OF FRONDS SHALL BE REMOVED FROM THE CROWN OF THE PALM TREES TO FACILITATE MOVING AND HANDLING. CLEAR TRUNK (CT) SHALL BE AS SPECIFIED AFTER THE MINIMUM OF FRONDS HAVE BEEN REMOVED. ALL PALMS SHALL BE BRACED PER PALM PLANTING DETAIL.
5. EXCAVATION OF TREE PITS SHALL BE PERFORMED USING EXTREME CARE TO AVOID DAMAGE TO SURFACE AND SUBSURFACE ELEMENTS SUCH AS UTILITIES OR HARDSCAPE ELEMENTS, FOOTERS AND PREPARED SUB- BASES.

J. CONTAINER GROWN STOCK

1. ALL CONTAINER GROWN MATERIAL SHALL BE HEALTHY, VIGOROUS, WELL-ROOTED PLANTS ESTABLISHED IN THE CONTAINER IN WHICH THEY ARE SOLD. THE PLANTS SHALL HAVE TOPS WHICH ARE OF GOOD QUALITY AND ARE IN A HEALTHY GROWING CONDITION, FLORIDA #1 OR BETTER.
2. AN ESTABLISHED CONTAINER GROWN PLANT SHALL BE TRANSPLANTED INTO A CONTAINER AND GROWN IN THAT CONTAINER SUFFICIENTLY LONG FOR THE NEW FIBROUS ROOTS TO HAVE DEVELOPED SO THAT THE ROOT MASS WILL RETAIN ITS SHAPE AND HOLD TOGETHER WHEN REMOVED FROM THE CONTAINER. CONTAINER GROWN STOCK SHALL NOT BE HANDLED BY THEIR STEMS.
3. PLANT ROOTS BOUND IN CONTAINERS ARE NOT ACCEPTABLE.
4. SUBSTITUTION OF NON-CONTAINER GROWN MATERIAL FOR MATERIAL EXPLICITLY SPECIFIED TO BE CONTAINER GROWN WILL NOT BE PERMITTED WITHOUT WRITTEN APPROVAL IS OBTAINED FROM THE OWNER OR OWNER'S REPRESENTATIVE.

K. COLLECTED STOCK

WHEN THE USE OF COLLECTED STOCK IS PERMITTED AS INDICATED BY THE OWNER OR OWNER'S REPRESENTATIVE, THE MINIMUM SIZES OF ROOTBALLS SHALL BE EQUAL TO THAT SPECIFIED FOR THE NEXT LARGER SIZE OF NURSERY GROWN STOCK OF THE SAME VARIETY.

L. NATIVE STOCK

PLANTS COLLECTED FROM WILD OR NATIVE STANDS SHALL BE CONSIDERED NURSERY GROWN WHEN THEY HAVE BEEN SUCCESSFULLY RE-ESTABLISHED IN A NURSERY ROW AND GROWN UNDER REGULAR NURSERY CULTURAL PRACTICES FOR A MINIMUM OF TWO (2) GROWING SEASONS AND HAVE ATTAINED ADEQUATE ROOT AND TOP GROWTH TO INDICATE FULL RECOVERY FROM TRANSPLANTING INTO THE NURSERY ROW.

M. MATERIALS LIST

QUANTITIES NECESSARY TO COMPLETE THE WORK ON THE DRAWINGS SHALL BE FURNISHED BY THE CONTRACTOR. QUANTITY ESTIMATES HAVE BEEN MADE CAREFULLY, BUT THE LANDSCAPE ARCHITECT OR OWNER ASSUMES NO LIABILITY FOR OMISSIONS OR ERRORS. SHOULD A DISCREPANCY OCCUR BETWEEN THE PLANS AND THE PLANT LIST QUANTITY, THE LANDSCAPE ARCHITECT SHALL BE NOTIFIED FOR CLARIFICATION PRIOR TO BIDDING OR INSTALLATION. ALL DIMENSIONS AND/OR SIZES SPECIFIED SHALL BE THE MINIMUM ACCEPTABLE SIZE.

N. FINE GRADING

1. FINE GRADING UNDER THIS CONTRACT SHALL CONSIST OF FINAL FINISHED GRADING OF LAWN AND PLANTING AREAS THAT HAVE BEEN ROUGH GRADED BY OTHERS. BERMING AS SHOWN ON THE DRAWINGS SHALL BE THE RESPONSIBILITY OF THE CONTRACTOR, UNLESS OTHERWISE NOTED.
2. THE CONTRACTOR SHALL FINE GRADE THE LAWN AND PLANTING AREAS TO BRING THE ROUGH GRADE UP TO FINAL FINISHED GRADE ALLOWING FOR THICKNESS OF SOD AND/OR MULCH DEPTH. THIS CONTRACTOR SHALL FINE GRADE BY HAND AND/OR WITH ALL EQUIPMENT NECESSARY INCLUDING A GRADING TRACTOR WITH FRONT-END LOADER FOR TRANSPORTING SOIL WITHIN THE SITE.
3. ALL PLANTING AREAS SHALL BE GRADED AND MAINTAINED FOR POSITIVE DRAINAGE TO SURFACE/SUBSURFACE STORM DRAIN SYSTEMS. AREAS ADJACENT TO BUILDINGS SHALL SLOPE AWAY FROM THE BUILDINGS, REFER TO CIVIL ENGINEER'S PLANS FOR FINAL GRADES.

O. PLANTING PROCEDURES

1. CLEANING UP BEFORE COMMENCING WORK: THE CONTRACTOR SHALL CLEAN WORK AND SURROUNDING AREAS OF ALL RUBBISH OR OBJECTIONABLE MATTER. ALL MORTAR, CEMENT, AND TOXIC MATERIAL SHALL BE REMOVED FROM THE SURFACE OF ALL PLANT BEDS. THESE MATERIALS SHALL NOT BE MIXED WITH THE SOIL. SHOULD THE CONTRACTOR FIND SUCH SOIL CONDITIONS BENEATH THE SOIL WHICH WILL IN ANY WAY ADVERSELY AFFECT THE PLANT GROWTH, HE SHALL IMMEDIATELY CALL IT TO THE ATTENTION OF THE OWNER'S REPRESENTATIVE. FAILURE TO DO SO BEFORE PLANTING SHALL MAKE THE CORRECTIVE MEASURES THE RESPONSIBILITY OF THE CONTRACTOR.
2. VERIFY LOCATIONS OF ALL UTILITIES, CONDUITS, SUPPLY LINES AND CABLES, INCLUDING BUT NOT LIMITED TO: ELECTRIC, GAS (LINES AND TANKS), WATER, SANITARY SEWER, STORMWATER SYSTEMS, CABLE, AND TELEPHONE. PROPERLY MAINTAIN AND PROTECT EXISTING UTILITIES. CALL NATIONAL ONE CALL - 811 - TO LOCATE UTILITIES.

3. SUBGRADE EXCAVATION: CONTRACTOR IS RESPONSIBLE TO REMOVE ALL EXISTING AND IMPORTED LIMESTONE AND LIMESTONE SUB-BASE FROM ALL LANDSCAPE PLANTING AREAS TO A MINIMUM DEPTH OF 36". CONTRACTOR IS RESPONSIBLE TO BACKFILL THESE PLANTING AREAS TO ROUGH FINISHED GRADE WITH CLEAN TOPSOIL FROM AN ON-SITE SOURCE OR AN IMPORTED SOURCE. IF LIMESTONE OR OTHER ADVERSE CONDITIONS OCCUR IN PLANTED AREAS AFTER 36" DEEP EXCAVATION BY THE CONTRACTOR, AND ADEQUATE PERCOLATION CAN NOT BE ACHIEVED, CONTRACTOR SHALL UTILIZE PLANTING DETAIL THAT ADDRESSES POOR DRAINAGE.

4. FURNISH NURSERY'S CERTIFICATE OF COMPLIANCE WITH ALL REQUIREMENTS AS HEREIN SPECIFIED AND REQUIRED. INSPECT AND SELECT PLANT MATERIALS BEFORE PLANTS ARE DUG AT NURSERY OR GROWING SITE.

5. GENERAL: COMPLY WITH APPLICABLE FEDERAL, STATE, COUNTY, AND LOCAL REGULATIONS GOVERNING LANDSCAPE MATERIALS AND WORK. CONFORM TO ACCEPTED HORTICULTURAL PRACTICES AS USED IN THE TRADE. UPON ARRIVAL AT THE SITE, PLANTS SHALL BE THOROUGHLY WATERED AND PROPERLY MAINTAINED UNTIL PLANTED. PLANTS STORED ON-SITE SHALL NOT REMAIN UNPLANTED FOR A PERIOD EXCEEDING TWENTY-FOUR (24) HOURS. AT ALL TIMES, METHODS CUSTOMARY IN GOOD HORTICULTURAL PRACTICES SHALL BE EXERCISED.

6. THE WORK SHALL BE COORDINATED WITH OTHER TRADES TO PREVENT CONFLICTS. COORDINATE PLANTING WITH IRRIGATION WORK TO ASSURE AVAILABILITY OF WATER AND PROPER LOCATION OF IRRIGATION APPURTENANCES AND PLANTS.

7. ALL PLANTING PITS SHALL BE EXCAVATED TO SIZE AND DEPTH IN ACCORDANCE WITH THE USA STANDARD FOR NURSERY STOCK 260.1, UNLESS SHOWN OTHERWISE ON THE DRAWINGS, AND BACKFILLED WITH THE PREPARED PLANTING SOIL MIXTURE AS SPECIFIED IN SECTION E. TEST ALL TREE PITS WITH WATER BEFORE PLANTING TO ASSURE PROPER DRAINAGE PERCOLATION IS AVAILABLE. NO ALLOWANCE WILL BE MADE FOR LOST PLANTS DUE TO IMPROPER PERCOLATION. IF POOR PERCOLATION EXISTS, UTILIZE POOR DRAINAGE CONDITION PLANTING DETAIL. TREES SHALL BE SET PLUMB AND HELD IN POSITION UNTIL THE PLANTING MIXTURE HAS BEEN FLUSHED INTO PLACE WITH A SLOW, FULL HOSE STREAM. ALL PLANTING SHALL BE PERFORMED BY PERSONNEL FAMILIAR WITH PLANTING PROCEDURES AND UNDER THE SUPERVISION OF A QUALIFIED LANDSCAPE FOREMAN. PROPER "JETING" SHALL BE ASSURED TO ELIMINATE AIR POCKETS AROUND THE ROOTS. "JET STICK" OR EQUAL IS RECOMMENDED.

8. TAKE ALL NECESSARY PRECAUTIONS TO AVOID DAMAGE TO BUILDINGS AND BUILDING STRUCTURES WHILE INSTALLING TREES.

9. SOIL MIXTURE SHALL BE AS SPECIFIED IN SECTION E OF THESE SPECIFICATIONS.

10. TREES AND SHRUBS SHALL BE SET STRAIGHT AT AN ELEVATION THAT, AFTER SETTLEMENT, THE PLANT CROWN WILL STAND ONE (1) TO TWO (2) INCHES ABOVE GRADE. EACH PLANT SHALL BE SET IN THE CENTER OF THE PIT. PLANTING SOIL MIXTURE SHALL BE BACKFILLED, THOROUGHLY TAMPED AROUND THE BALL, AND SETTLED BY WATER (AFTER TAMPING).

11. AMEND PINE AND OAK PLANT PITS WITH ECTOMYCORRHIZAL SOIL APPLICATION PER MANUFACTURER'S RECOMMENDATION. ALL OTHER PLANT PITS SHALL BE AMENDED WITH ENDOMYCORRHIZAL SOIL APPLICATION PER MANUFACTURER'S RECOMMENDATION. PROVIDE PRODUCT INFORMATION SUBMITTAL PRIOR TO INOCULATION.

12. FILL HOLE WITH SOIL MIXTURE, MAKING CERTAIN ALL PITS ARE SATURATED. TO DO THIS, FILL HOLE WITH WATER AND ALLOW TO SOAK A MINIMUM TWENTY (20) MINUTES, STIRRING IF NECESSARY TO GET SOIL THOROUGHLY WET. PACK LIGHTLY WITH FEET. ADD MORE WET SOIL MIXTURE. DO NOT COVER TOP OF BALL WITH SOIL MIXTURE. ONLY WITH MULCH. ALL BURLAP, ROPE, WIRES, BASKETS, ETC., SHALL BE REMOVED FROM THE SIDES AND TOPS OF BALLS, BUT NO BURLAP SHALL BE PULLED FROM UNDERNEATH.

13. PRUNING: TREES SHALL BE PRUNED, AT THE DIRECTION OF THE OWNER OR OWNER'S REPRESENTATIVE, TO PRESERVE THE NATURAL CHARACTER OF THE PLANT. ALL SOFT WOOD OR SUCKER GROWTH AND ALL BROKEN OR BADLY DAMAGED BRANCHES SHALL BE REMOVED WITH A CLEAN CUT. ALL PRUNING TO BE PERFORMED BY LICENSED ARBORIST, IN ACCORDANCE WITH ANSI A-300.

14. SHRUBS AND GROUND COVER PLANTS SHALL BE EVENLY SPACED IN ACCORDANCE WITH THE DRAWINGS AND AS INDICATED ON THE PLANT LIST. CULTIVATE ALL PLANTING AREAS TO A MINIMUM DEPTH OF 6"; REMOVE AND DISPOSE ALL DEBRIS. MIX TOP 4" TO ACHIEVE SOIL MIXTURE AS SPECIFIED IN SECTION E. THOROUGHLY WATER ALL PLANTS AFTER INSTALLATION.

15. TREE GUYING AND BRACING SHALL BE INSTALLED BY THE CONTRACTOR IN ACCORDANCE WITH THE PLANS TO INSURE STABILITY AND MAINTAIN TREES IN AN UPRIGHT POSITION. IF THE CONTRACTOR AND OWNER DECIDE TO WAIVE THE TREE GUYING AND BRACING, THE OWNER SHALL NOTIFY THE LANDSCAPE ARCHITECT IN WRITING AND AGREE TO INDEMNIFY AND HOLD HARMLESS THE LANDSCAPE ARCHITECT IN THE EVENT UNSUPPORTED TREES PLANTED UNDER THIS CONTRACT FALL AND DAMAGE PERSON OR PROPERTY.

16. MULCHING: PROVIDE A THREE INCH (MINIMUM) LAYER OF SPECIFIED MULCH OVER THE ENTIRE AREA OF EACH SHRUB BED, GROUND COVER, VINE BED, AND TREE PIT PLANTED UNDER THIS CONTRACT.

17. HERBICIDE WEED CONTROL: ALL PLANT BEDS SHALL BE KEPT FREE OF NOXIOUS WEEDS UNTIL FINAL ACCEPTANCE OF WORK. IF DIRECTED BY THE OWNER, "ROUND-UP" SHALL BE APPLIED FOR WEED CONTROL BY QUALIFIED PERSONNEL TO ALL PLANTING AREAS IN SPOT APPLICATIONS PER MANUFACTURER'S PRECAUTIONS AND SPECIFICATIONS. PRIOR TO FINAL INSPECTION, TREAT ALL PLANTING BEDS WITH AN APPROVED PRE-EMERGENT HERBICIDE AT AN APPLICATION RATE RECOMMENDED BY THE MANUFACTURER. (AS ALLOWED BY JURISDICTIONAL AUTHORITY)

P. LAWN SODDING

1. THE WORK CONSISTS OF LAWN BED PREPARATION, SOIL PREPARATION, AND SODDING COMPLETE, IN STRICT ACCORDANCE WITH THE SPECIFICATIONS AND THE APPLICABLE DRAWINGS TO PRODUCE A TURF GRASS LAWN ACCEPTABLE TO THE OWNER.
2. LAWN BED PREPARATION: ALL AREAS THAT ARE TO BE SODDED SHALL BE CLEARED OF ANY ROUGH GRASS, WEEDS, AND DEBRIS, AND THE GROUND BROUGHT TO AN EVEN GRADE. THE ENTIRE SURFACE SHALL BE ROLLED WITH A ROLLER WEIGHING NOT MORE THAN ONE-HUNDRED (100) POUNDS PER FOOT OF WIDTH. DURING THE ROLLING, ALL DEPRESSIONS CAUSED BY SETTLEMENT SHALL BE FILLED WITH ADDITIONAL SOIL, AND THE SURFACE SHALL BE REGRADED AND ROLLED UNTIL PRESENTING A SMOOTH AND EVEN FINISH TO THE REQUIRED GRADE.

3. SOIL PREPARATION: PREPARE LOOSE BED FOUR (4) INCHES DEEP. HAND RAKE UNTIL ALL BUMPS AND DEPRESSIONS ARE REMOVED. WET PREPARED AREA THOROUGHLY.

4. SODDING

- A. THE CONTRACTOR SHALL SOD ALL AREAS THAT ARE NOT PAVED OR PLANTED AS DESIGNATED ON THE DRAWINGS WITHIN THE CONTRACT LIMITS, UNLESS SPECIFICALLY NOTED OTHERWISE.
- B. THE SOD SHALL BE CERTIFIED TO MEET FLORIDA STATE PLANT BOARD SPECIFICATIONS, ABSOLUTELY TRUE TO VARIETAL TYPE, AND FREE FROM WEEDS, FUNGUS, INSECTS AND DISEASE OF ANY KIND.
- C. SOD PANELS SHALL BE LAID TIGHTLY TOGETHER SO AS TO MAKE A SOLID SODDED LAWN AREA. SOD SHALL BE LAID UNIFORMLY AGAINST THE EDGES OF ALL CURBS AND OTHER HARDSCAPE ELEMENTS, PAVED AND PLANTED AREAS, ADJACENT TO BUILDINGS. A 24 INCH STONE MULCH STRIP SHALL BE PROVIDED - REFER TO DETAILS. IMMEDIATELY FOLLOWING SOD LAYING, THE LAWN AREAS SHALL BE ROLLED WITH A LAWN ROLLER CUSTOMARILY USED FOR SUCH PURPOSES, AND THEN THOROUGHLY IRRIGATED. IF, IN THE OPINION OF THE OWNER, TOP-DRESSING IS NECESSARY AFTER ROLLING TO FILL THE VOIDS BETWEEN THE SOD PANELS AND TO EVEN OUT INCONSISTENCIES IN THE SOD, CLEAN SAND, AS APPROVED BY THE OWNER'S REPRESENTATIVE, SHALL BE UNIFORMLY SPREAD OVER THE ENTIRE SURFACE OF THE SOD AND THOROUGHLY WATERED IN. FERTILIZE INSTALLED SOD AS ALLOWED BY PROPERTY'S JURISDICTIONAL AUTHORITY.

5. DURING DELIVERY, PRIOR TO, AND DURING THE PLANTING OF THE LAWN AREAS, THE SOD PANELS SHALL AT ALL TIMES BE PROTECTED FROM EXCESSIVE DRYING AND UNNECESSARY EXPOSURE OF THE ROOTS TO THE SUN. ALL SOD SHALL BE STACKED SO AS NOT TO BE DAMAGED BY SWEATING OR EXCESSIVE HEAT AND MOISTURE.

6. LAWN MAINTENANCE:

- A. WITHIN THE CONTRACT LIMITS, THE CONTRACTOR SHALL PRODUCE A DENSE, WELL ESTABLISHED LAWN. THE CONTRACTOR SHALL BE RESPONSIBLE FOR THE REPAIR AND RE-SODDING OF ALL ERODED, SUNKEN OR BARE SPOTS (LARGER THAN 12"x12") UNTIL CERTIFICATION OF ACCEPTABILITY BY THE OWNER'S REPRESENTATIVE. REPAIRED SODDING SHALL BE ACCOMPLISHED AS IN THE ORIGINAL WORK (INCLUDING REGRADED IF NECESSARY).
- B. CONTRACTOR RESPONSIBLE FOR ESTABLISHING AND MAINTAINING SOD/LAWN UNTIL ACCEPTANCE BY THE OWNER'S REPRESENTATIVE. PRIOR TO AND UPON ACCEPTANCE, CONTRACTOR TO PROVIDE WATERING/IRRIGATION SCHEDULE TO OWNER. OBSERVE ALL APPLICABLE WATERING RESTRICTIONS AS SET FORTH BY THE PROPERTY'S JURISDICTIONAL AUTHORITY.

Q. CLEANUP

UPON COMPLETION OF ALL PLANTING WORK AND BEFORE FINAL ACCEPTANCE, THE CONTRACTOR SHALL REMOVE ALL MATERIAL, EQUIPMENT, AND DEBRIS RESULTING FROM HIS WORK. ALL PAVED AREAS SHALL BE BROOM-CLEANED AND THE SITE LEFT IN A NEAT AND ACCEPTABLE CONDITION AS APPROVED BY THE OWNER'S AUTHORIZED REPRESENTATIVE.

R. PLANT MATERIAL MAINTENANCE

ALL PLANTS AND PLANTING INCLUDED UNDER THIS CONTRACT SHALL BE MAINTAINED BY WATERING, CULTIVATING, SPRAYING, AND ALL OTHER OPERATIONS (SUCH AS RE-STAKING OR REPAIRING GUY SUPPORTS) NECESSARY TO INSURE A HEALTHY PLANT CONDITION BY THE CONTRACTOR UNTIL CERTIFICATION OF ACCEPTABILITY BY THE OWNER'S REPRESENTATIVE. MAINTENANCE AFTER THE CERTIFICATION OF ACCEPTABILITY SHALL BE IN ACCORDANCE WITH THE SPECIFICATIONS IN THIS SECTION. CONTRACTORS ARE REQUESTED TO PROVIDE A BID ESTIMATE TO COVER LANDSCAPE AND IRRIGATION MAINTENANCE FOR A PERIOD OF 90 CALENDAR DAYS COMMENCING AFTER ACCEPTANCE.

S. MAINTENANCE (ALTERNATE BID ITEM)

CONTRACTORS ARE REQUESTED TO PROVIDE A BID ESTIMATE FOR MAINTENANCE FOLLOWING THE INITIAL 90-DAY MAINTENANCE PERIOD ON A COST-PER-MONTH BASIS.

T. FINAL INSPECTION AND ACCEPTANCE OF WORK

FINAL INSPECTION AT THE END OF THE WARRANTY PERIOD SHALL BE ON PLANTING, CONSTRUCTION AND ALL OTHER INCIDENTAL WORK PERTAINING TO THIS CONTRACT. ANY REPLACEMENT AT THIS TIME SHALL BE SUBJECT TO THE SAME ONE (1) YEAR WARRANTY (OR AS SPECIFIED BY THE LANDSCAPE ARCHITECT OR OWNER IN WRITING) BEGINNING WITH THE TIME OF REPLACEMENT AND ENDING WITH THE SAME INSPECTION AND ACCEPTANCE HEREIN DESCRIBED.


U. WARRANTY

1. THE LIFE AND SATISFACTORY CONDITION OF ALL PLANT MATERIAL INSTALLED BY THE LANDSCAPE CONTRACTOR SHALL BE WARRANTED BY THE CONTRACTOR FOR A MINIMUM OF ONE (1) CALENDAR YEAR COMMENCING AT THE TIME OF CERTIFICATION OF ACCEPTABILITY BY THE OWNER'S REPRESENTATIVE.
2. REPLACEMENT: ANY PLANT NOT FOUND IN A HEALTHY GROWING CONDITION AT THE END OF THE WARRANTY PERIOD SHALL BE REMOVED FROM THE SITE AND REPLACED AS SOON AS WEATHER CONDITIONS PERMIT. ALL REPLACEMENTS SHALL BE PLANTS OF THE SAME KIND AND SIZE AS SPECIFIED IN THE PLANT LIST. THEY SHALL BE FURNISHED PLANTED AND MULCHED AS SPECIFIED UNDER "PLANTING", AT NO ADDITIONAL COST TO THE OWNER.
3. IN THE EVENT THE OWNER DOES NOT CONTRACT WITH THE CONTRACTOR FOR LANDSCAPE (AND IRRIGATION) MAINTENANCE, THE CONTRACTOR IS ENCOURAGED TO VISIT THE PROJECT SITE PERIODICALLY DURING THE ONE YEAR WARRANTY PERIOD TO EVALUATE MAINTENANCE PROCEDURES BEING PERFORMED BY THE OWNER, AND SHALL NOTIFY THE OWNER IN WRITING OF MAINTENANCE PROCEDURES OR CONDITIONS WHICH THREATEN VIGOROUS AND HEALTHY PLANT GROWTH. IT IS SUGGESTED SUCH SITE VISITS SHALL BE CONDUCTED A MINIMUM OF ONCE PER MONTH FOR A PERIOD OF TWELVE (12) MONTHS FROM THE DATE OF ACCEPTANCE.

THIS ITEM HAS BEEN DIGITALLY SIGNED AND SEALED BY BENJAMIN V. JOHNSON. PLA ON THE DATE ADJACENT TO THE SIGNATURE. PRINTED COPIES OF THIS DOCUMENT ARE NOT CONSIDERED SIGNED AND SEALED AND THE SIGNATURE MUST BE VERIFIED ON ANY ELECTRONIC COPIES.

Kimley»Horn

445 24TH STREET, SUITE 200, VERO BEACH, FL 32960
PHONE: 772-794-4100
WWW.KIMLEY-HORN.COM REGISTRY NO. 35106

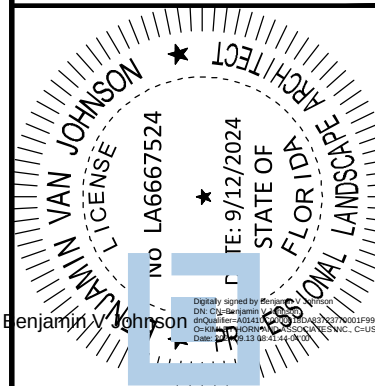

KHA PROJECT	DATE
043326005	9/3/2024
SCALE	AS SHOWN
DESIGNED BY	NF
DRAWN BY	NR
CHECKED BY	KD

LANDSCAPE NOTES & SPECIFICATIONS

OAKWOOD SOUTH
RETAIL SHOPPING
CENTER

FL

CITY OF HOLLYWOOD

SHEET NUMBER

L-204

CALL 48 HOURS
BEFORE YOU DIG

IT'S THE LAW!
DIAL 811

Know what's below.
Call before you dig.

SUNSHINE STATE ONE CALL OF FLORIDA, INC.

MATCH LINE TO SHEET L-301

INTERSTATE I-95

OAKWOOD LANE (PRIVATE ROAD)

FIELD

RECEIVING

LI-101

S-101

S-102

S-103

S-104

S-105

S-107

ELEC

WM

NO OVERHEAD POWERLINES

NORTH

GRAPHIC SCALE IN FEET

0 15 30 60

	6X9, 3 1/8" CROSSWALK VEHICULAR PAVERS FROM BELGARD PATTERN: HERRINGBONE SEE DETAIL B, SHEET L-350
	12X24, 3 1/8" PEDESTRIAN PAVERS FROM BELGARD PATTERN 1/3 RUNNING BOND, ORIENT AS SHOWN ON PLAN SEE DETAIL A, SHEET L-350
	STANDARD GREY CONCRETE WITH BROOM FINISH REFER TO CIVIL

<u>SYMBOL</u>	<u>HARDSCAPE DESCRIPTION</u>	<u>QTY</u>	<u>DETAIL</u>
<u>H-101</u>	P.I.P. PLANTER WALL	37 LF	DTL A, SHT L351
<u>H-102</u>	TREE GRATE	4	DTL D, SHT L351
<u>SYMBOL</u>	<u>LIGHTING DESCRIPTION</u>	<u>QTY</u>	<u>DETAIL</u>
<u>LI-101</u>	LANDSCAPE UPLIGHTING	25	DTL D, SHT L352
<u>SYMBOL</u>	<u>SITE FURNISHING DESCRIPTION</u>	<u>QTY</u>	<u>DETAIL</u>
<u>S-101</u>	COVERED BENCH SEATING	3	DTL A, SHT L352
<u>S-102</u>	TRASH RECEPTACLE	5	DTL C, SHT L351
<u>S-103</u>	BENCH SEATING	14	DTL B, SHT L352
<u>S-104</u>	BICYCLE RACK	7	DTL B, SHT L351
<u>S-105</u>	LARGE PLANTER	4	DTL E, SHT L351
<u>S-106</u>	INFORMATION KIOSK	2	DTL F, SHT L351
<u>S-107</u>	BOLLARD	21	DTL C, SHT L352

Professional Engineer Seal for Benjamin V. Johnson, License No. LA6667524, State of Florida, expires 9/12/2024.

KHA PROJECT	SCALE	AS SHOWN
043326005	DESIGNED BY	N
DATE	DRAWN BY	N
9/3/2024	CHECKED BY	K

SHEET NUMBER L-300	OAKWOOD SOUTH RETAIL SHOPPING CENTER CITY OF HOLLYWOOD	HARDSCAPE PLAN FL
--------------------------------------	---	--

CALL 48 HOURS
BEFORE YOU DIG

IT'S THE LAW!
DIAL 811

811


**Know what's below.
Call before you dig**

SUNSHINE STATE ONE CALL OF FLORIDA, INC.

[illegible]

Kimley»»Horn
445 24TH STREET, SUITE 200, VERO BEACH, FL 32960
PHONE: 772-794-4100
WWW.KIMLEY-HORN.COM REGISTRY NO. 35106

This document, together with the concepts and designs presented herein, is intended only for the specific purpose and client for which it was prepared. Reuse of and improper reliance on this document without written authorization and consent of the author is prohibited. The author shall be without liability to Kimley-Horn and Associates, Inc.

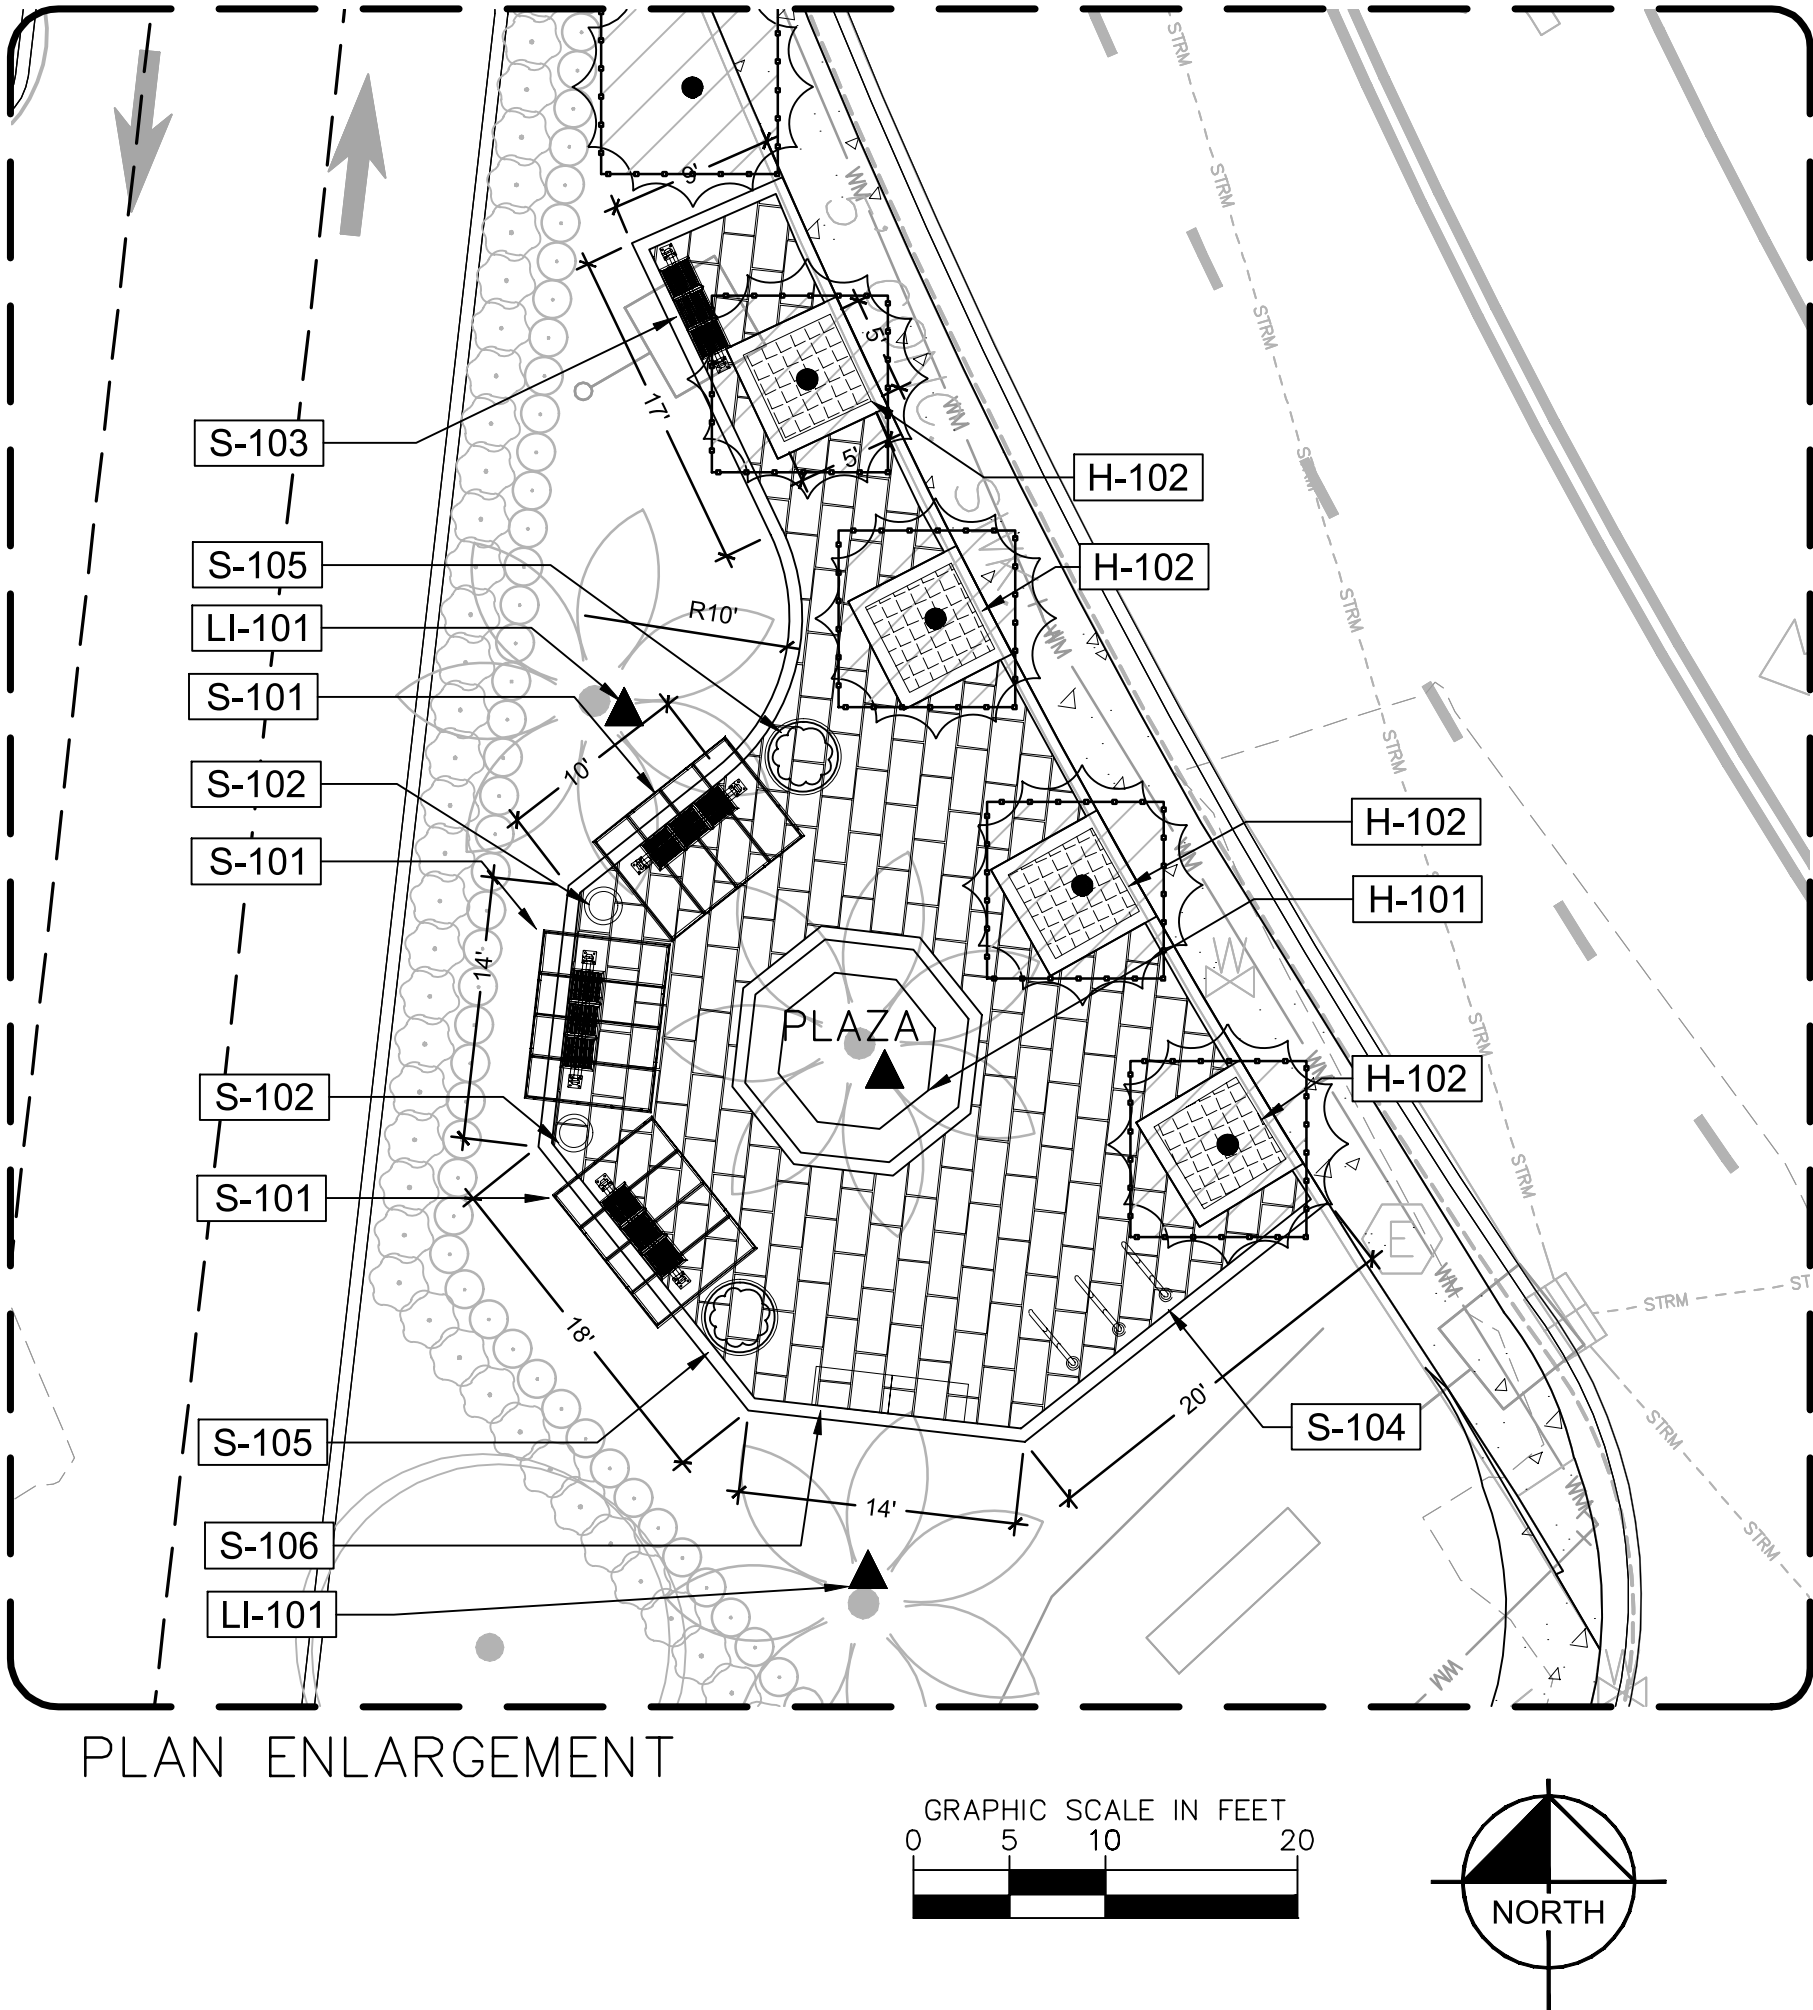

PAVING SCHEDULE

	6X9, 3 1/8" CROSSWALK VEHICULAR PAVERS FROM BELGARD PATTERN: HERRINGBONE SEE DETAIL B, SHEET L-350
	12X24, 3 1/8" PEDESTRIAN PAVERS FROM BELGARD PATTERN 1/3 RUNNING BOND, ORIENT AS SHOWN ON PLAN SEE DETAIL A, SHEET L-350
	STANDARD GREY CONCRETE WITH BROOM FINISH REFER TO CIVIL

REFERENCE NOTES SCHEDULE

SYMBOL	HARDSCAPE DESCRIPTION	QTY	DETAIL
	P.I.P. PLANTER WALL	37 LF	DTL A, SHT L351
	TREE GRATE	4	DTL D, SHT L351
SYMBOL	LIGHTING DESCRIPTION	QTY	DETAIL
	LANDSCAPE UPLIGHTING	25	DTL D, SHT L352
SYMBOL	SITE FURNISHING DESCRIPTION	QTY	DETAIL
	COVERED BENCH SEATING	3	DTL A, SHT L352
	TRASH RECEPTACLE	5	DTL C, SHT L351
	BENCH SEATING	14	DTL B, SHT L352
	BICYCLE RACK	7	DTL B, SHT L351
	LARGE PLANTER	4	DTL E, SHT L351
	INFORMATION KIOSK	2	DTL F, SHT L351
	BOLLARD	21	DTL C, SHT L352


CALL 48 HOURS
BEFORE YOU DIG

IT'S THE LAW!
DIAL 811

Know what's below.
Call before you dig.

SUNSHINE STATE ONE CALL OF FLORIDA, INC.

THIS ITEM HAS BEEN DIGITALLY SIGNED AND SEALED BY BENJAMIN V. JOHNSON, P.L.A. ON THE DATE ADJACENT TO THE SIGNATURE. PRINTED COPIES OF THIS DOCUMENT ARE NOT CONSIDERED SIGNED AND SEALED AND THE SIGNATURE MUST BE VERIFIED ON ANY ELECTRONIC COPIES.

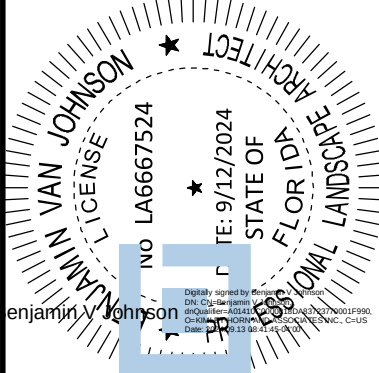

KHA PROJECT 043326005	DATE 9/3/2024
SCALE AS SHOWN	DESIGNED BY NIF
	DRAWN BY NIF
	CHECKED BY KD

OAKWOOD SOUTH
RETAIL SHOPPING
CENTER

HARDSCAPE PLAN

FL

CITY OF HOLLYWOOD

SHEET NUMBER
L-301

NO.	REVISIONS	DATE	BY

Kimley»Horn

445 24TH STREET, SUITE 200, VERO BEACH, FL 32960
PHONE: 772-794-4100
WWW.KIMLEY-HORN.COM REGISTRY NO. 35106

This document, together with the concepts and designs presented herein, as an instrument of service, is intended only for the specific purpose and client for which it was prepared. Reuse of and improper reliance on this document without written authorization and adaptation by Kinney-Horn and Associates, Inc. shall be without liability to Kinney-Horn and Associates, Inc.

 


PAVER B
6" X 9" X 2 3/8" MODULINE
PATTER: 50% SLATE FINISH: GROUND FACE
50% TITANIUM FINISH: GROUND FACE
PATTERN: HERRINGBONE W/ 8" CONCRETE HEADER BAND
(ORIENT AS SHOWN ON HARDSCAPE PLAN)

PAVERS SHALL BE SWEEPED WITH TECHNISEAL POLYMERIC SAND.

REFER TO ICPI TECHNICAL SPECIFICATION NUMBER 2 'CONSTRUCTION OF INTERLOCKING CONCRETE PAVEMENTS' FOR INSTALLATION SPECS.

1. CONTRACTOR SHALL SUBMIT DETAILED, (SIGNED AND SEALED) ENGINEERED SHOP DRAWINGS FOR REVIEW AND ACCEPTANCE BY THE CLIENT, CIVIL ENGINEER, AND LANDSCAPE ARCHITECT PRIOR TO PROCUREMENT, FABRICATION, AND INSTALLATION. PAVERS MUST MEET ALL FLORIDA BUILDING CODE SLIP COEFFICIENT REQUIREMENTS.
2. CONTRACTOR SHALL PROVIDE MOCK-UP AND SAMPLES FOR REVIEW AND ACCEPTANCE BY THE CLIENT, CIVIL ENGINEER, LANDSCAPE ARCHITECT, AND PRODUCT MANUFACTURER PRIOR TO PROCUREMENT, FABRICATION, AND INSTALLATION. MOCK-UP SHALL BE ITERATIVE AND REFINED UP TO (3) THREE TIMES BY CONTRACTOR AT NO ADDITIONAL COST TO OWNER UNTIL ACCEPTED BY CLIENT, CIVIL ENGINEER, LANDSCAPE ARCHITECT AND PRODUCT MANUFACTURER.
3. CONTRACTOR SHALL SUBMIT PRODUCT DATA FOR REVIEW AND ACCEPTANCE BY THE CLIENT, CIVIL ENGINEER, AND LANDSCAPE ARCHITECT PRIOR TO PROCUREMENT, FABRICATION, AND INSTALLATION.



SECTION AND PLAN



B) SECTION



SUNSHINE STATE ONE CALL OF FLORIDA, INC.

1

CITY OF HOLLYWOOD

SHEET NUMBER

L-350

KHA PROJECT
04333606


DATE

9/3/2024

SIGNED BY	NR
-----------	----

AVIN BY	NR
---------	----

This document, together with the concepts and designs presented herein, as an instrument of service, is intended only for the specific purpose and client for which it was prepared. Reuse of and improper reliance on this document without written authorization and assapation by Kimley-Horn and Associates, Inc. shall be without liability to Kimley-Horn and Associates, Inc.

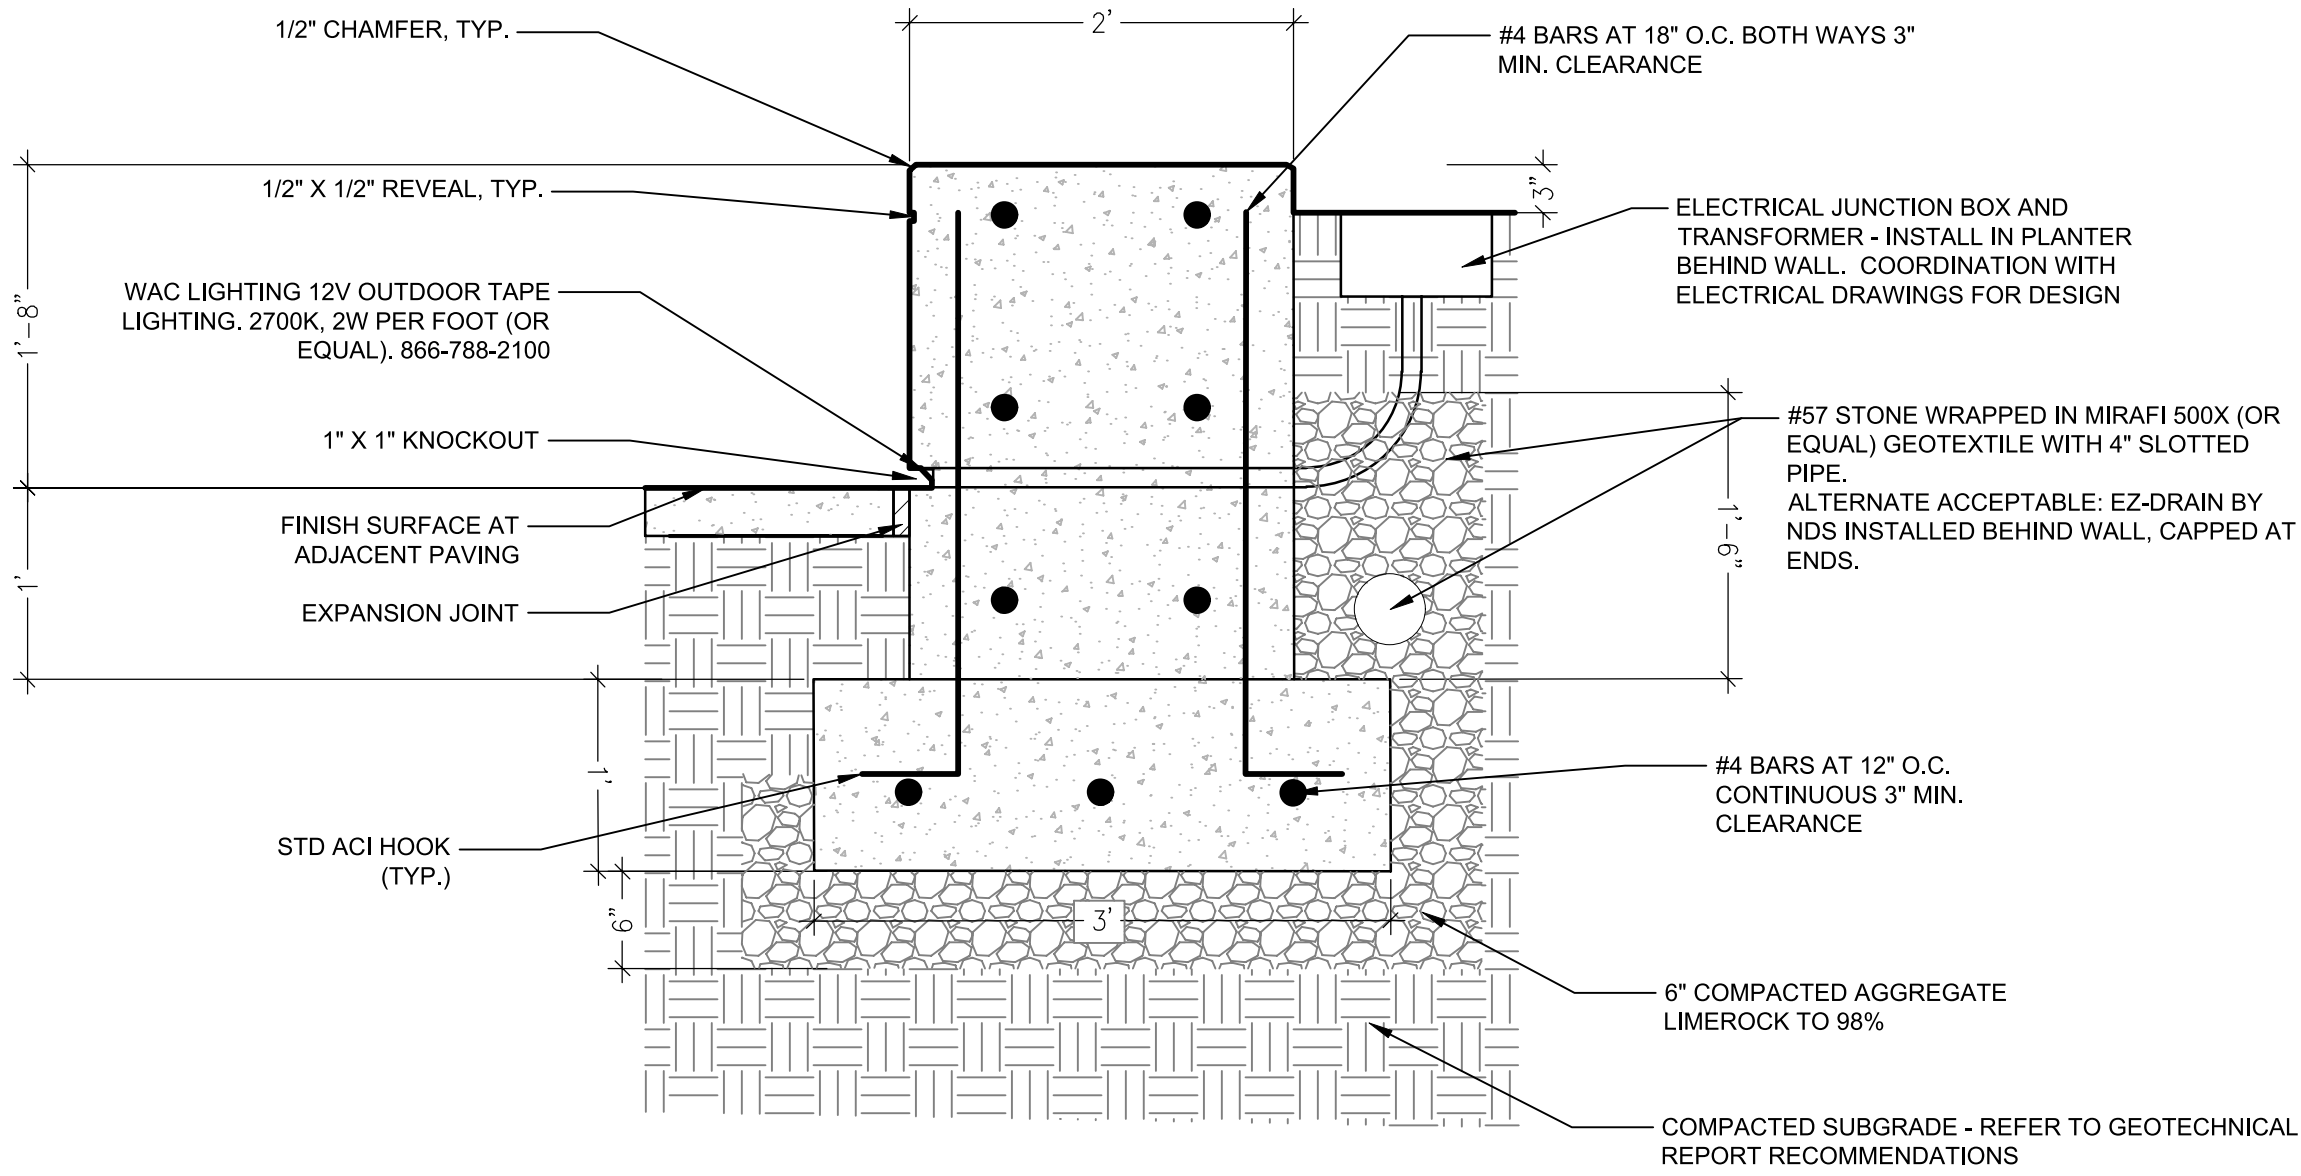

A 20" P.I.P. CONCRETE PLANTER WALL
SECTION

NOT TO SCALE


MANUFACTURER: KEYSTONE RIDGE
www.keystoneridgedesigns.com
(724) 284-1213

MODEL: HARMONY - HIID-32

SIZE: LENGTH: 31"
WIDTH: 31"
HEIGHT: 34"

COLOR: BRONZE OR OWNER APPROVED

NOTES: INSTALL PER MANUFACTURER'S SPECIFICATIONS
EMBEDDED MOUNT PER MANUFACTURER.

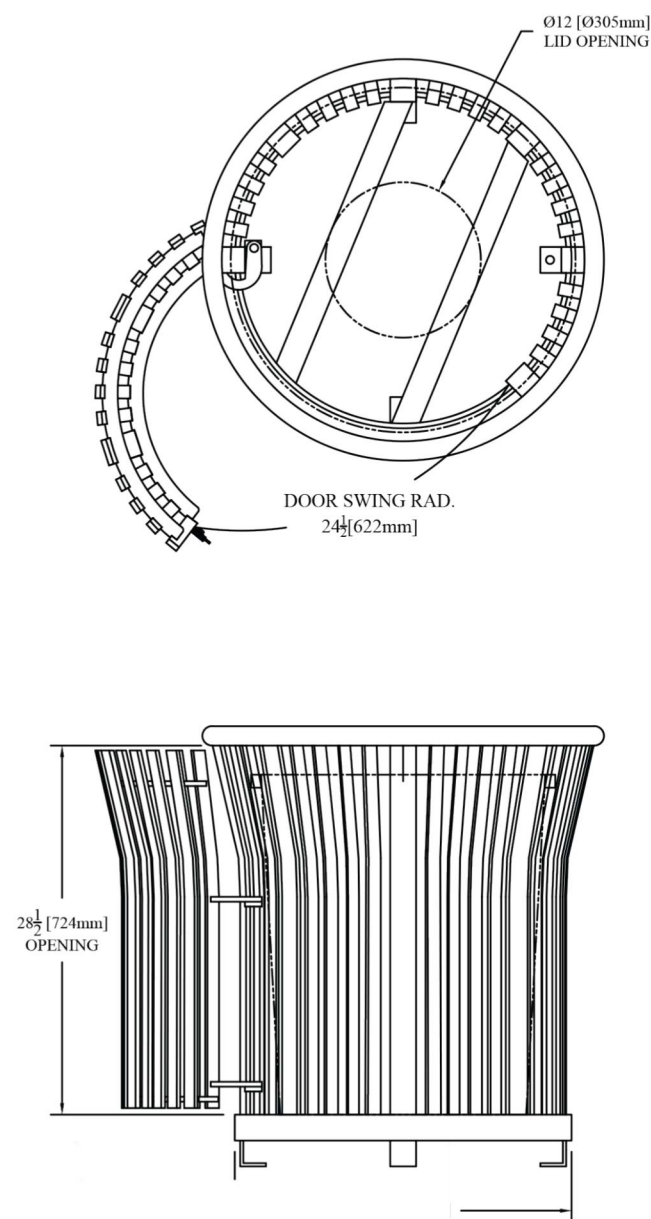

C TRASH AND RECYCLE RECEPTACLE

NOT TO SCALE

MANUFACTURER: JAY SCOTTS
joyscotts.com
(954) 922 - 3939

MODEL: SEE BELOW

SIZES: SMALL POT: ALZIRA 23"x23"x22"
LARGE POT: ALZIRA 36"x36"x34"

COLOR: TO BE SELECTED BY OWNER FROM MANUFACTURER'S FULL RANGE


NOTES: INSTALL 12" DEEP DRAINAGE STONE IN BOTTOM OF POT WITH LANDSCAPE FILTER FABRIC FOR MEDIAN SEPARATION. ALL POTS TO BE FURNISHED WITH DRAINAGE HOLES.



*NOTE:
1. CONTRACTOR SHALL SUBMIT PRODUCT DATA FOR REVIEW AND ACCEPTANCE BY THE CLIENT, CIVIL ENGINEER, AND LANDSCAPE ARCHITECT PRIOR TO PROCUREMENT, FABRICATION, AND INSTALLATION.

E FREESTANDING PLANTER POT

NOT TO SCALE

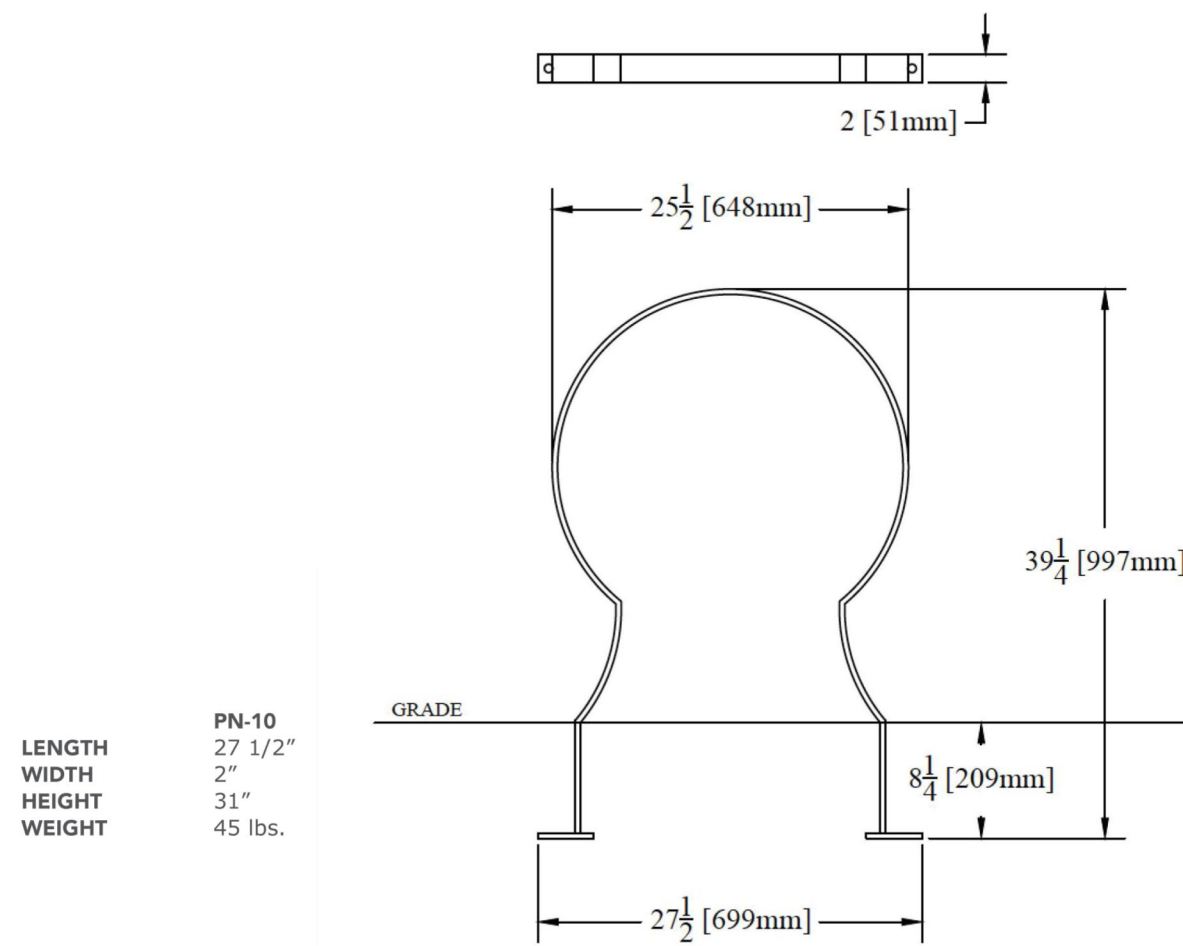

LENGTH: 27 1/2"
WIDTH: 2"
HEIGHT: 31"
WEIGHT: 45 lbs.

MANUFACTURER: KEYSTONE RIDGE
www.keystoneridgedesigns.com
(724) 284-1213

MODEL: PENN PN-10
(WITH CUSTOM LOGO MODIFICATION.
COORDINATE WITH OWNER FOR ARTWORK)


SIZE: 2 SPOTS
LENGTH: 27.5"
WIDTH: 2"
HEIGHT: 31"

COLOR: CHARCOAL. SUBMIT CUT SHEET AND COLOR CHART FOR APPROVAL.

NOTES: EMBEDDED MOUNT SET IN CONCRETE PAD, PER MANUFACTURER

B BIKE RACK

NOT TO SCALE

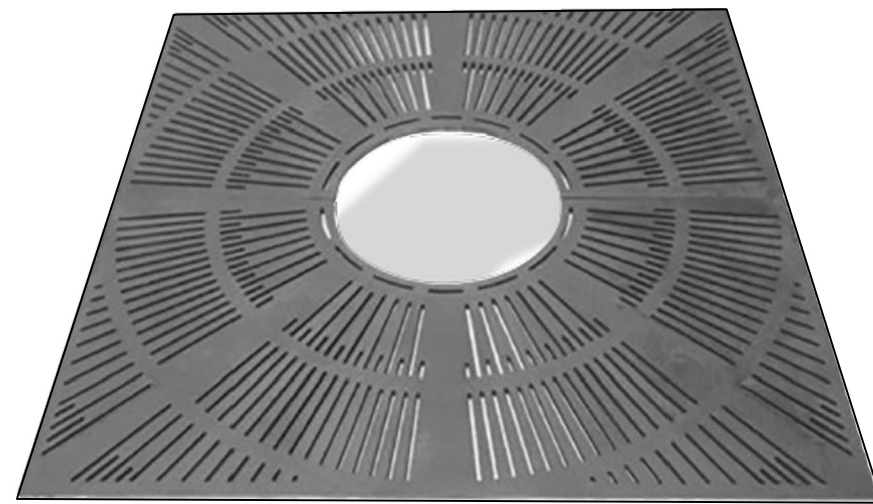

MANUFACTURER: KEYSTONE RIDGE
www.keystoneridgedesigns.com
(724) 284-1213

MODEL: HARMONY - HIID-32

SIZE: LENGTH: 31"
WIDTH: 31"
HEIGHT: 34"

COLOR: BRONZE OR OWNER APPROVED

NOTES: INSTALL PER MANUFACTURER'S SPECIFICATIONS
EMBEDDED MOUNT PER MANUFACTURER.

D TREE GRATE

NOT TO SCALE

MANUFACTURER: Floor Stands
floorstands.com
(844) 409 - 1131

MODEL: SEE BELOW

SIZES: Eco-Design 6-sided Multi-View Kiosk

COLOR: TO BE APPROVED BY OWNER

NOTES: INSTALL PER MANUFACTURER'S IN GROUND POST MOUNT OPTION WITH LED LIGHTING.



F INFORMATION KIOSK

NOT TO SCALE

CALL 48 HOURS
BEFORE YOU DIG

IT'S THE LAW!
DIAL 811



SUNSHINE STATE ONE CALL OF FLORIDA, INC.

Kimley»Horn

445 24TH STREET, SUITE 200, VERO BEACH, FL 32960
PHONE: 772-794-4100
WWW.KIMLEY-HORN.COM

MANUFACTURER
DETAILS

OAKWOOD SOUTH
RETAIL SHOPPING
CENTER

FL

CITY OF HOLLYWOOD

SHEET NUMBER
L-351

REVISIONS
No. DATE BY

This document, together with the concepts and designs presented herein, is intended only for the specific purpose and client for which it was prepared. Reuse of and improper reliance on this document without written authorization and adaptation by Kimley-Horn and Associates, Inc. shall be without liability to Kimley-Horn and Associates, Inc.

Kaleidoscope OS


Shelter, Two Post, Offset Canopy, Solid panels, Below Grade Mount

Product Drawing


landscapeforms®

www.landscapeforms.com Ph: 800.521.2546

ATTACHED PRESIDIO BACKLESS SEATING, NO ARMS; LOW VOLTAGE LIGHTING

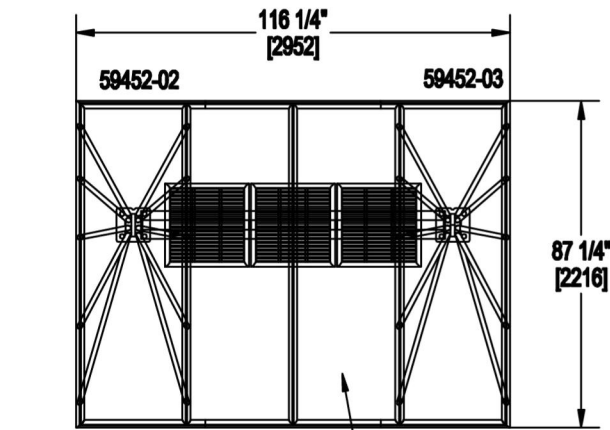

SOLID CANOPY PANELS

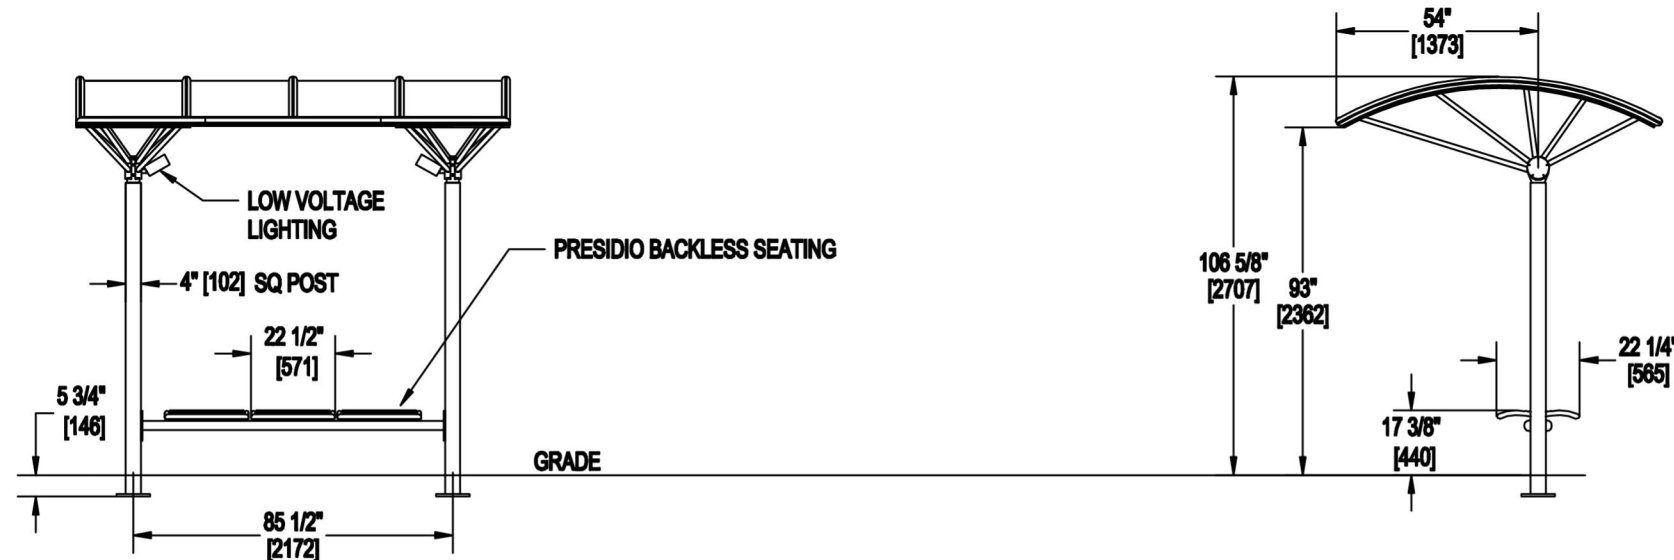

Drawing: KA540-08
Date: 05/20/2011
Dimensions are in Inches(mm)
U.S. Patent Nos. D420,812; D421,132; D412,993; D413,314

CONFIDENTIAL DRAWING INFORMATION CONTAINED HEREIN IS THE PROPERTY OF LANDSCAPE FORMS, INC. INTENDED USE IS LIMITED TO DESIGN PROFESSIONALS SPECIFYING LANDSCAPE FORMS, INC. PRODUCTS AND THEIR DIRECT CLIENTS. DRAWING IS NOT TO BE COPIED OR DISCLOSED TO OTHERS WITHOUT THE CONSENT OF LANDSCAPE FORMS, INC. © 2011 LANDSCAPE FORMS, INC. ALL RIGHTS RESERVED.

NOTE:
SEE KALEIDOSCOPE INSTALLATION
GUIDE FOR FOOTING DETAILS.

LOW VOLTAGE LIGHTING OPTION:
WIRING AND BULB NOT INCLUDED

APPROVED
REVISE AND RESUBMIT
REJECTED
COMMENTS MADE ON THESE SUBMITTALS ARE
FOR INFORMATION ONLY. ANY CHANGES REQUIRE
RE-SUBMITTAL AND APPROVAL. CUSTOMER IS
RESPONSIBLE FOR CONFIRMING ALL QUANTITIES,
DIMENSIONS, AND INSTALLATION TECHNIQUES.
BY: _____ DATE: _____


MANUFACTURER: LANDSCAPE FORMS
www.landscapeforms.com
(800) 521-2546

MODEL: Kaleidoscope
Backless Presidio Seat

SIZE: 1 Bay
LENGTH: 116 1/4"
WIDTH: 87 1/4"
HEIGHT: 106 1/2"

COLOR: BRONZE. SUBMIT CUT SHEET AND
COLOR CHART FOR APPROVAL.

NOTES: BELOW GRADE MOUNT PER
MANUFACTURER

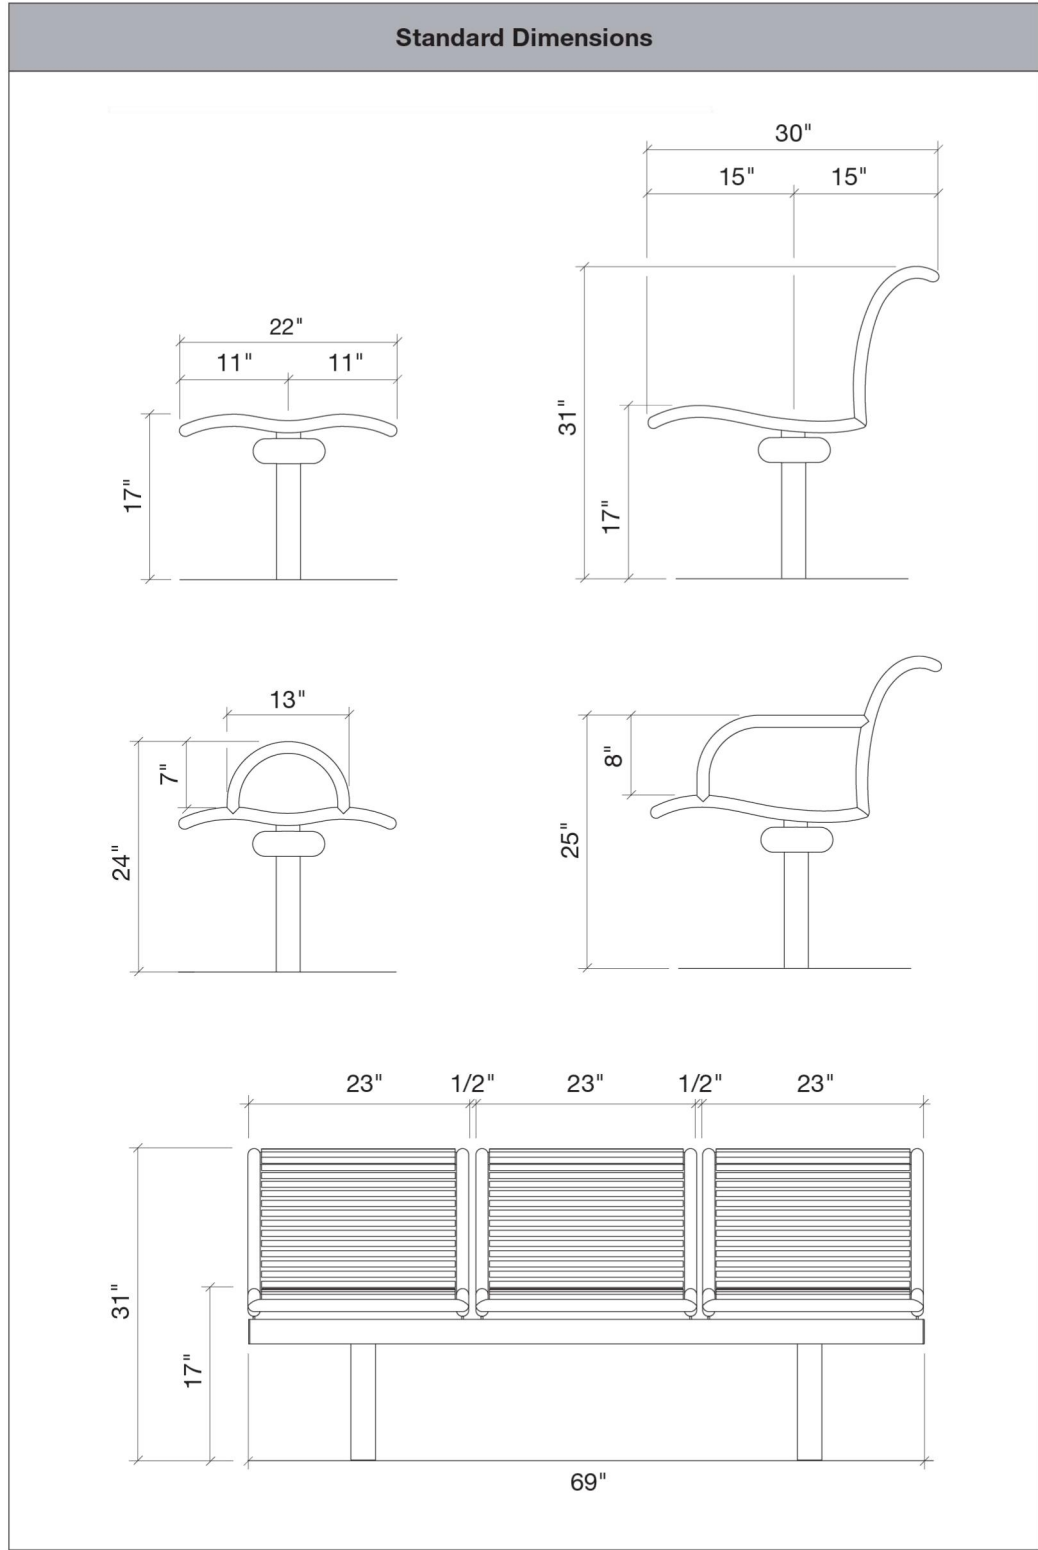

MANUFACTURER: LANDSCAPE FORMS
www.landscapeforms.com
(800) 521-2546

MODEL: Kaleidoscope
Backless Presidio Seat

SIZE: 1 Bay
LENGTH: 116 1/4"
WIDTH: 87 1/4"
HEIGHT: 106 1/2"

COLOR: BRONZE. SUBMIT CUT SHEET AND
COLOR CHART FOR APPROVAL.

NOTES: BELOW GRADE MOUNT PER
MANUFACTURER



A COVERED BENCH SEATING

NOT TO SCALE

B BENCH SEATING

NOT TO SCALE

page 2

POWER AND LUMENS

Light Engine	TCRS5	TCRS8	TCRL15	TCRL20	TCRL26	
Power (Watts)	5.0	8.0	12.0	17.6	25.1	
Input Current @ 120V (A)	0.04	0.07	0.10	0.15	0.22	
Input Current @ 277V (A)	0.02	0.03	0.05	0.07	0.10	
Configuration						
Spot (20°)	4000K/5000K Lumens	530	812	1,500	2,039	2,718
	3000K Lumens	512	785	1,450	1,971	2,628
Medium (30°)	4000K/5000K Lumens	552	846	1,630	2,215	2,953
	3000K Lumens	533	818	1,575	2,141	2,854
Wide (50°)	4000K/5000K Lumens	561	860	1,657	2,251	3,002
	3000K Lumens	542	831	1,602	2,176	2,902

ORDERING INFORMATION

Sample Number: TCRSS5-WH-7050

Product Family *	Light Engine	Distribution
TCRS-Tracer Flood Small LED	TCRS 6x30W, 550 Nominal Lumens	SxSpot
TCRL-Tracer Flood Large LED	TCRL 8x30W, 850 Nominal Lumens	MxMedium WxWide
	TCRL 15x15W, 1,600 Nominal Lumens	
	26x20W, 2,200 Nominal Lumens	
	26x26W, 2,900 Nominal Lumens	

Options (Add as Suffix):¹

[Blank]=Carbon Bronze (Standard)
BK=Black
VG=Verde Green
WH=White
7050=70 CRI / 5000K CCT
7050=70 CRI / 5000K CCT

NOTES: 1. DesignLights Consortium® Qualified. Refer to www.designlights.org Qualified Products List under Family Models for details. 2. Extended lead times apply to any options selected.

STOCK ORDERING INFORMATION

Stock SKUs	
Small TCRS5-Tracer Small 5W, 550 lumens, Spot Distribution TCRS5M-Tracer Small 5W, 550 lumens, Medium Distribution TCRS5W-Tracer Small 5W, 550 lumens, Wide Distribution TCRS8M-Tracer Small 8W, 850 lumens, Spot Distribution TCRS8W-Tracer Small 8W, 850 lumens, Medium Distribution TCRS8W-Tracer Small 8W, 850 lumens, Wide Distribution	Large TCRL5M-Tracer Large 15W, 1,600 lumens, Spot Distribution TCRL5M-Tracer Large 15W, 1,600 lumens, Medium Distribution TCRL20M-Tracer Large 20W, 2,200 lumens, Medium Distribution TCRL26M-Tracer Large 26W, 2,900 lumens, Spot Distribution TCRL26M-Tracer Large 26W, 2,900 lumens, Medium Distribution

NOTES: Options not available with stock products. Refer to standard ordering information to add options. Stock fixture is 4000K, dimming, 120-277V, carbon bronze only.

TCRS / TCRL TRACER FLOOD

LUMEN MAINTENANCE		
Ambient Temperature	TM-21 Lumen Maintenance (60,000 Hours)	Theoretical L70 (Hours)
Up to 40°C	90%	153,000

LUMEN MULTIPLIER	
Ambient Temperature	Lumen Multiplier
10°C	1.02
15°C	1.01
25°C	1.00
40°C	0.97

MANUFACTURER: Cooper Lighting Solutions
www.designlights.com
(770) 486-4800

MODEL: Lumark Flood Light
TCRL20M

COLOR: CARBON BRONZE. SUBMIT CUT
SHEET AND COLOR CHART FOR
APPROVAL.

NOTES: BELOW GRADE MOUNT PER
MANUFACTURER



TCRS / TCRL
TRACER

Missing or invalid reference

File: I:\Publix\2024 Publix Standards\5-40-MCCUE BOLLARD DETAILS.pdf

Sheet: 1

C BOLLARD

NOT TO SCALE

D LANDSCAPE LIGHTING

NOT TO SCALE

COOPER
Lighting Solutions

Cooper Lighting Solutions
1121 Highway 8 South
Peachtree City, GA 30089
P: 770.486.4800
www.cooperlighting.com

Specifications and
dimensions subject to
change without notice.

TD506032EN
September 30, 2019 9:40 AM

CALL 48 HOURS
BEFORE YOU DIG

IT'S THE LAW!
DIAL 811

811
Know what's below.
Call before you dig.

SUNSHINE STATE ONE CALL OF FLORIDA, INC.

MANUFACTURER
DETAILS

OAKWOOD SOUTH
RETAIL SHOPPING
CENTER
CITY OF HOLLYWOOD

SHEET NUMBER
L-352

KHA PROJECT
043326005

DATE
9/3/2024

SCALE AS SHOWN

DESIGNED BY NIF

DRAWN BY NIF

CHECKED BY KD

FL





REVISIONS

No.

DATE

BY

ACM-1	RAINSCREEN METAL PANEL SYSTEM MANUF: CITADEL OR EQUAL PRODUCT: ENVELOPE 2000/RS OR EQUAL COLOR: MATCH KAWNEER HARTFORD GREEN
ACM-3	ACM PANELS - ALPOLIC COLOR: TO MATCH KAWNEER DARK BRONZE
BRK-1	3/4" MODULAR THIN BRICK REFER TO SPECIFICATION FOR ACCEPTABLE MANUFACTURERS MORTAR - SPEC MIX 3M250 'ANTIQUE WHITE'
BRK-2	3/4" MODULAR THIN BRICK BELDEN BRICK COLOR: BLACK DIAMOND VELOUR MORTAR - SPEC MIX 3M800 'BLACK'
CAP-1	COLUMN CAPITAL SUPPLIED BY VENDOR #24, INSTALLED BY G.C. COLOR: MATCH SW 0028 CAEN STONE
CONC	CAST IN PLACE CONCRETE WITH PARGED HAND RUBBED FINISH
CMU-3	SMOOTH-FACED, STANDARD GRAY DRYBLOCK, SEE SPEC FINISH + POLYMER MODIFIED CEMENT PARGE, SEE SPEC
CNPY-2	MAPES PREFABRICATED METAL, CANOPY W/ THE RODS OR APPROVED EQUAL COLOR - TO MATCH KAWNEER DARK BRONZE
CPNG-2	PREFINISHED METAL COPING, SEE SPECIFICATIONS COLOR - TO MATCH KAWNEER DARK BRONZE
DOOR-1	ALUMINUM SLIDING DOOR, SEE SPECIFICATIONS - COLOR: KAWNEER DARK BRONZE
DS-1	PRE-FINISHED METAL DOWNSPOUT - COLOR: TO MATCH KAWNEER DARK BRONZE
EIFS-1	1 1/2" EXTERIOR INSULATION FINISH SYSTEM, SEE SPECIFICATIONS COLOR + MATCH COLOR #449 BUCKSKIN, PEBBLE FINE FINISH
GLAZ-1	EXTERIOR CURTAINWALL COLOR= KAWNEER DARK BRONZE
LIGHT	EXTERIOR LIGHT FIXTURE, REFER TO REFLECTED CEILING AND ELECTRICAL PLANS, TYP.
PAINT-1	EXTERIOR PAINT, SEE SPECIFICATIONS COLOR = (P-18)
PAINT-2	EXTERIOR PAINT, SEE SPECIFICATIONS COLOR + MATCH RED BRICK (P-32) DSG BELDON
PAINT-3	EXTERIOR PAINT, SEE SPECIFICATIONS COLOR = TO MATCH (EIFS-2)
SIGN-1	INDIVIDUAL LETTER SIGNAGE W/ INTERNALLY ILLUMINATED LETTERS, SUPPLIED AND INSTALLED BY VENDOR #8
FILM	WINDOW SECURITY FILM, REFER TO A5.2

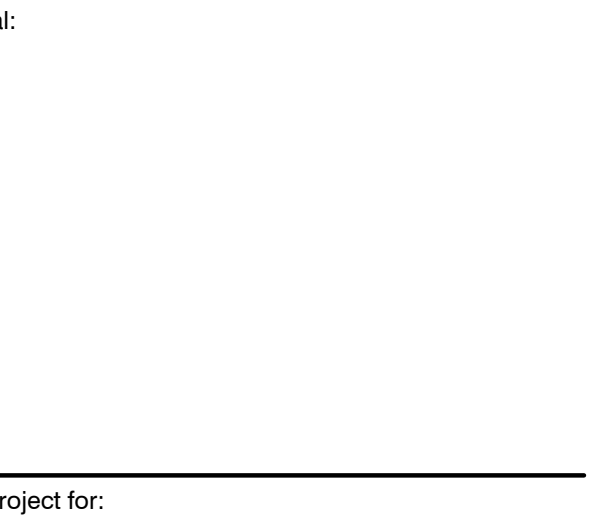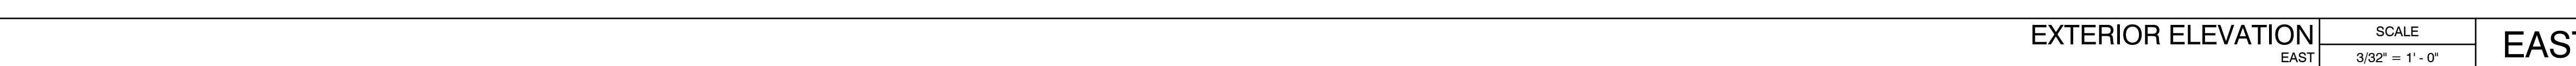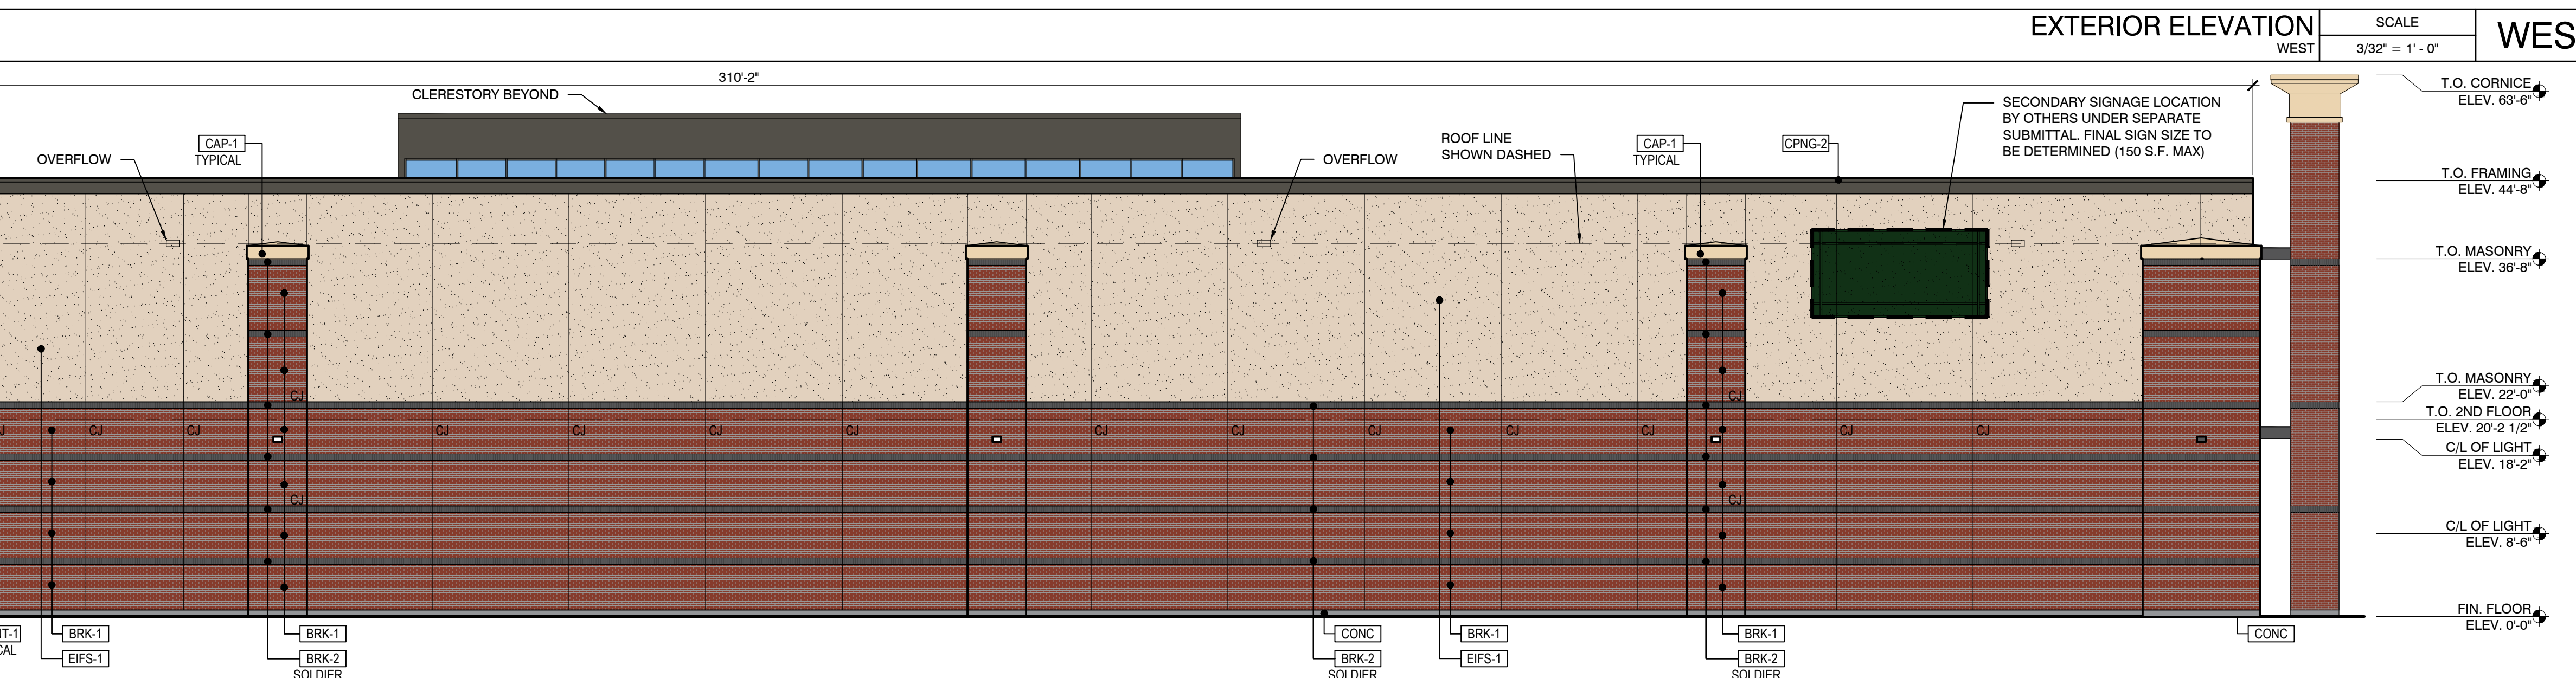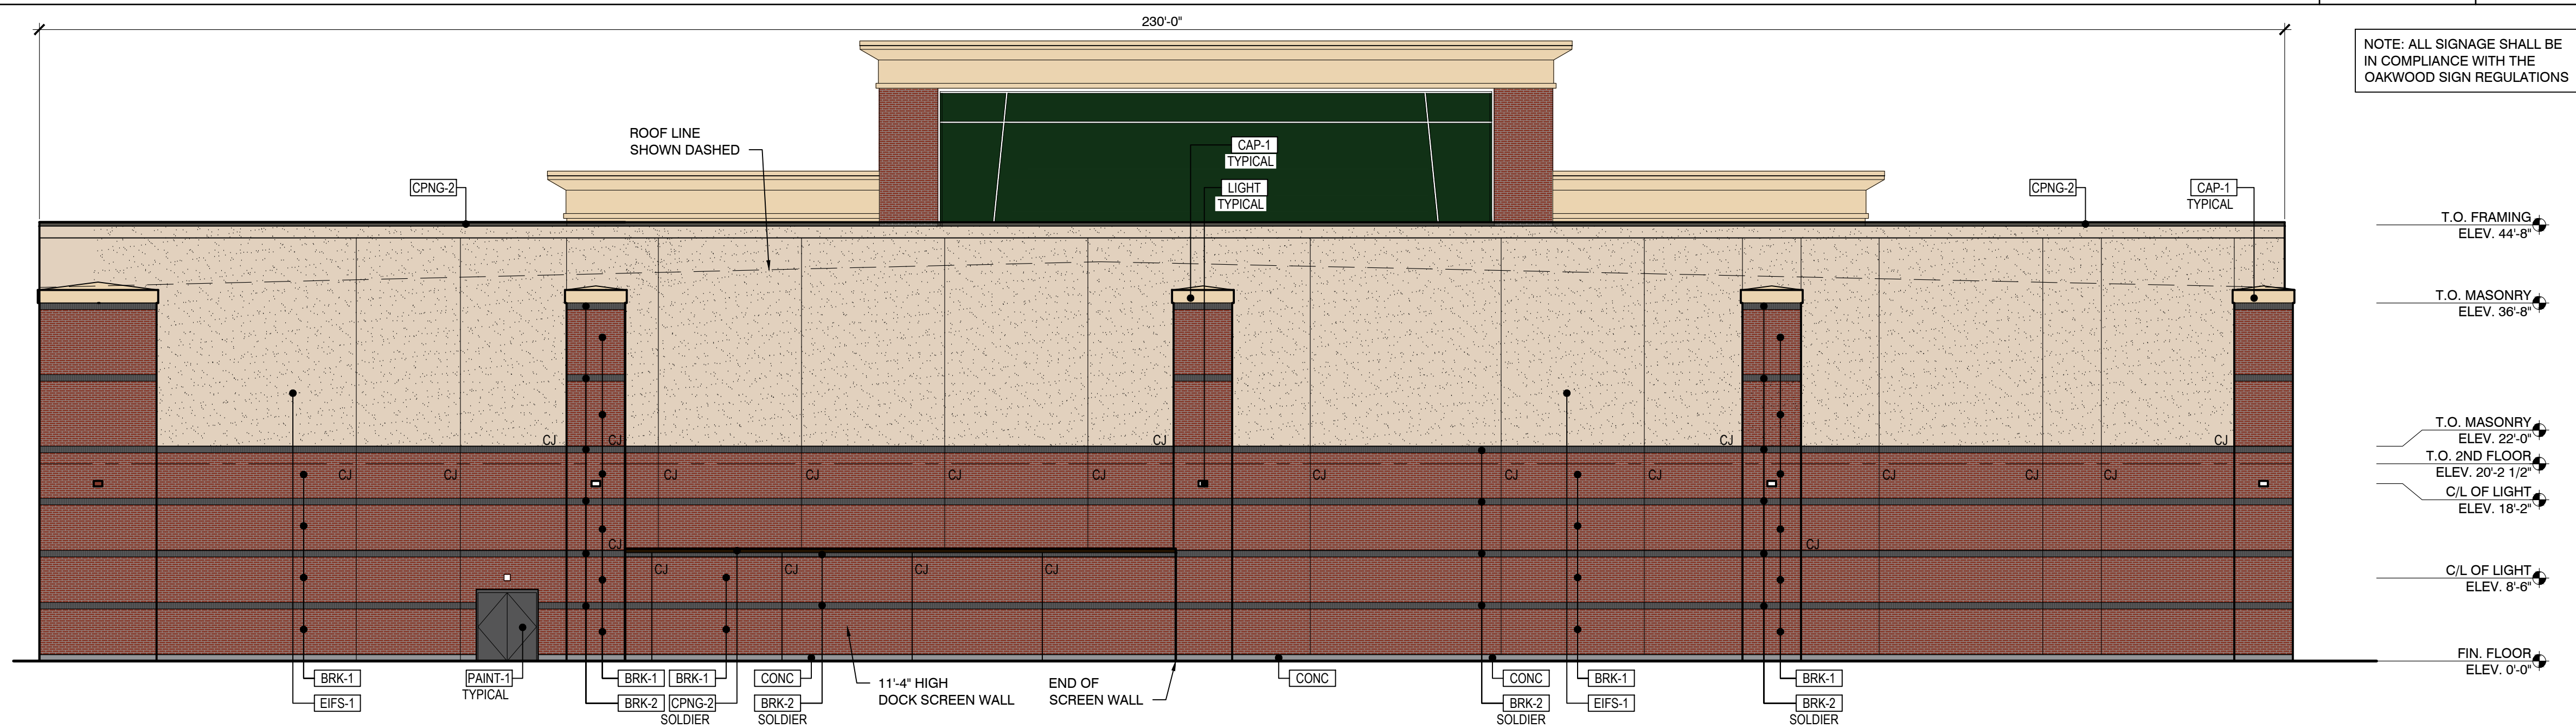

RETAIL REDEVELOPMENT
OAKWOOD SOUTH RETAIL SHOPPING CENTER
2800 OAKWOOD BLVD.
HOLLYWOOD, FL 33020

nt:

KIMCO REALTY

OAKWOOD BOULEVARD, SUITE 70
HOLLYWOOD, FL 33020

PATIENT REVIEW 09-13-2024

Description	Date
Project No.:	24.251.01
Drawn By:	-
Reviewed By:	-
Scale:	AS NOTED
Date:	09-13-2024
Drawn name:	
Sheet Title:	

PROPOSED EXTERIOR ELEVATIONS

ent #:

A300

ICG ARCHITECTURE 2024 ALL RIGHTS RESERVED



mcgarchitecture.com

CLEVELAND
DENVER
GLENDORA
IRVINE
ORLANDO
PHOENIX
SAN FRANCISCO

Seal:

A Project for:

RETAIL REDEVELOPMENT
OAKWOOD SOUTH RETAIL SHOPPING CENTER
2800 OAKWOOD BLVD.
HOLLYWOOD, FL 33020

Client:

KIMCO REALTY

1 OAKWOOD BOULEVARD, SUITE 70
HOLLYWOOD, FL 33020

Revisions:
CLIENT REVIEW 07-09-2024

No.	Description	Date
Project No.:		24.251.01
Drawn By:		
Reviewed By:		
Scale:		
Date:		09-13-2024
Filename:		
Sheet Title:		

PROPOSED
EXTERIOR RENDERING

Sheet #:



EXTERIOR RENDERING
SCENE 1

SCALE
N/A



mcgarchitecture.com

CLEVELAND
DENVER
GLENDORA
IRVINE
ORLANDO
PHOENIX
SAN FRANCISCO

Seal:

A Project for:

RETAIL REDEVELOPMENT
OAKWOOD SOUTH RETAIL SHOPPING CENTER
2800 OAKWOOD BLVD.
HOLLYWOOD, FL 33020

Client:

KIMCO REALTY

1 OAKWOOD BOULEVARD, SUITE 70
HOLLYWOOD, FL 33020

Revisions:

CLIENT REVIEW 07-09-2024

No. Description Date

Project No.: 24.251.01

Drawn By: -

Reviewed By: -

Scale: -

Date: 09-13-2024

Filename: -

Sheet Title:

PROPOSED
EXTERIOR RENDERING

Sheet #:



EXTERIOR RENDERING
SCENE 2

SCALE
N/A

2

© MCG ARCHITECTURE 2024 ALL RIGHTS RESERVED



mcgarchitecture.com

CLEVELAND
DENVER
GLENDORA
IRVINE
ORLANDO
PHOENIX
SAN FRANCISCO

Seal:

A Project for:

RETAIL REDEVELOPMENT
OAKWOOD SOUTH RETAIL SHOPPING CENTER
2800 OAKWOOD BLVD.
HOLLYWOOD, FL 33020

Client:

KIMCO REALTY

1 OAKWOOD BOULEVARD, SUITE 70
HOLLYWOOD, FL 33020

Revisions:	
CLIENT REVIEW	07-09-2024

No.	Description	Date
Project No.:		24.251.01
Drawn By:		-
Reviewed By:		-
Scale:		-
Date:		09-13-2024
Filename:		
Sheet Title:		

PROPOSED
EXTERIOR RENDERING

Sheet #:



EXTERIOR RENDERING
SCENE 3

SCALE
N/A



mcgarchitecture.com

CLEVELAND
DENVER
GLENDORA
IRVINE
ORLANDO
PHOENIX
SAN FRANCISCO

Seal:

A Project for:

RETAIL REDEVELOPMENT
OAKWOOD SOUTH RETAIL SHOPPING CENTER
2800 OAKWOOD BLVD.
HOLLYWOOD, FL 33020

Client:

KIMCO REALTY

1 OAKWOOD BOULEVARD, SUITE 70
HOLLYWOOD, FL 33020

Revisions:
CLIENT REVIEW 07-09-2024

No.	Description	Date
Project No.:		24.251.01
Drawn By:		-
Reviewed By:		-
Scale:		-
Date:		09-13-2024
Filename:		
Sheet Title:		

PROPOSED
EXTERIOR RENDERING

Sheet #:




EXTERIOR RENDERING
SCENE 4

SCALE
N/A

OAKWOOD PLAZA SOUTH PROPOSED PHOTOMETRIC PLAN

SCALE: NTS

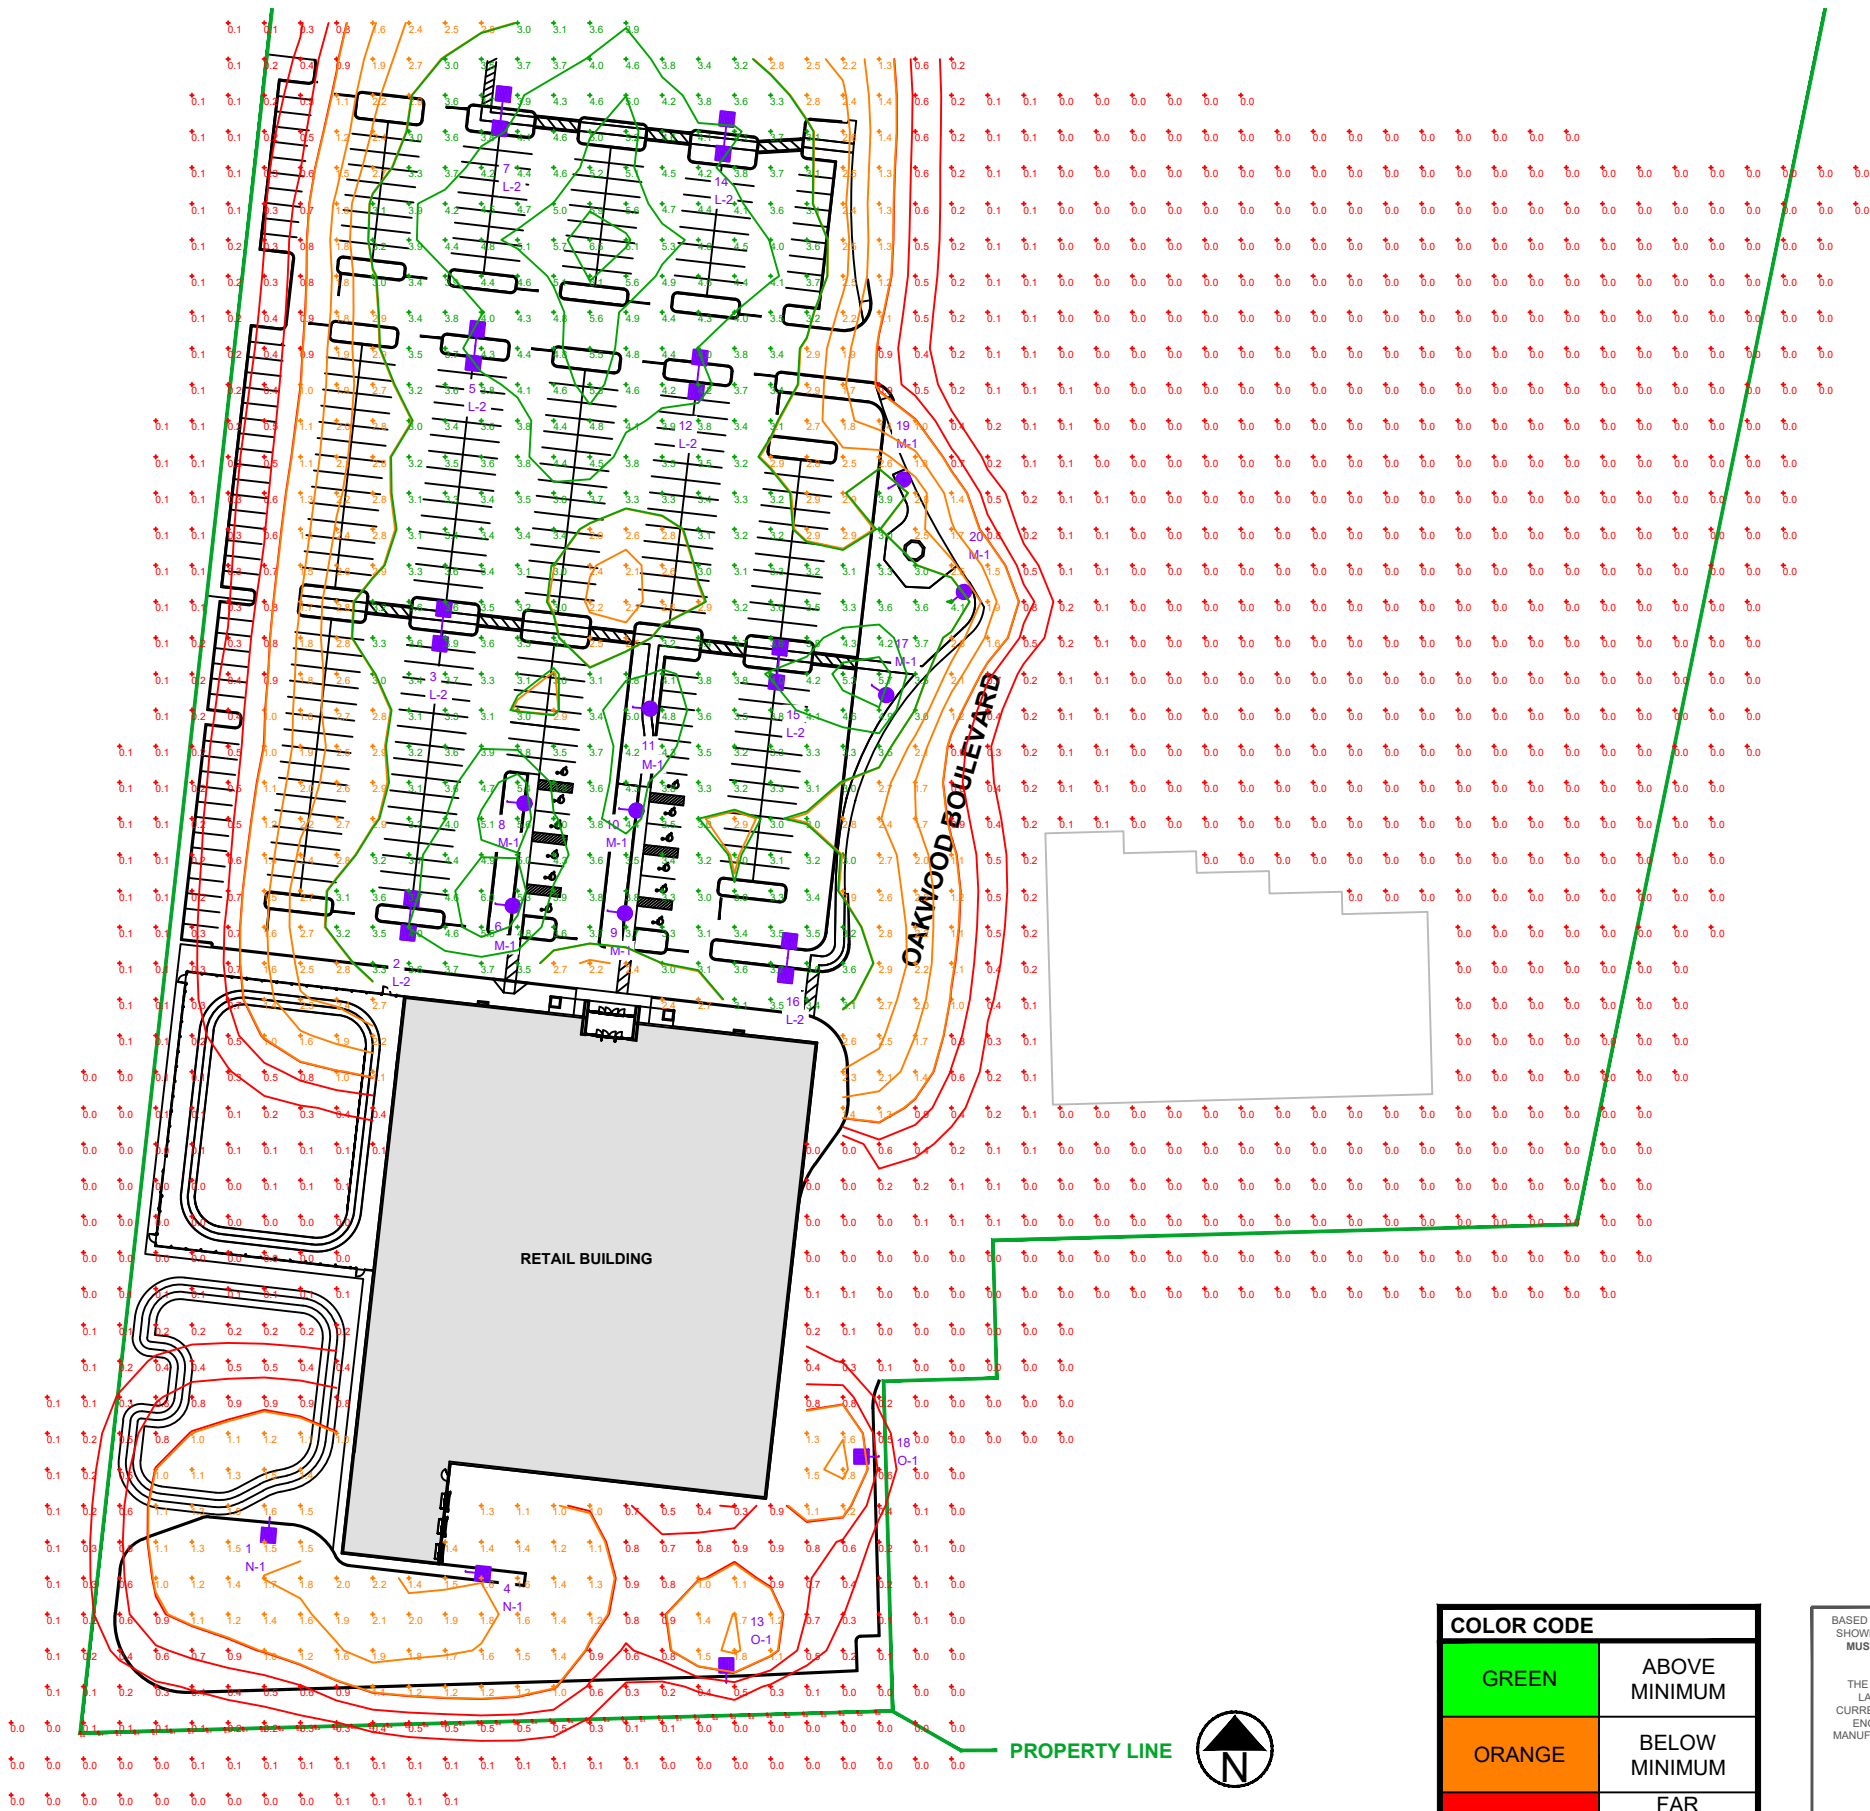

COLOR CODE	
GREEN	ABOVE MINIMUM
ORANGE	BELOW MINIMUM
RED	FAR BELOW MINIMUM

BASED ON THE INFORMATION PROVIDED, ALL DIMENSIONS AND LUMINAIRE LOCATIONS SHOWN REPRESENT RECOMMENDED POSITIONS. THE ENGINEER AND/OR ARCHITECT MUST DETERMINE APPLICABILITY OF THE LAYOUT TO EXISTING OR FUTURE FIELD CONDITIONS.

THE LIGHTING PATTERN REPRESENTS ILLUMINATION LEVELS CALCULATED FROM LABORATORY DATA TAKEN UNDER THE CONTROLLED CONDITIONS UTILIZING CURRENT INDUSTRY STANDARD LAMP RATINGS IN ACCORDANCE WITH ILLUMINATING ENGINEERING SOCIETY APPROVED METHODS. ACTUAL PERFORMANCE OF ANY MANUFACTURER'S LUMINAIRE MAY VARY DUE TO VARIATION IN ELECTRICAL VOLTAGE, TOLERANCE IN LAMPS, AND OTHER VARIABLE FIELD CONDITIONS.

FOR ADDITIONAL LIGHTING INFORMATION CONTACT:

On-Site Lighting & Survey, LLC
PH: 763.684.1548

On-Site Lighting & Survey, LLC

1111 HIGHWAY 25 NORTH
SUITE 201
BUFFALO MN 55313

PH:763.684.1548
FAX:763.682.9048



OAKWOOD PLAZA SOUTH

2910 OAKWOOD BLVD
HOLLYWOOD, FL 33020

#	DATE	INIT	DESCRIPTION
1	07.09.2024	DMW	LANDSCAPING CONFLICTS

PROPOSED PHOTOMETRIC PLAN

111500

DESIGN LEVEL	07.02.2024
AGI	3
CAD	D.M.WARZECKA
SHEET#	SL200
REV #:	1

OAKWOOD PLAZA SOUTH PROPOSED SCHEDULES

On-Site Lighting
& Survey, LLC

1111 HIGHWAY 25 NORTH
SUITE 201
BUFFALO MN 55313

PH:763.684.1548
FAX:763.682.9048



OAKWOOD
PLAZA SOUTH

2910 OAKWOOD BLVD
HOLLYWOOD, FL 33020

ENGINEER INFO

ENGINEER SEAL

REVISIONS

SHEET DESCRIPTION

PROJECT #

DESIGN
LEVEL

AGI

CAD

SHEET#:

#	DATE	INIT	DESCRIPTION
1	07.09.2024	DMW	LANDSCAPING CONFLICTS

PROPOSED
SCHEDULES

111500

07.02.2024

3

D.M.WARZECKA

D.M.WARZECKA

SL201

REV #: 1

LPD AREA SUMMARY				
Label	Area	Total Watts	LPD	Perimeter
MAIN PARKING	114110	5071	0.044	1884

CALCULATION SUMMARY							
Label	Avg	Max	Min	Avg/Min	Max/Min	# Pts	%PtsRange
ALL CALC POINTS AT GRADE	1.07	6.5	0.0	N.A.	N.A.	1743	N.A.
PROPERTY LINE - RESIDENTIAL	0.20	0.5	0.0	N.A.	N.A.	45	N.A.
MAIN PARKING	3.62	6.5	1.5	2.41	4.33	283	79.9

COLOR CODE	
GREEN	ABOVE MINIMUM
ORANGE	BELOW MINIMUM
RED	FAR BELOW MINIMUM

BASED ON THE INFORMATION PROVIDED, ALL DIMENSIONS AND LUMINAIRE LOCATIONS SHOWN REPRESENT RECOMMENDED POSITIONS. THE ENGINEER AND/OR ARCHITECT MUST DETERMINE APPLICABILITY OF THE LAYOUT TO EXISTING OR FUTURE FIELD CONDITIONS.

THE LIGHTING PATTERN REPRESENTS ILLUMINATION LEVELS CALCULATED FROM LABORATORY DATA TAKEN UNDER THE CONTROLLED CONDITIONS UTILIZING CURRENT INDUSTRY STANDARD LAMP RATINGS IN ACCORDANCE WITH ILLUMINATING ENGINEERING SOCIETY APPROVED METHODS. ACTUAL PERFORMANCE OF ANY MANUFACTURER'S LUMINAIRE MAY VARY DUE TO VARIATION IN ELECTRICAL VOLTAGE, TOLERANCE IN LAMPS, AND OTHER VARIABLE FIELD CONDITIONS.

FOR ADDITIONAL LIGHTING INFORMATION CONTACT:

**On-Site Lighting
& Survey, LLC**

PH: 763.684.1548

LUMINAIRE SCHEDULE						
Symbol	Qty	Label	Arrangement	LLF	Description	BUG Rating
	8	L-2	Back-Back	0.900	NEW POLE AND AREA FIXT 339W LED T5LS 40'-0 MTG HT (4000K/47005 LUMENS) VISIONAIRE VMX-II_T5LS_45L_4K	B5-U0-G4
	8	M-1	Single	0.900	NEW POLE AND AREA FIXTURE 65W LED T5LS 15'-0 MTG HT (4000K/9719 LUMENS) VISIONAIRE ODN-1_T5LS_10L_4K	B4-U0-G2
	2	N-1	Single	0.900	NEW POLE AND AREA FIXT 277W LED T5LS 40'-0 MTG HT (4000K/40771 LUMENS) VISIONAIRE VMX-II_T5LS_40L_4K	B5-U0-G4
	2	O-1	Single	0.900	NEW POLE AND AREA FIXT 277W LED T5LS HS 40'-0 MTG HT (4000K/11292 LUMENS) VISIONAIRE VMX-II_T5LS_40L_4K_HS	B1-U0-G2