
 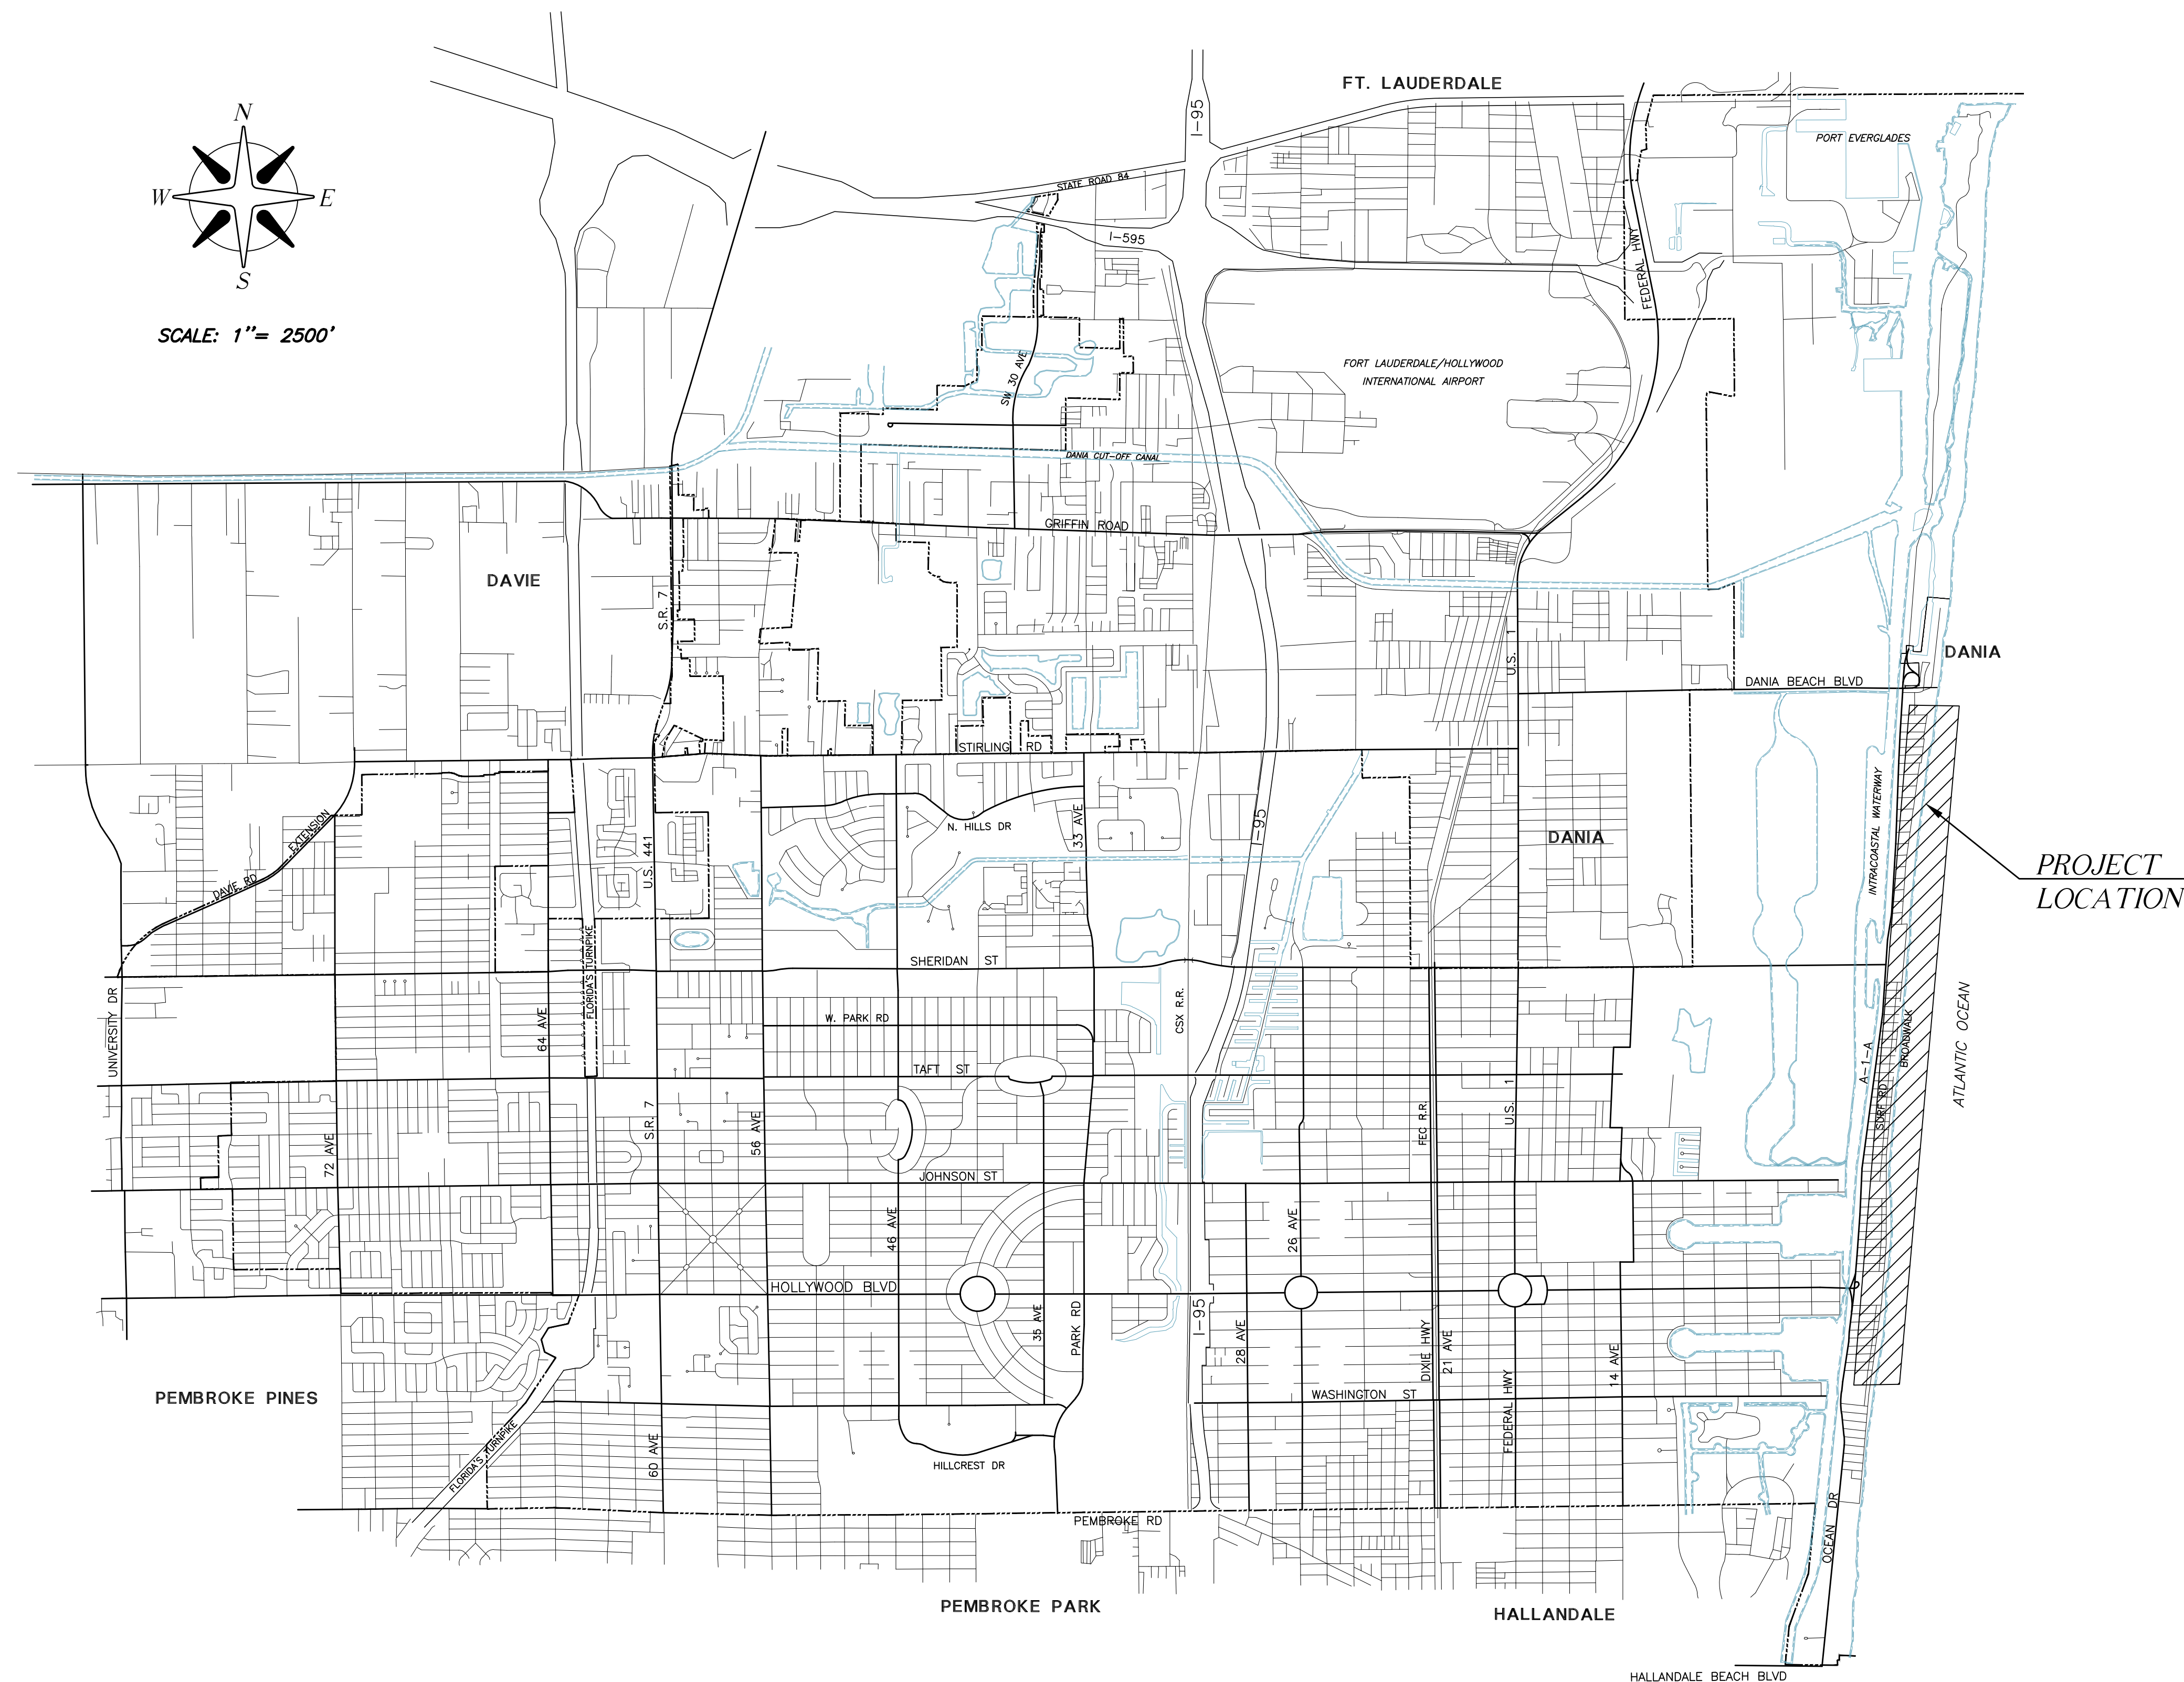




3. NO TRENCHES OR HOLES NEAR WALKWAYS, IN ROADWAYS OR THEIR SHOULDERS ARE TO BE LEFT OPEN OVERNIGHT WITHOUT THE WRITTEN PERMISSION OF THE CITY OF HOLLYWOOD ENGINEER.
4. THE CITY OF HOLLYWOOD HAS A NOISE ORDINANCE (CHAPTER 100) WHICH PROHIBITS EXCAVATION & CONSTRUCTION BEFORE 7:00 A.M. AND AFTER 6:00 P.M., MONDAY THRU FRIDAY. WORK IS ALLOWED 8:00 A.M. TO 6:00 P.M. ON SATURDAYS. NO WORK IS ALLOWED ON SUNDAYS.
5. THE LOCATION, SIZE AND MATERIAL OF THE EXISTING UTILITIES AND STRUCTURES HAVE BEEN RECORDED FROM THE MOST RELIABLE INFORMATION AVAILABLE TO THE ENGINEER. THIS INFORMATION IS NOT GUARANTEED. ADDITIONAL UTILITIES MAY EXIST WHICH ARE NOT SHOWN ON THESE PLANS. THE CONTRACTOR SHALL BE RESPONSIBLE FOR LOCATING AND VERIFYING ALL UTILITIES PRIOR TO BEGINNING CONSTRUCTION. ANY AND ALL CONFLICTS WITH EXISTING UTILITIES SHALL BE REPORTED TO THE CITY OF HOLLYWOOD DEPARTMENT OF PUBLIC UTILITIES. THIS WORK BY THE CONTRACTOR SHALL BE CONSIDERED INCIDENTAL TO THE CONTRACT AND NO ADDITIONAL COMPENSATION SHALL BE ALLOWED.
6. CONTRACTOR SHALL REPLACE IN KIND ALL ITEMS DAMAGED BY THEIR OPERATIONS.
7. IT SHALL BE THE CONTRACTOR'S RESPONSIBILITY TO VISIT JOB SITE(S) PRIOR TO BIDDING.
8. SUITABLE EXCAVATED MATERIAL SHALL BE USED IN FILL AREAS. NO SEPARATE PAY ITEM FOR THIS WORK, INCLUDE COST IN OTHER ITEMS.

INDEX OF SHEETS	
SHEET NO.	DESCRIPTION
CVR	COVER
KP-1	KEY PLAN
E-1	LIGHT POLES LOCATION, NORTH BEACH
E-2	LIGHT POLES LOCATION, BROADWALK AT NORTH BEACH PARK
E-4	LIGHT POLES LOCATION, SUMMIT PARKING LOT
D-1	ELECTRICAL DETAILS

SEAL

10-013 PHASE III


City of Hollywood, Florida
Department of
Development Services.
Engineering Services Division

SCALE	1" = 20'
DESIGNED	
DRAWN	
ISSUE DATE	2/21/18

**POLES REPLACEMENT. PHASE III
DESOTO ST. TO AZALEAH TER.
COVER**

SHEET
CVR
OF

[illegible]

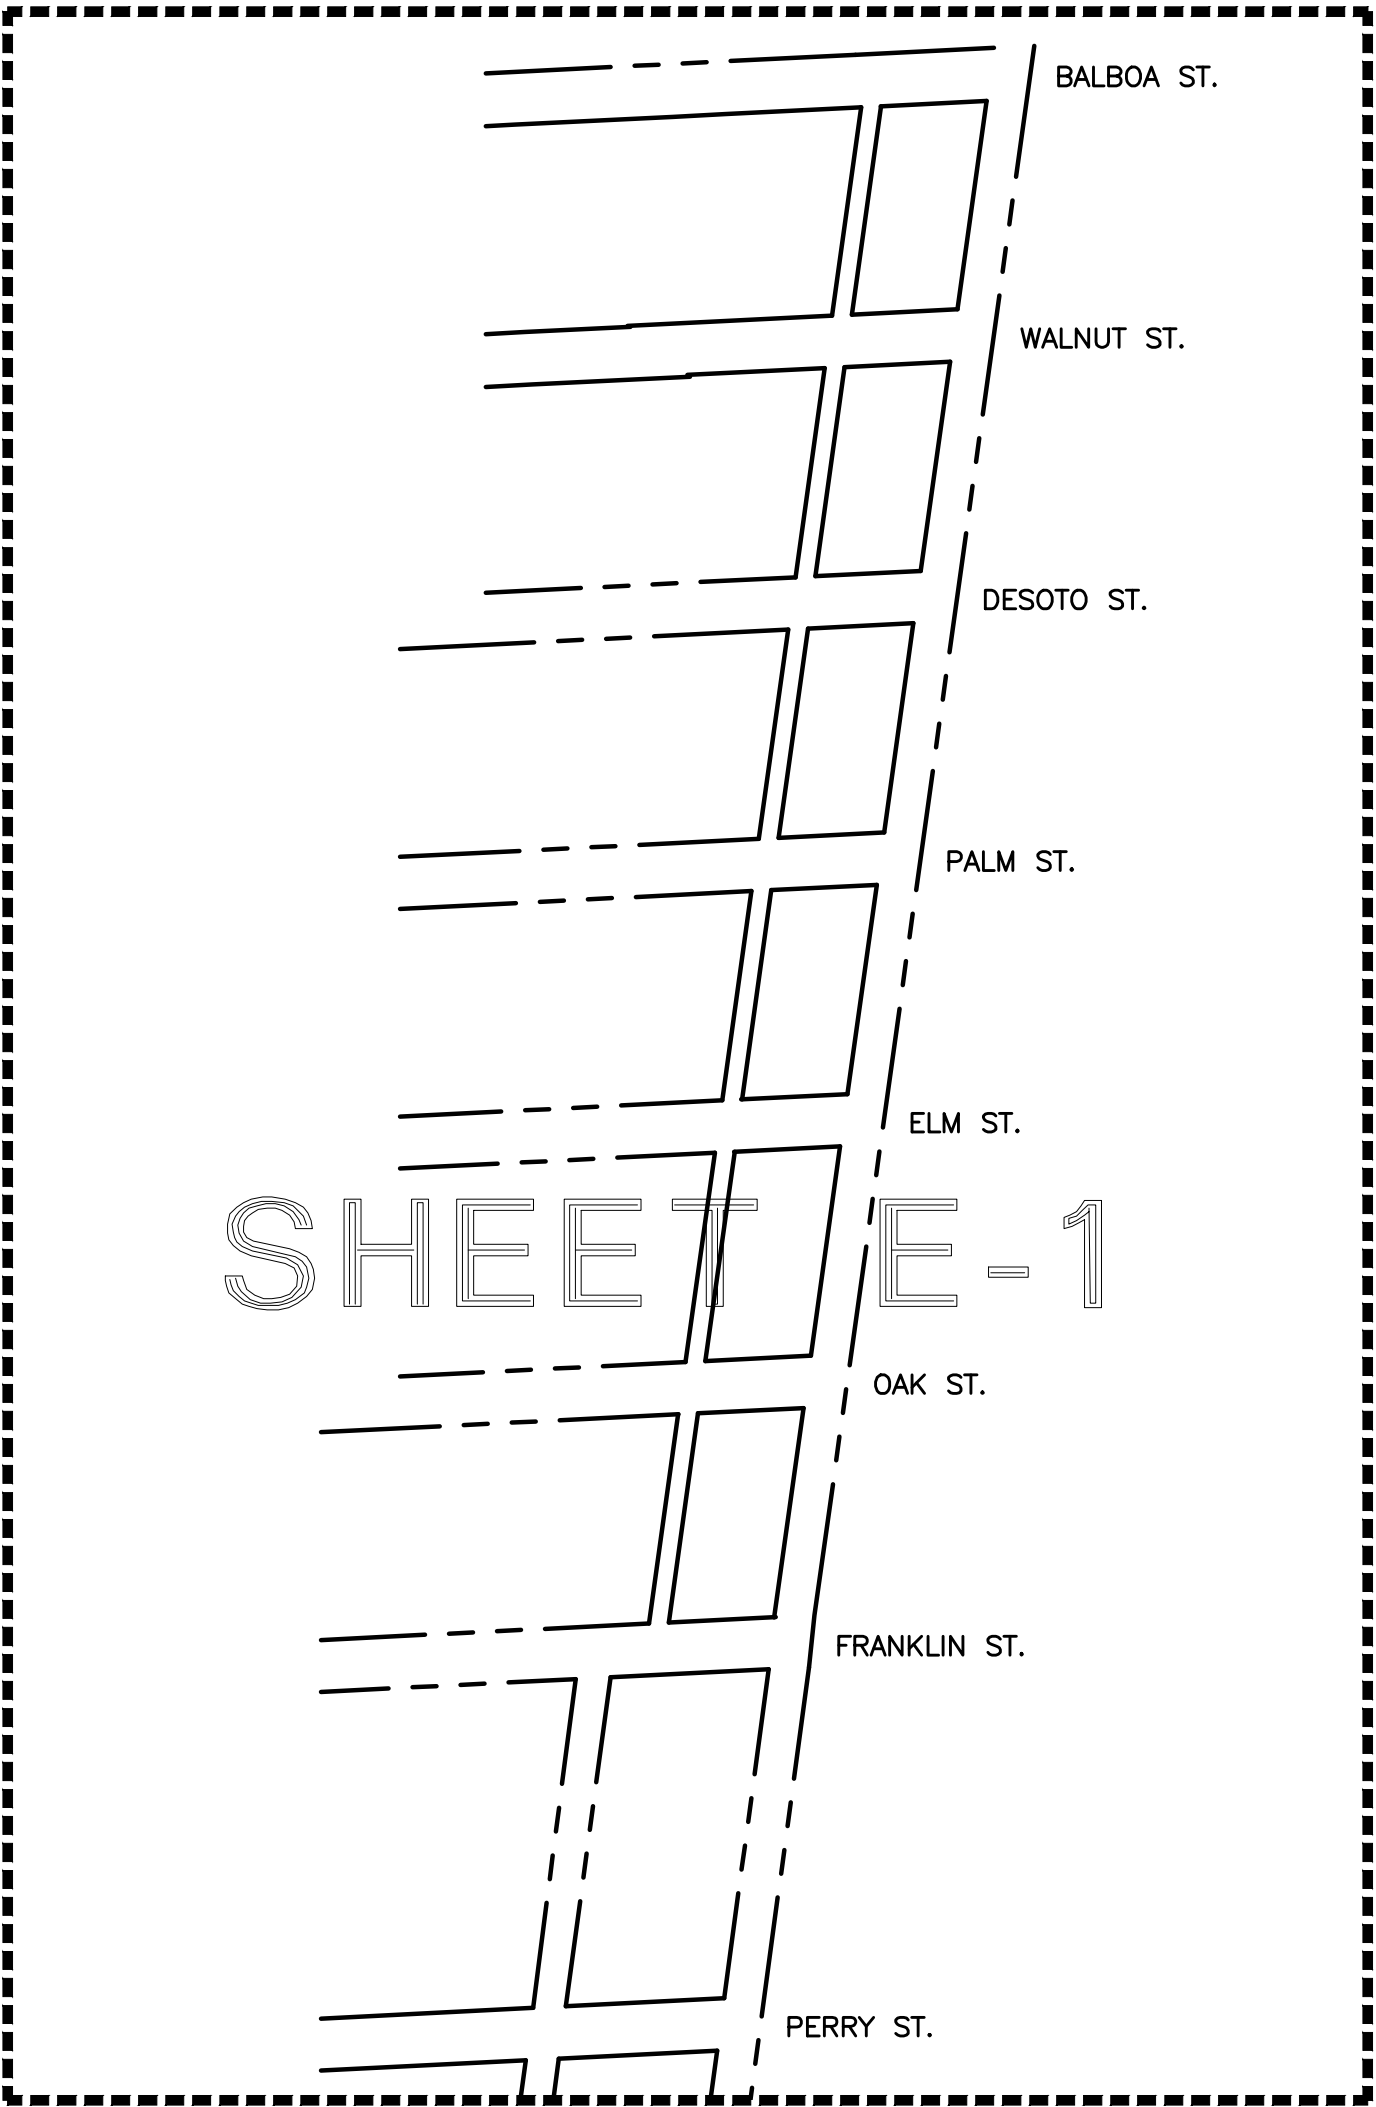

SIMMS ST.

NORTH BEACH
PARK

SHEET E-2

SHERMAN ST.

JEFFERSON ST.

SHEET E-4

AZALEA TERRACE

SEAL

10-013 PHASE III


OF

KEY PLAN


SCALE 1" = 20'

DESIGNED

ISSUE DATE 2/21/18

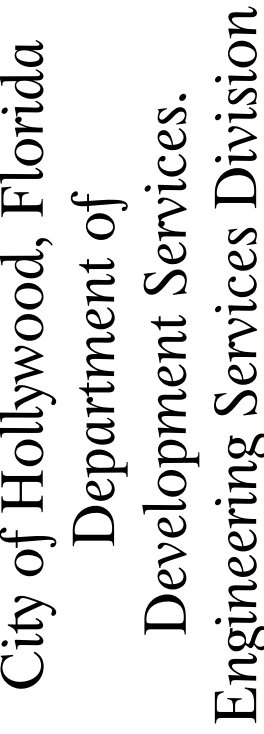[illegible]

REVISIONS

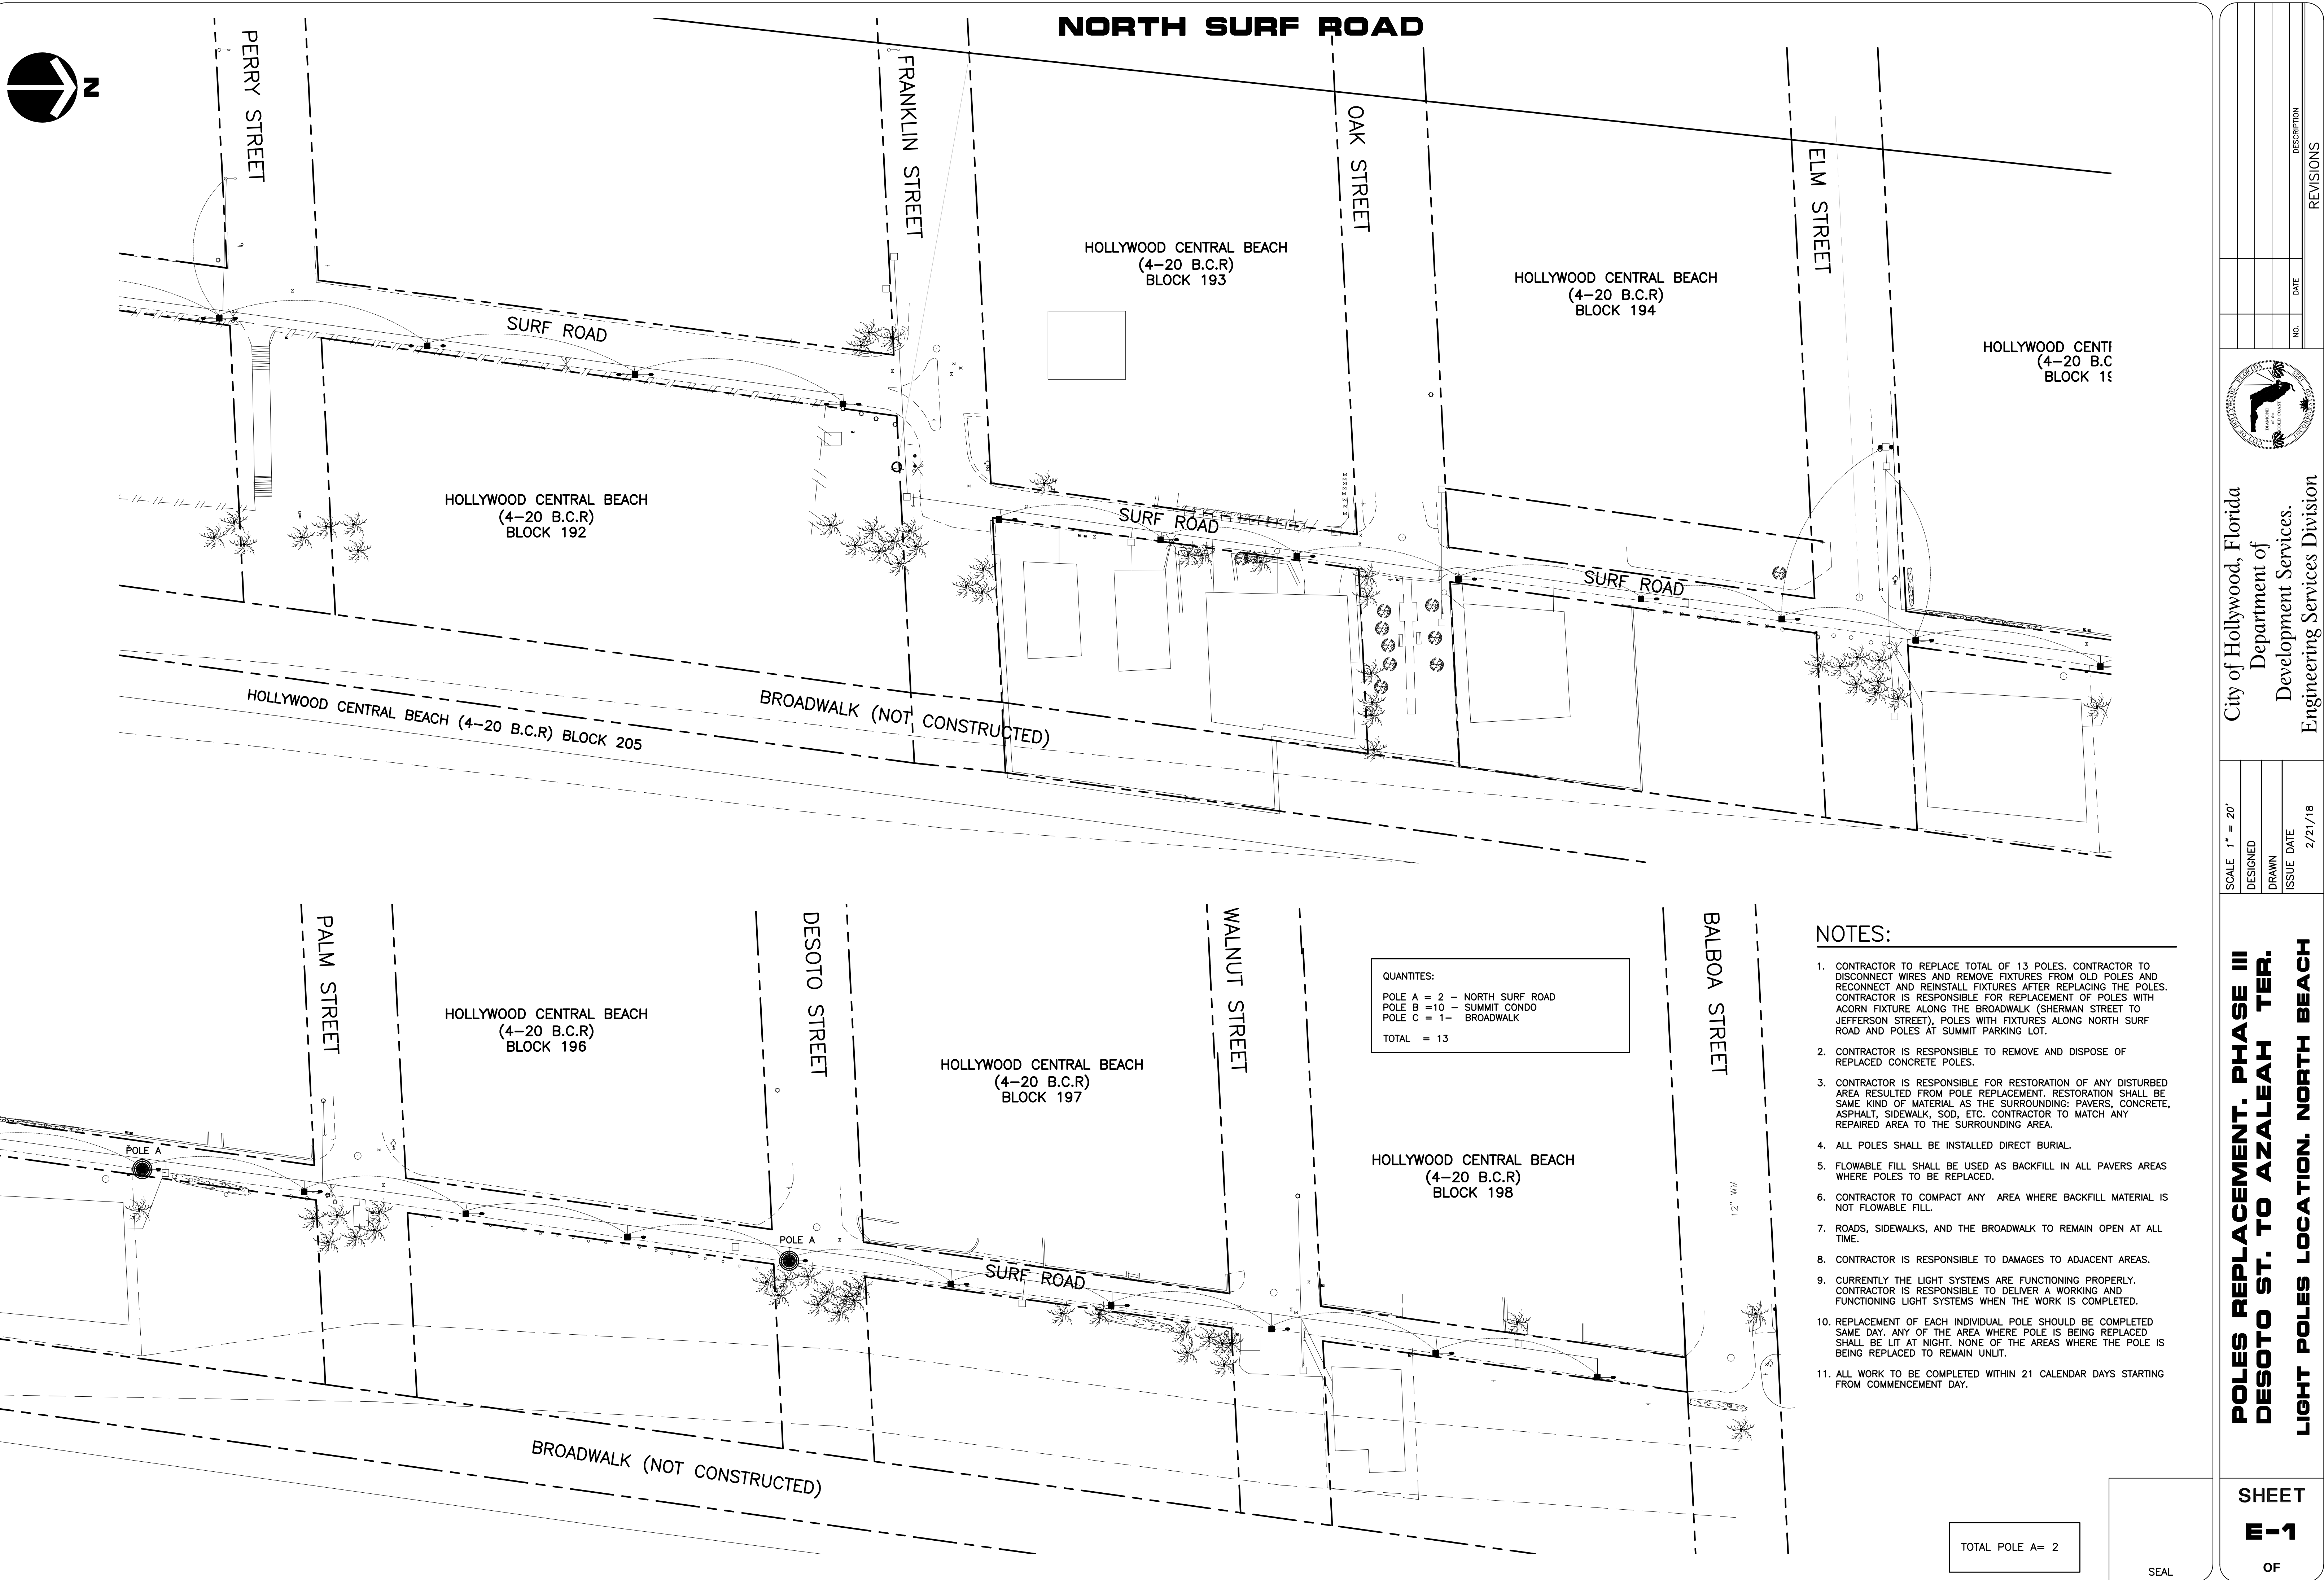

SEA

SHEET
E-1
OF

**POLES REPLACEMENT. PHASE III
DESOTO ST. TO AZALEAH TER.
LIGHT POLES LOCATION. NORTH BEACH**

SCALE	1" = 20'
DESIGNED	
DRAWN	
ISSUE DATE	2/21/18

City of Hollywood, Florida
Department of
Development Services.
Engineering Services Division

[illegible]

BROADWALK AT NORTH BEACH PARK

10 ADDITION
SURF ROAD
BLOCK 11

SHERMAN ST.

HOLLYWOOD BEACH SECOND ADDITION (4-6) BLOCK 'A'

HOLLYWOOD BEACH SECOND ADDITION (4-6) BLOCK 'C'

BROADWALK

POLE C

HCB 4-20 BLOCK 178

BLOCK 205

HOLLYWOOD CENTRAL BEACH (4-20 B.C.R) BLOCK 178

SURF ROAD

SIMMS ST.

SEAPORTS

HOLLYWOOD CENTRAL BEACH (4-20 B.C.R) BLOCK 179

BROADWALK

HOLLYWOOD CENTRAL BEACH (4-20 B.C.R) BLOCK 205


HOLLYWOOD CENTRAL BEACH (4-20 B.C.R) BLOCK 179

TOTAL POLE C= 1

SHEET
E-2
OF


City of Hollywood, Florida
Department of
Development Services.
Engineering Services Division

[illegible]

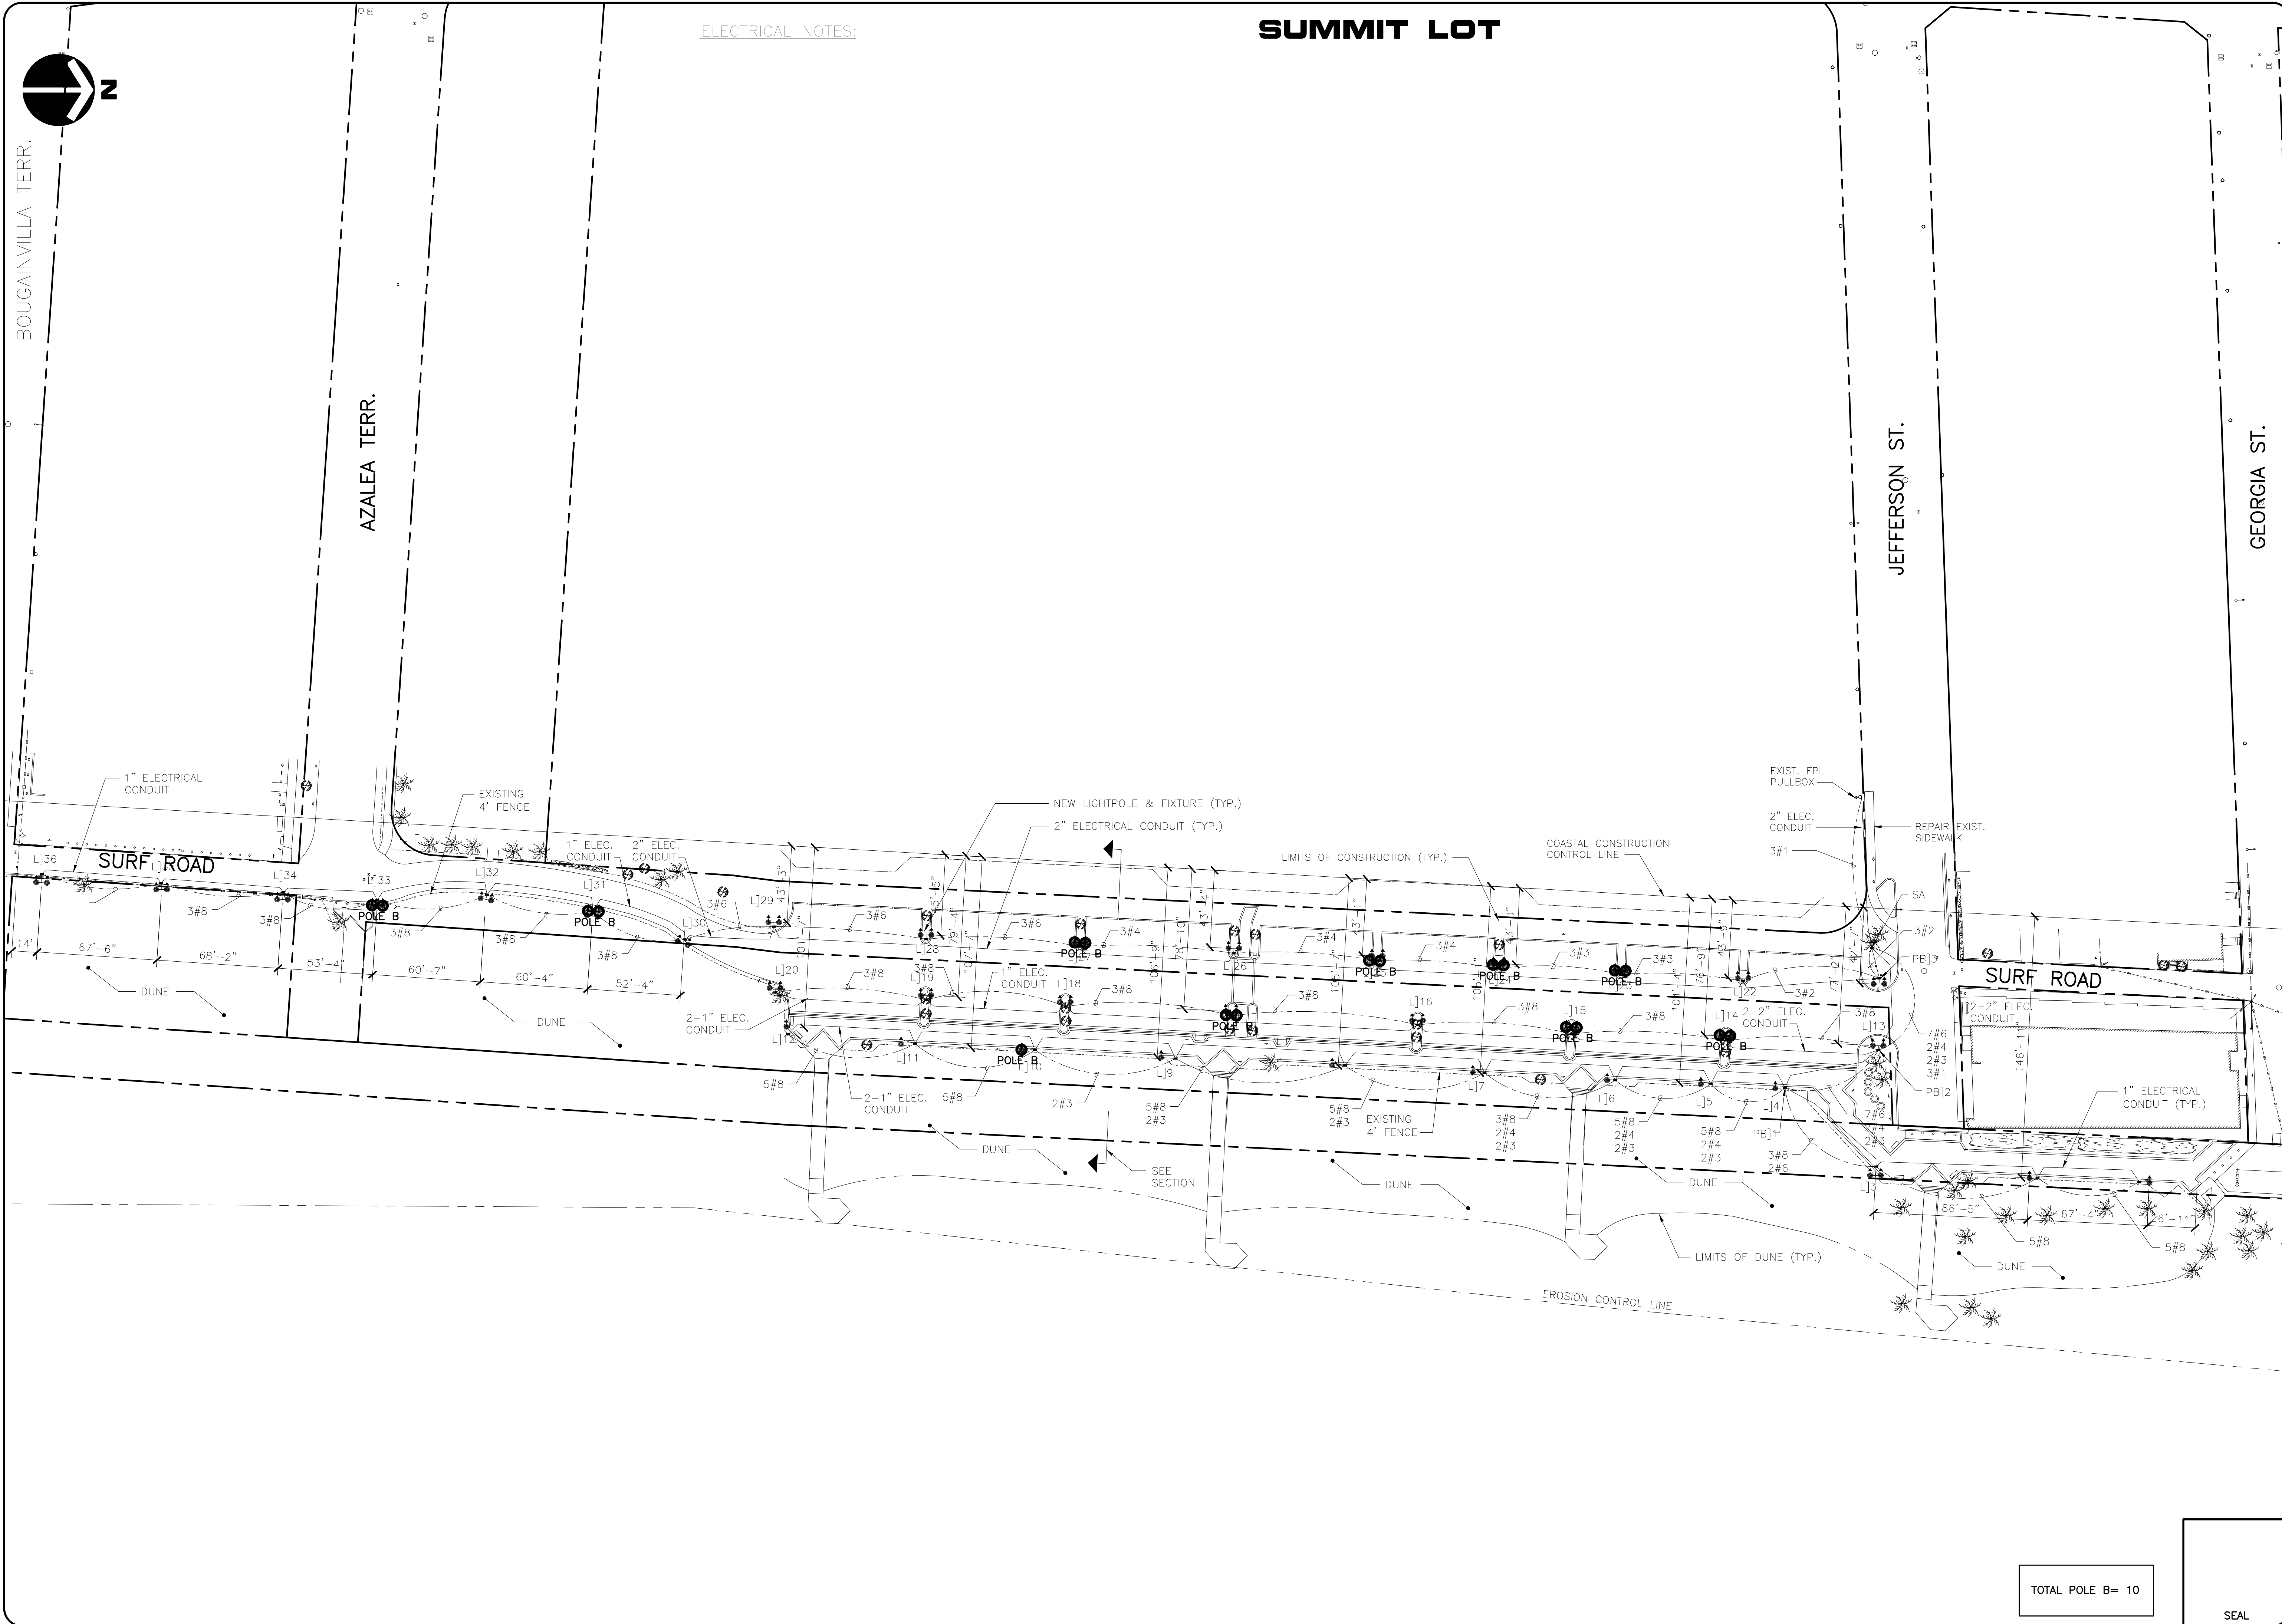

ELECTRICAL NOTES:

SUMMIT LOT

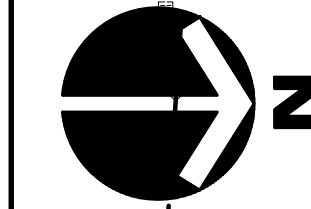

TOTAL POLE B= 10

SEAL







POLES REPLACEMENT. PHASE III
DESOTO ST. TO AZALEAH TER.
LIGHT POLES LOCATION.
SUMMIT PARKING LOT

SCALE 1" = 20'
DESIGNED
DRAWN
ISSUE DATE 2/21/18

City of Hollywood, Florida
Department of
Development Services.
Engineering Services Division



REVISIONS	
NO.	DESCRIPTION

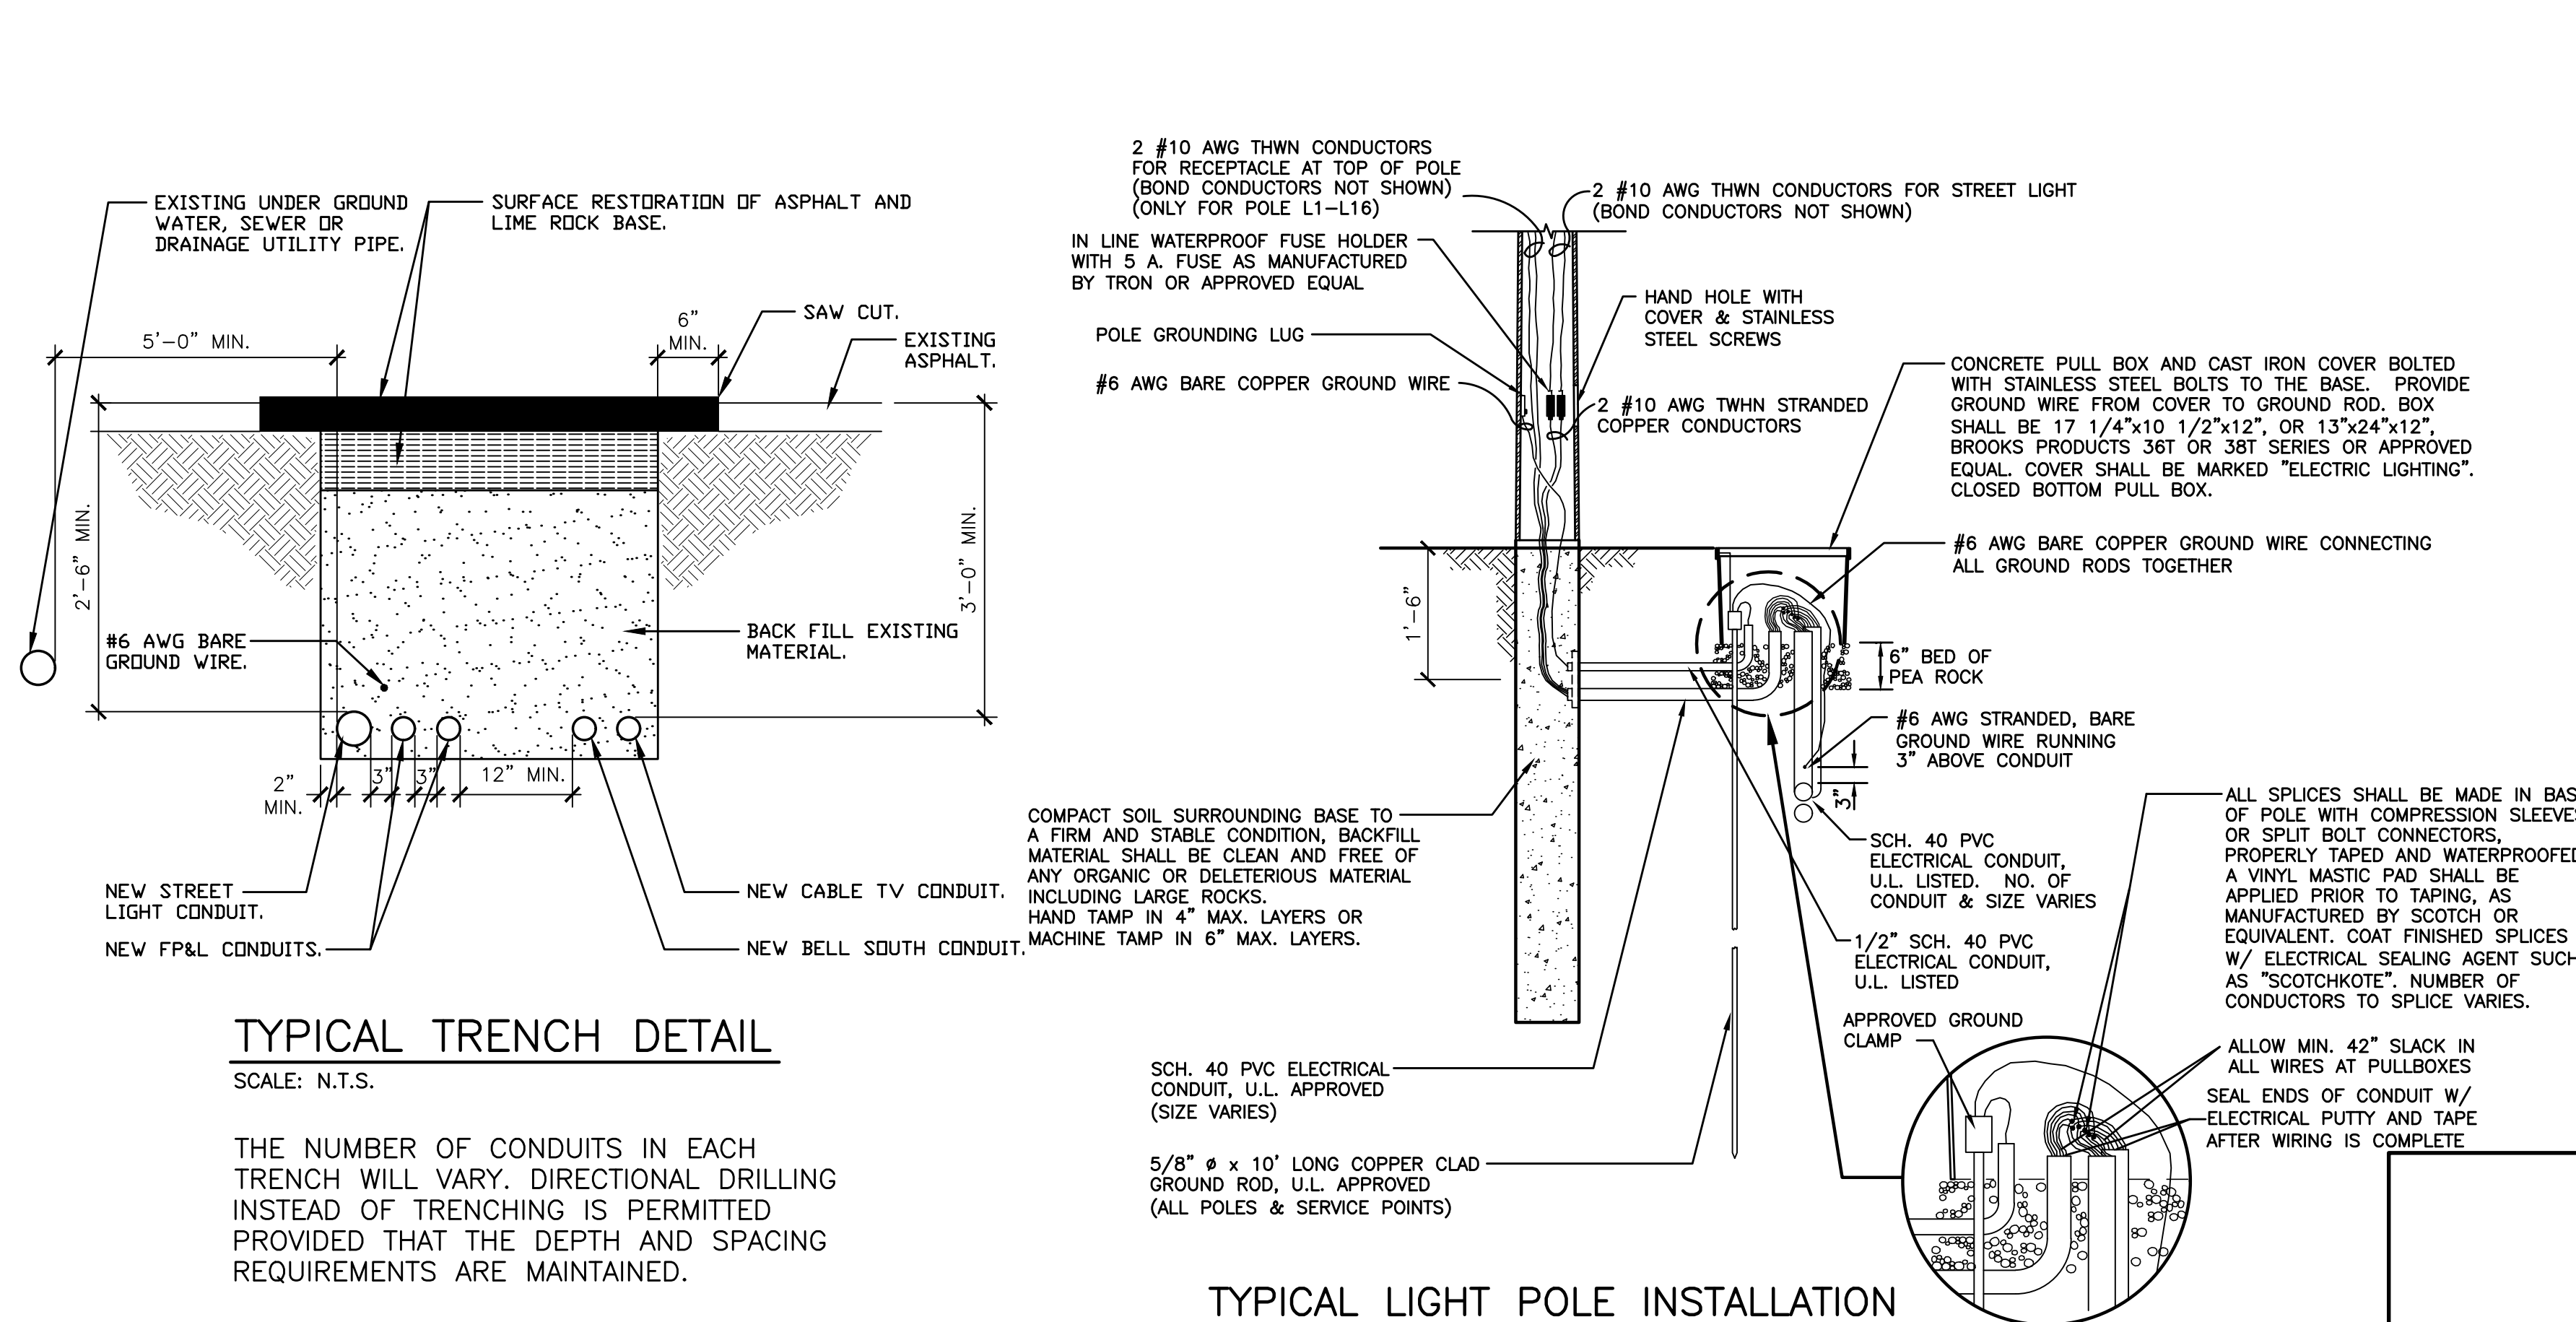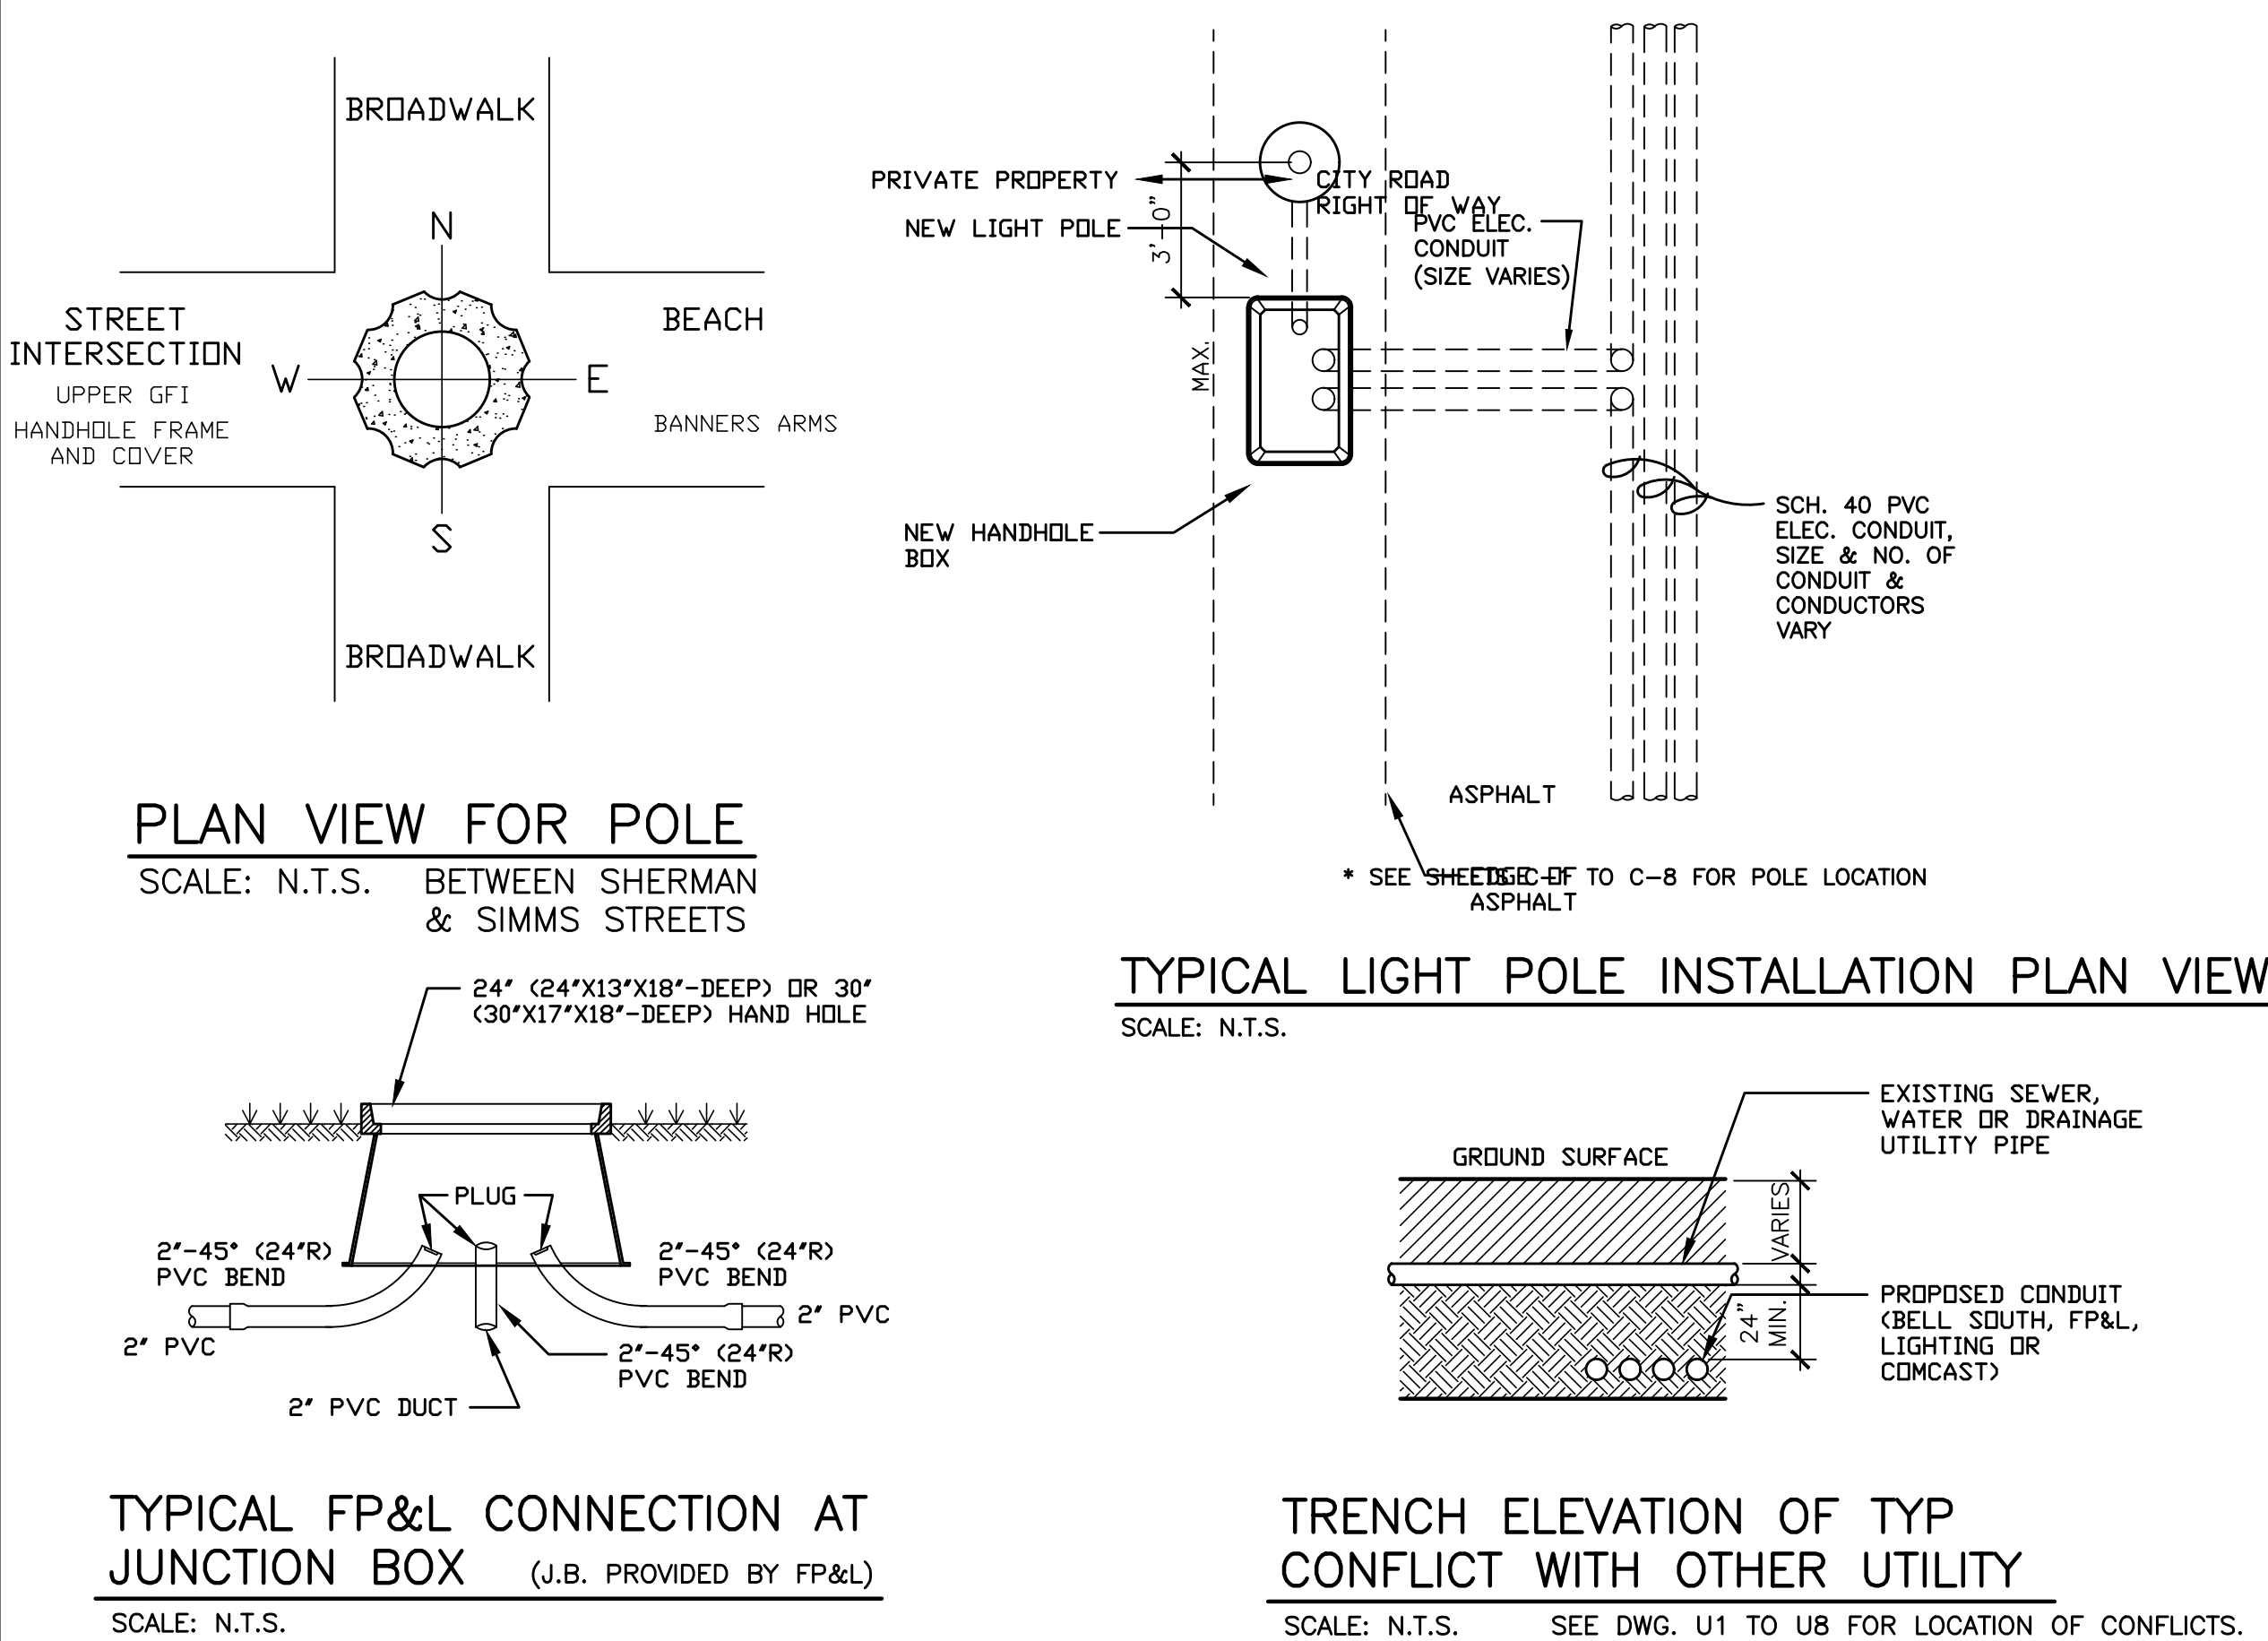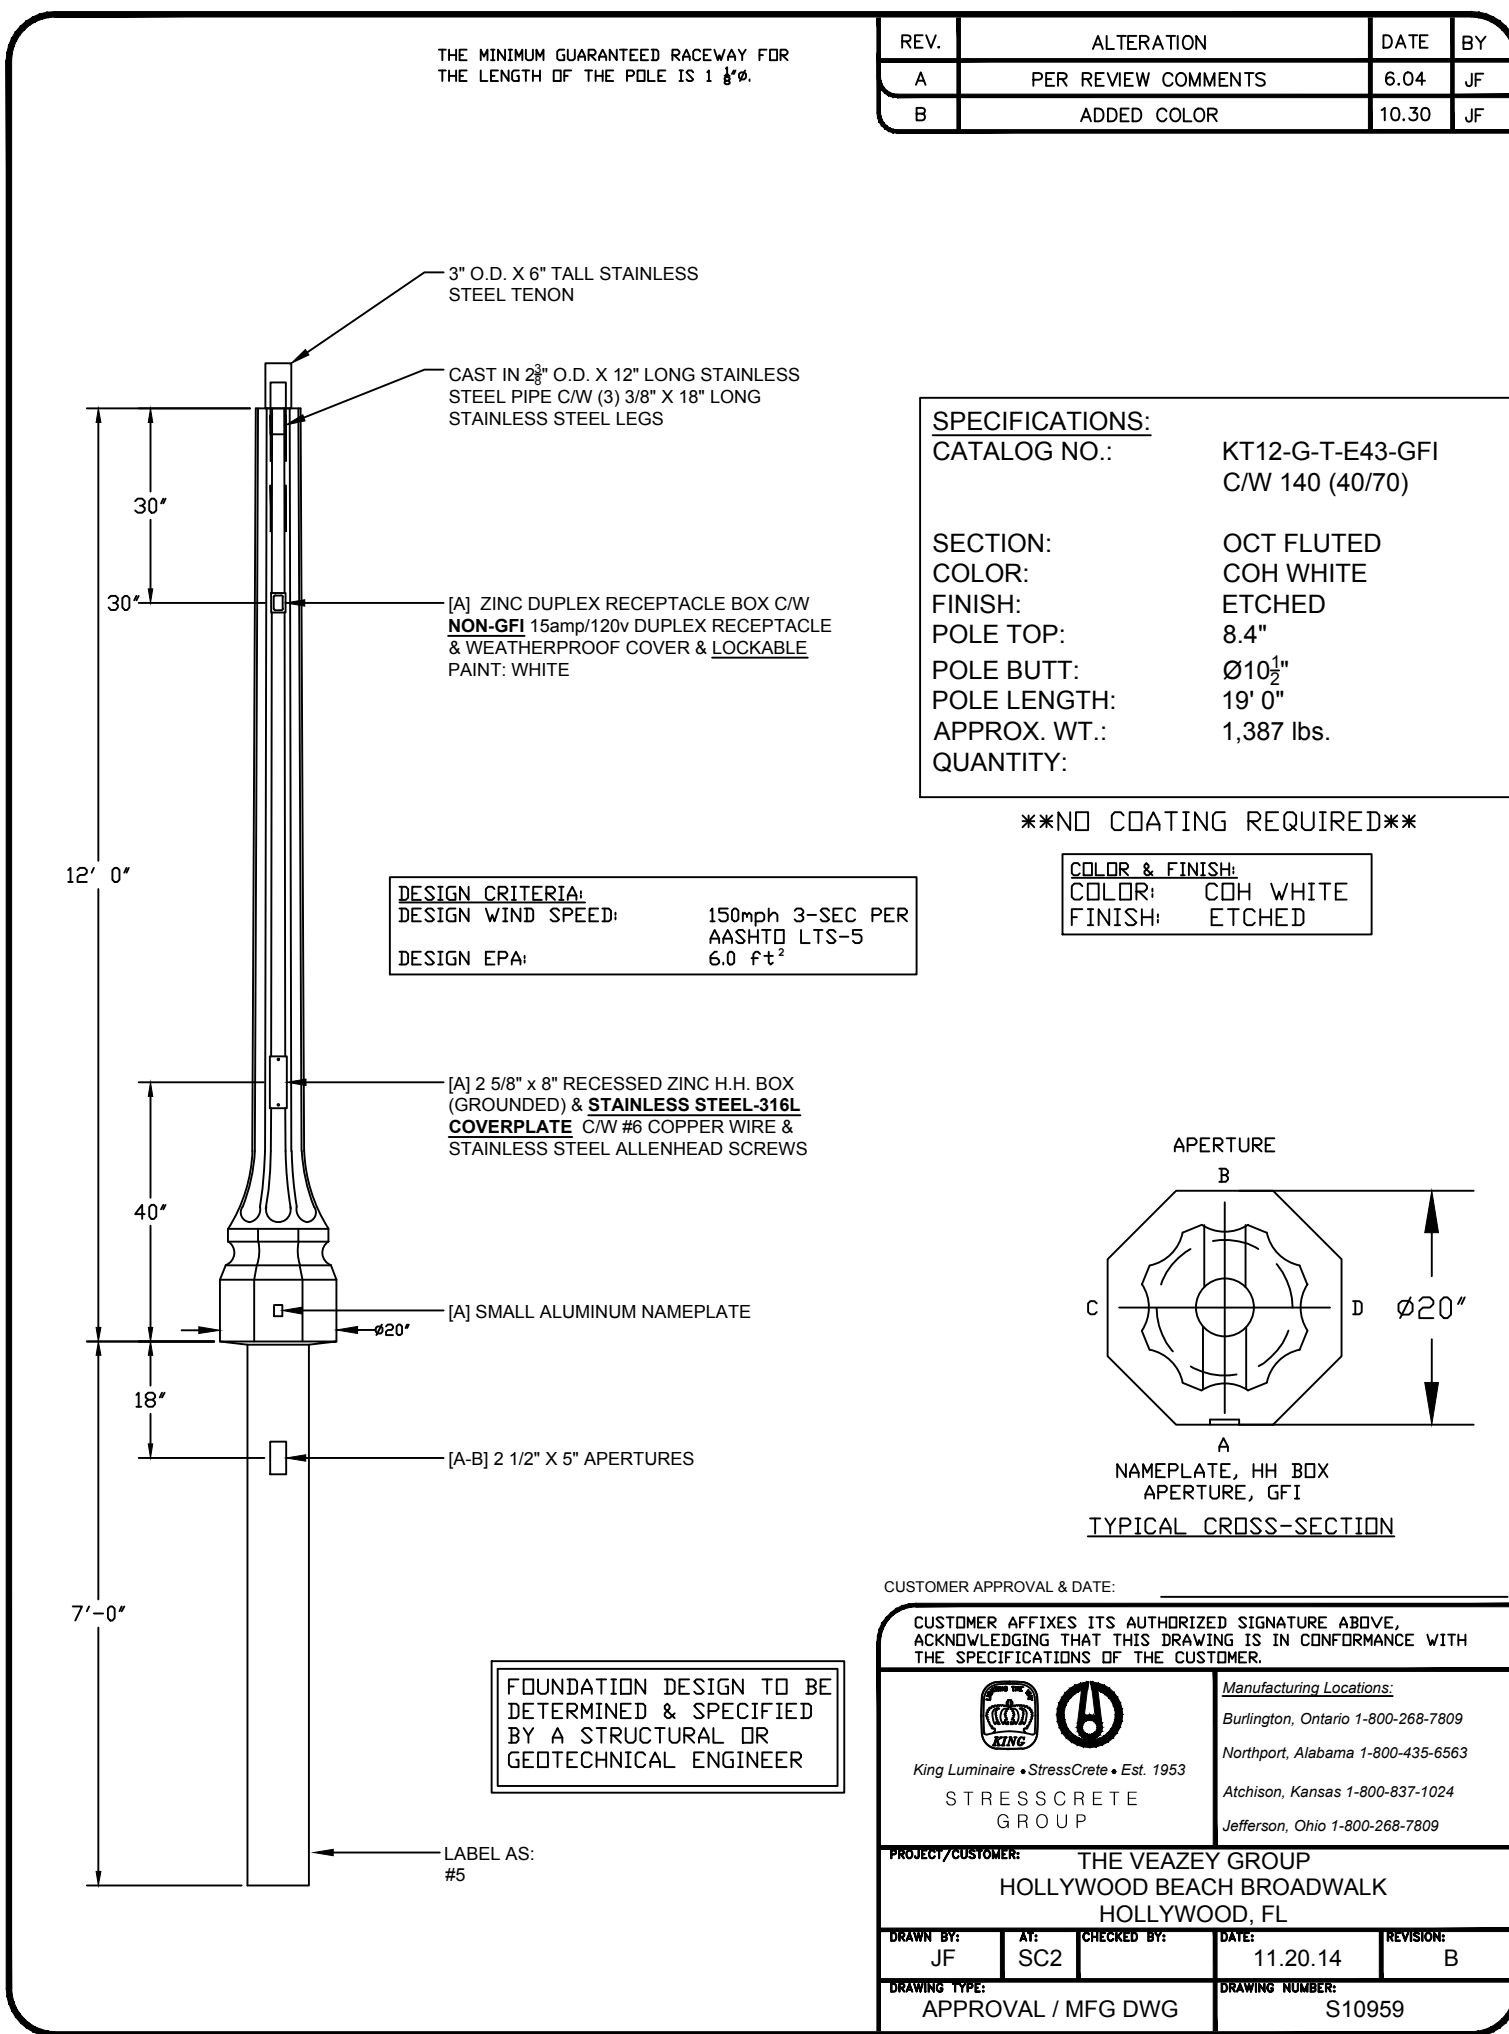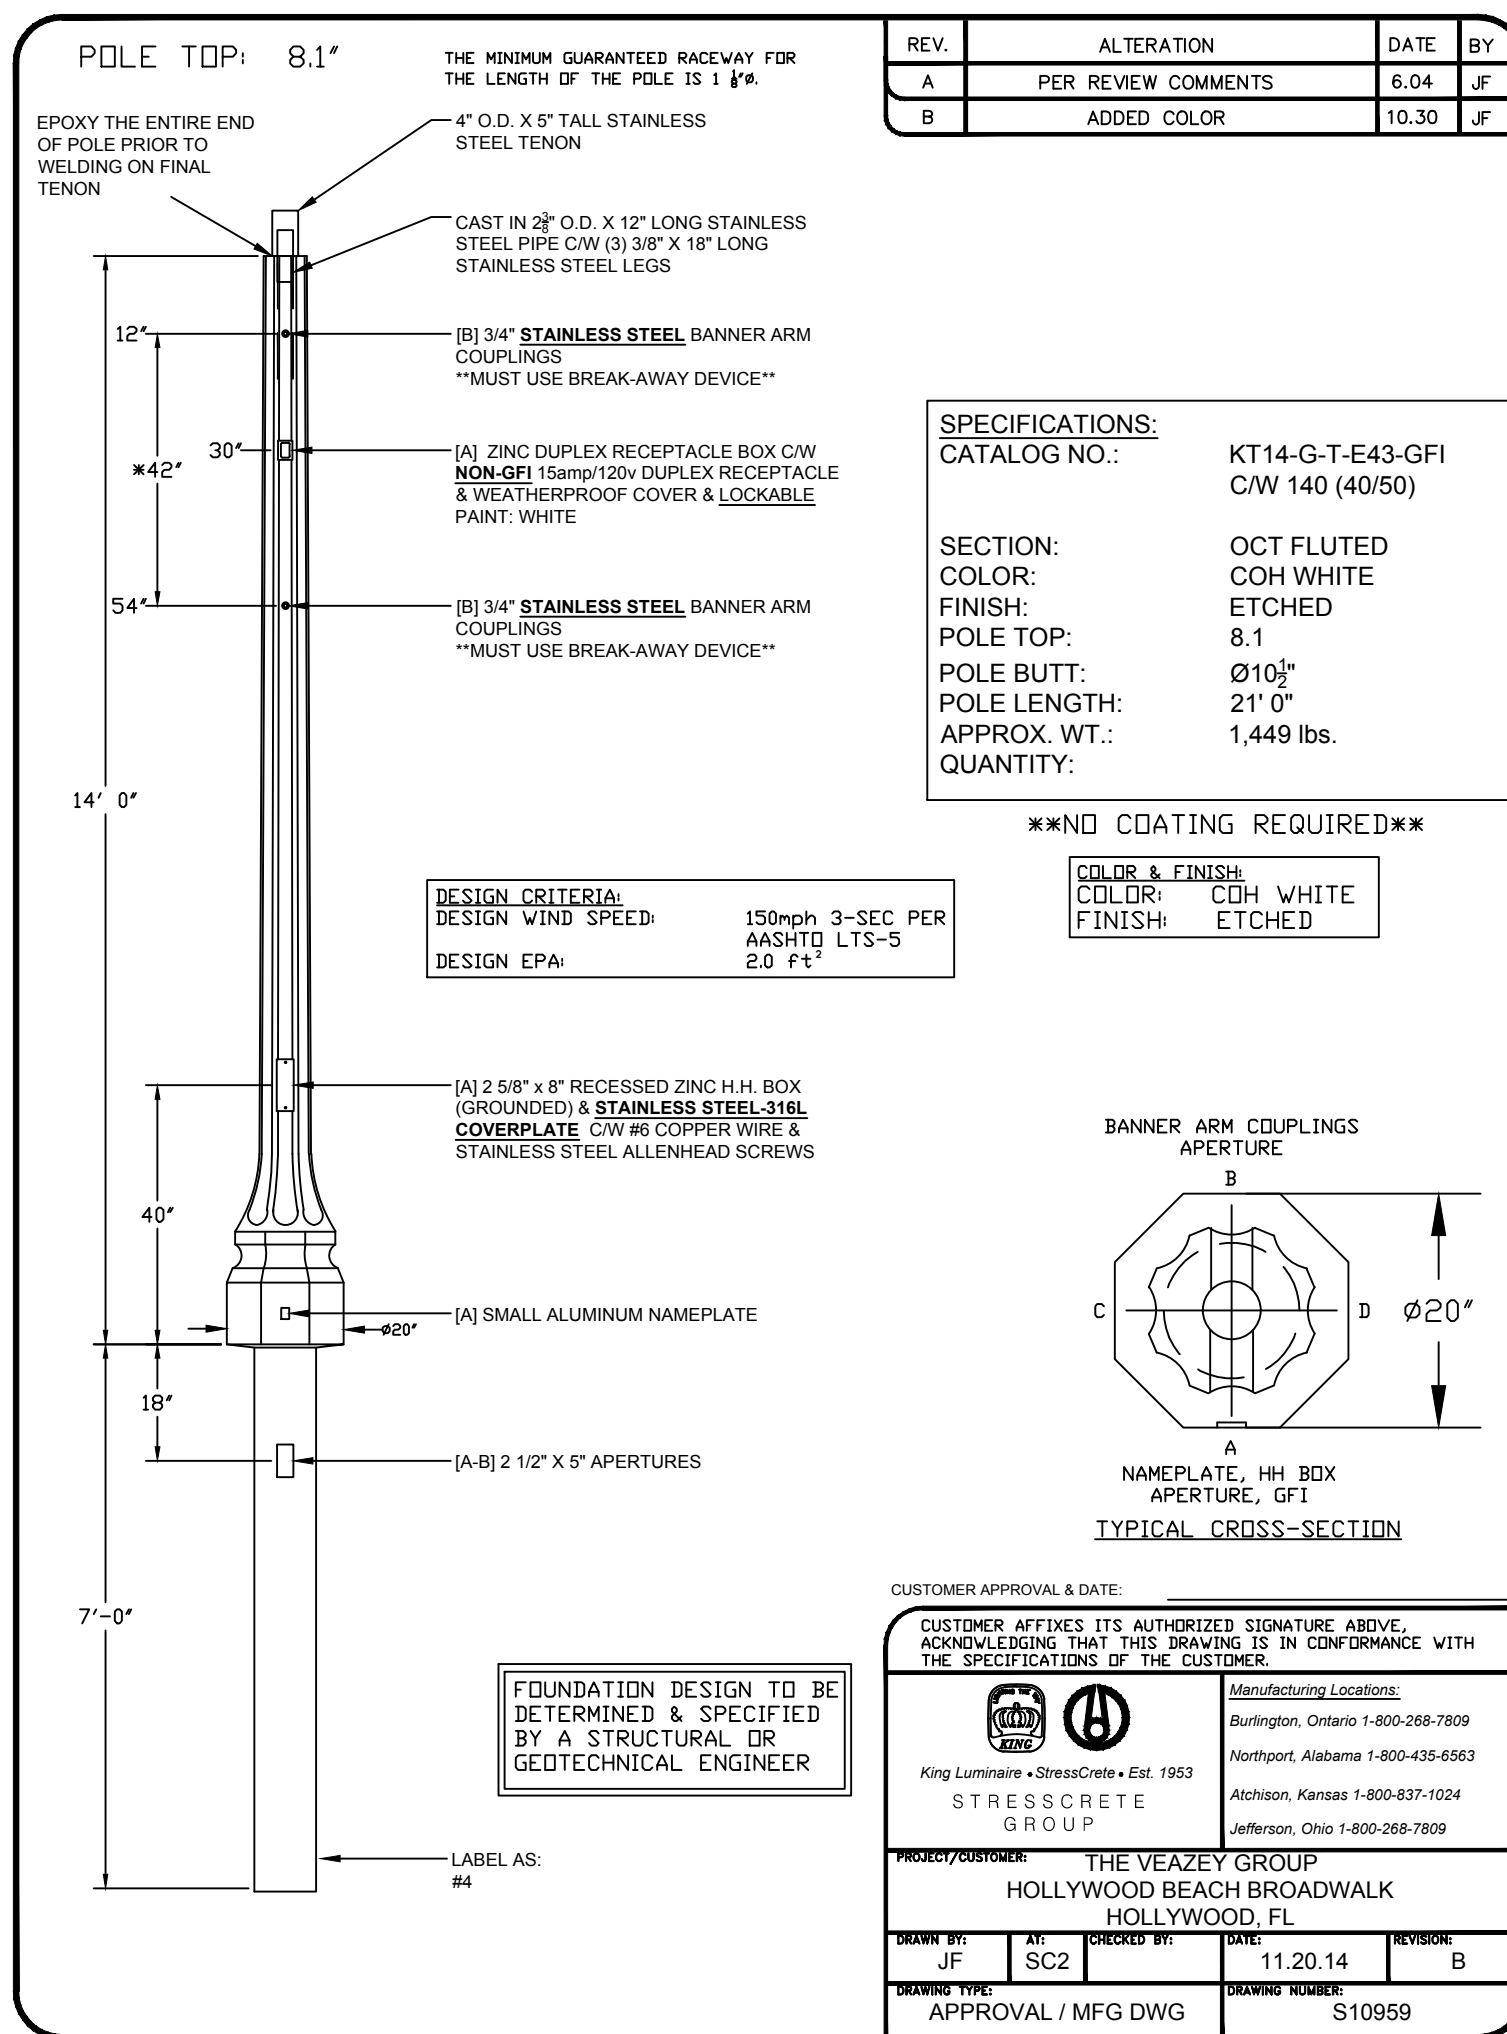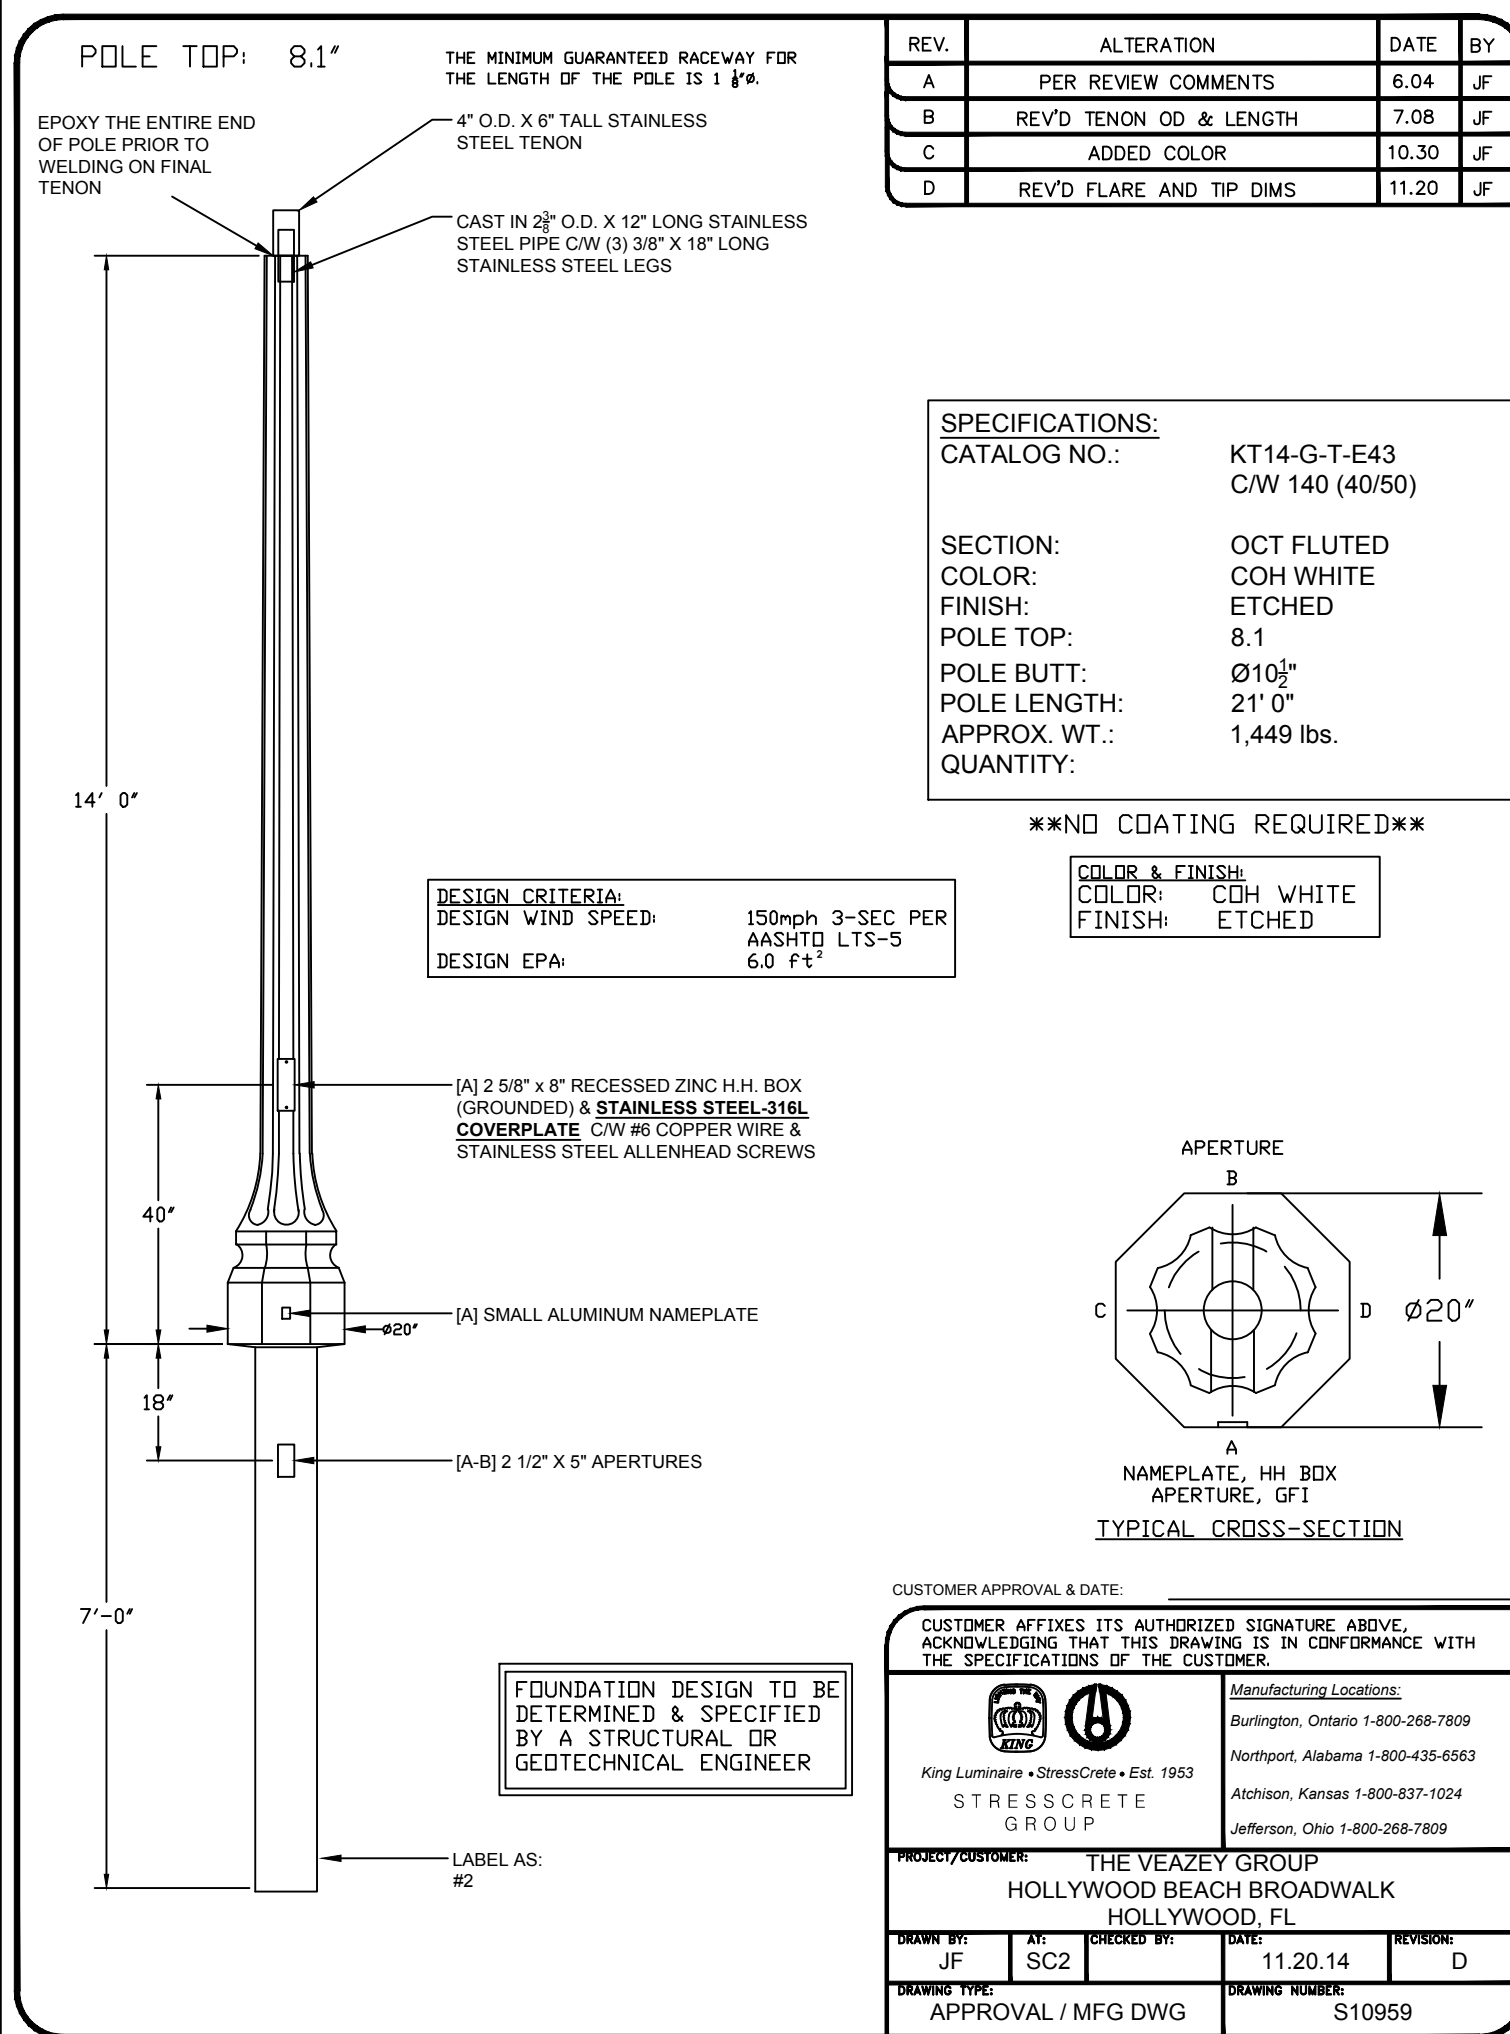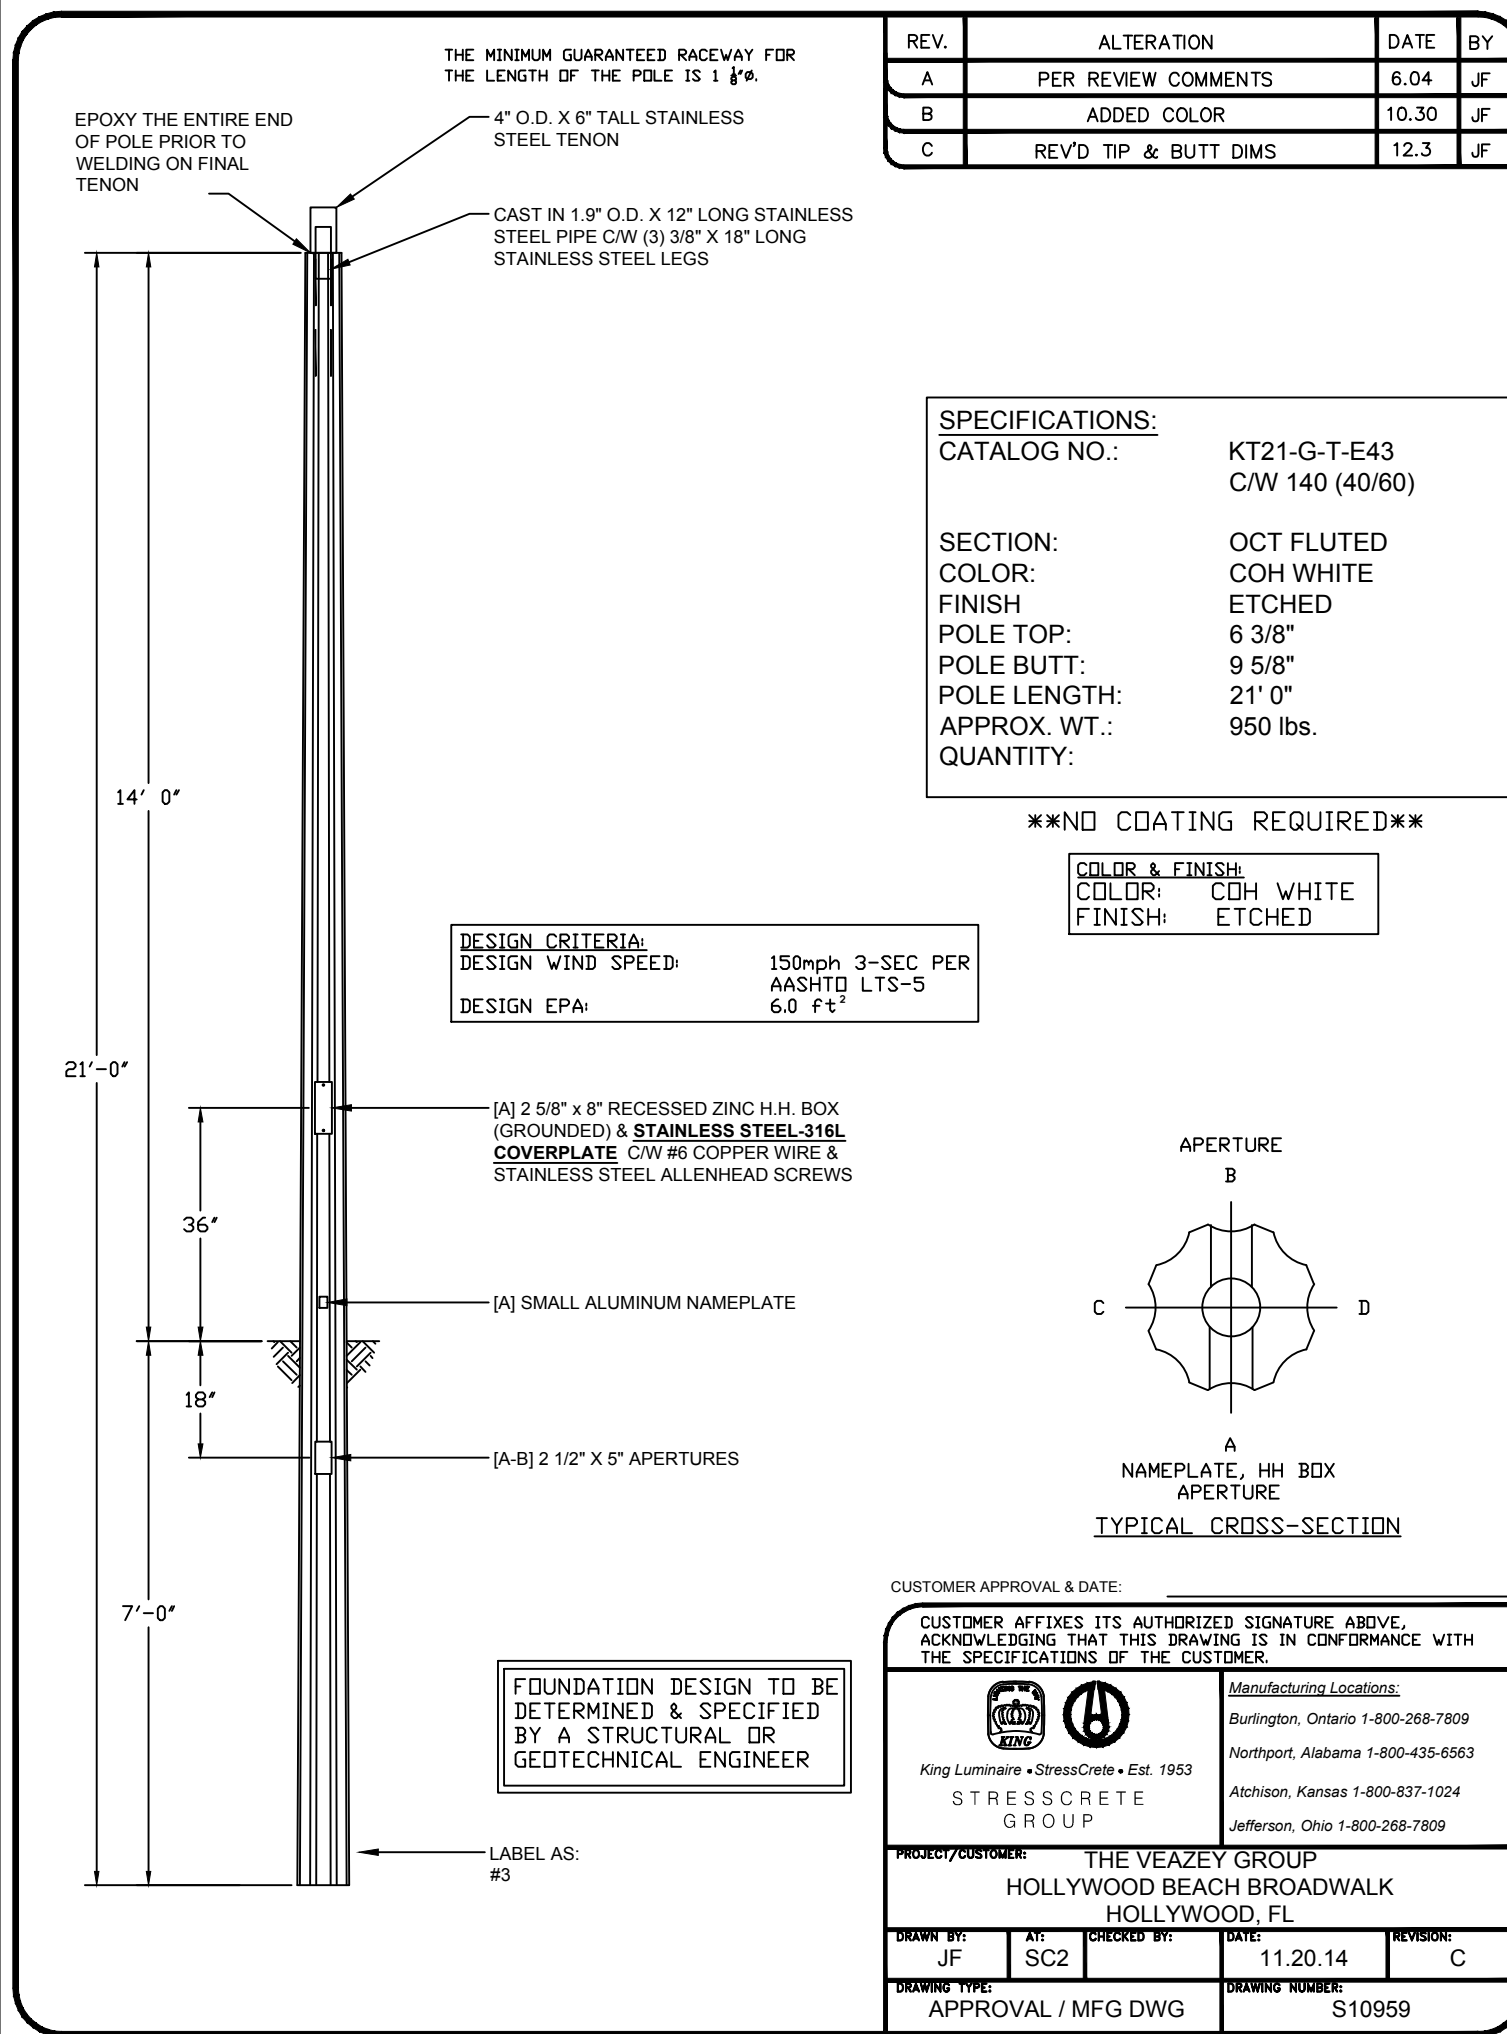

POLES REPLACEMENT. PHASE III
DESOTO ST. TO AZALEAH TER.

SHEET
D-1
 OF

SCALE 1" = 20'
 DESIGNED
 DRAWN
 ISSUE DATE 2/21/18

City of Hollywood, Florida
 Department of
 Development Services.
 Engineering Services Division

NO.	DATE	DESCRIPTION

